


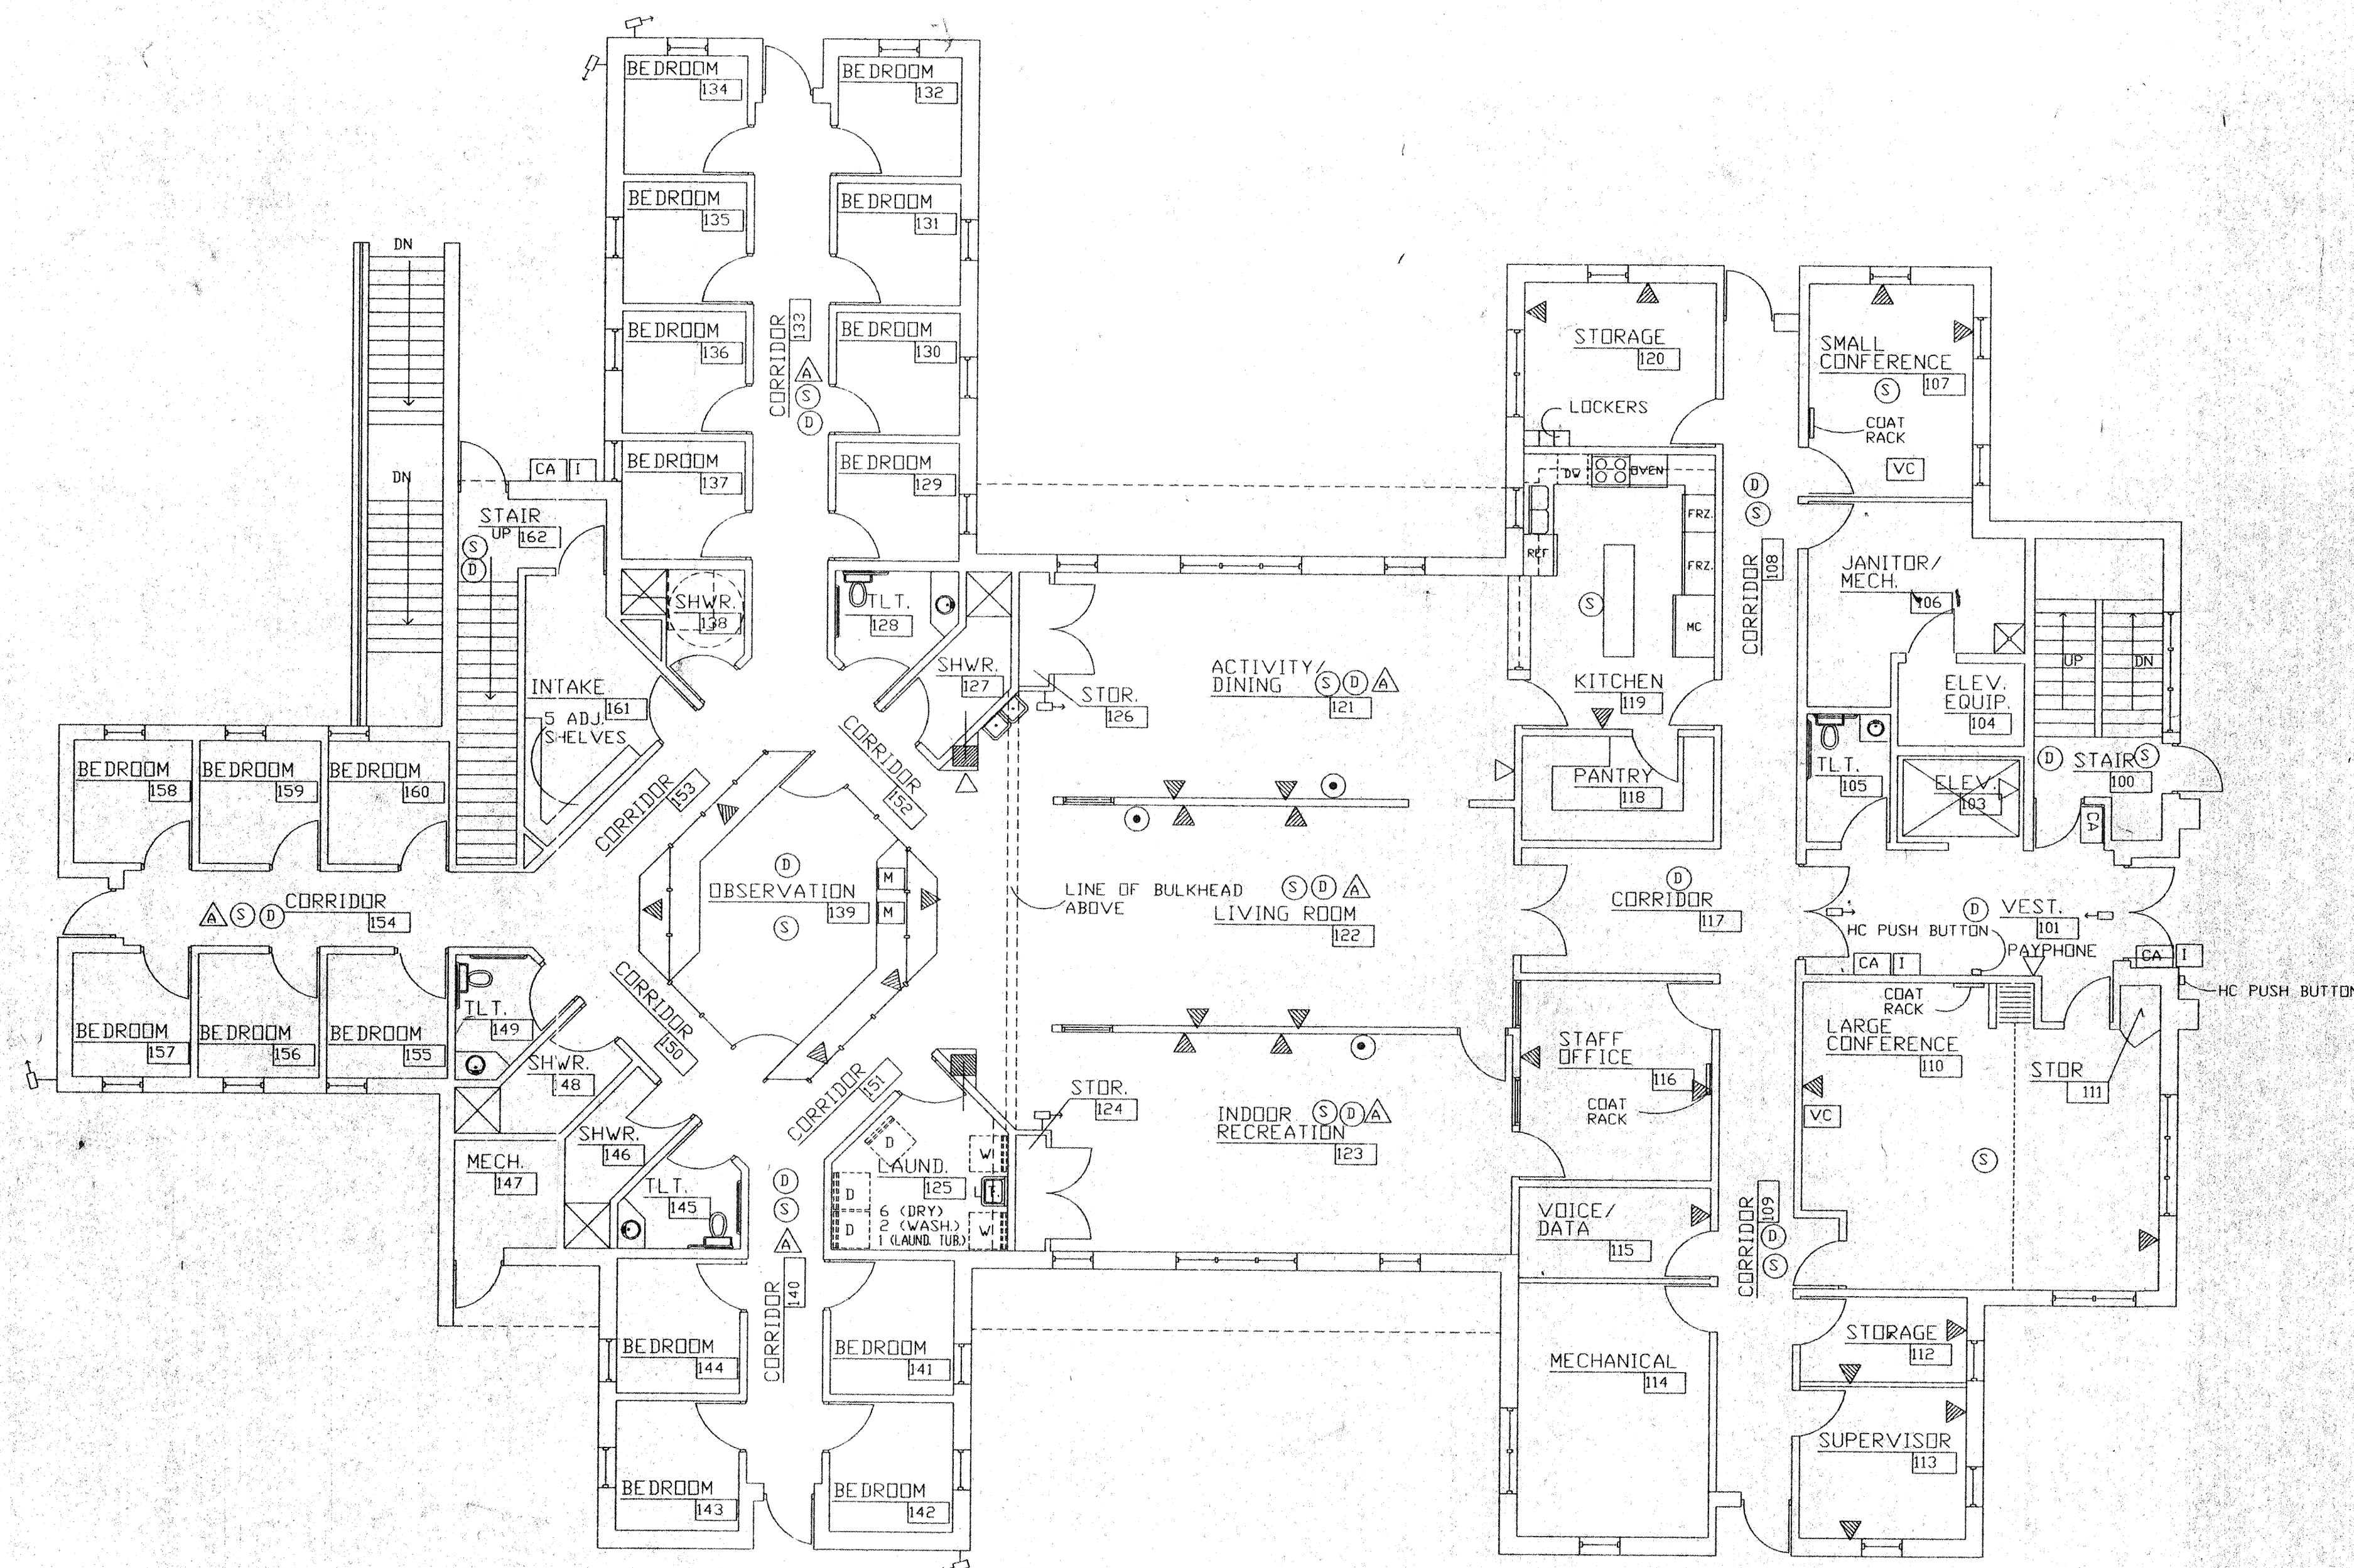

FIRST FLOOR PLAN
 SCALE: 1/8"=1'-0"

- LEGEND
- ▼ VOICE / DATA OUTLET
 - ▽ TELEPHONE OUTLET - WALL PHONE
 - CABLE TV OUTLET, RUN BACK TO VOICE / DATA ROOM
 - ⊙ SPEAKER, MOUNTED IN CEILING
 - VC VIDEO CONFERENCING OUTLET
 - CA CARD ACCESS
 - ⊙ DURESS SYSTEM RECEIVER, MOUNTED IN CEILING
 - CCTV
 - INTERCOM, HEAD END AT OBSERVATION DESK
 - ▲ AUDIO, MOUNTED IN CEILING
 - ⊞ MONITOR 20", MOUNTED IN MILLWORK (ACTUAL SPACE REQUIRED 22"x22"x22" PER MONITOR)