

Seal & Notes
REFLECTED CEILING PLAN KEY

	RECESSED FLUORESCENT FIXTURE
	RECESSED FLUORESCENT FIXTURE
	RECESSED FLUORESCENT FIXTURE
	RECESSED 'CAN' FIXTURE
	SURFACE MOUNTED CAN FIXTURE
	SURFACE MOUNTED FLUORESCENT FIXTURE
	SURFACE MOUNTED FLUORESCENT FIXTURE
	LINEAR DIFFUSER
	HVAC GRILLE (SEE WARES)
	NON-SECURITY GLASS PANEL (SEE WARES)
	SECURITY GLASS PANEL (SEE WARES)

[illegible]

	A						
--	---	--	--	--	--	--	--

[illegible]

PLASTER CEILING

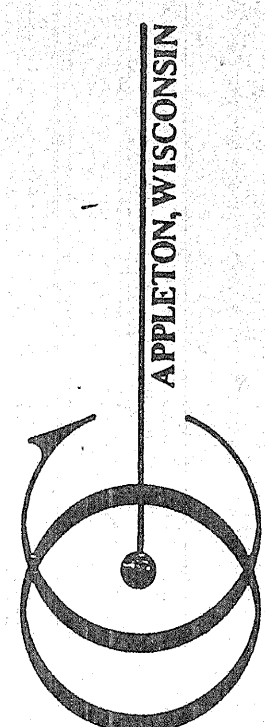
GWB CEILING

R.C.P. NOTES:

***VERIFY ALL REQUIRED AMOUNTS, LOCATIONS AND SIZES OF PLUMBING, HVAC, & ELECTRICAL V/RESPECTIVE MECHANICAL DRAWINGS

***ALL ACCESS PANELS ARE 24" x 24" UNLESS NOTED

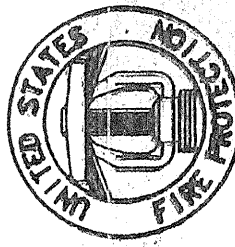
Issue	Issuance / Revisions	Symbol
1991	ISSUED FOR APPROVAL	
1991	ISSUED FOR APPROVAL	



**OUTAGAMIE COUNTY
JUSTICE CENTER**

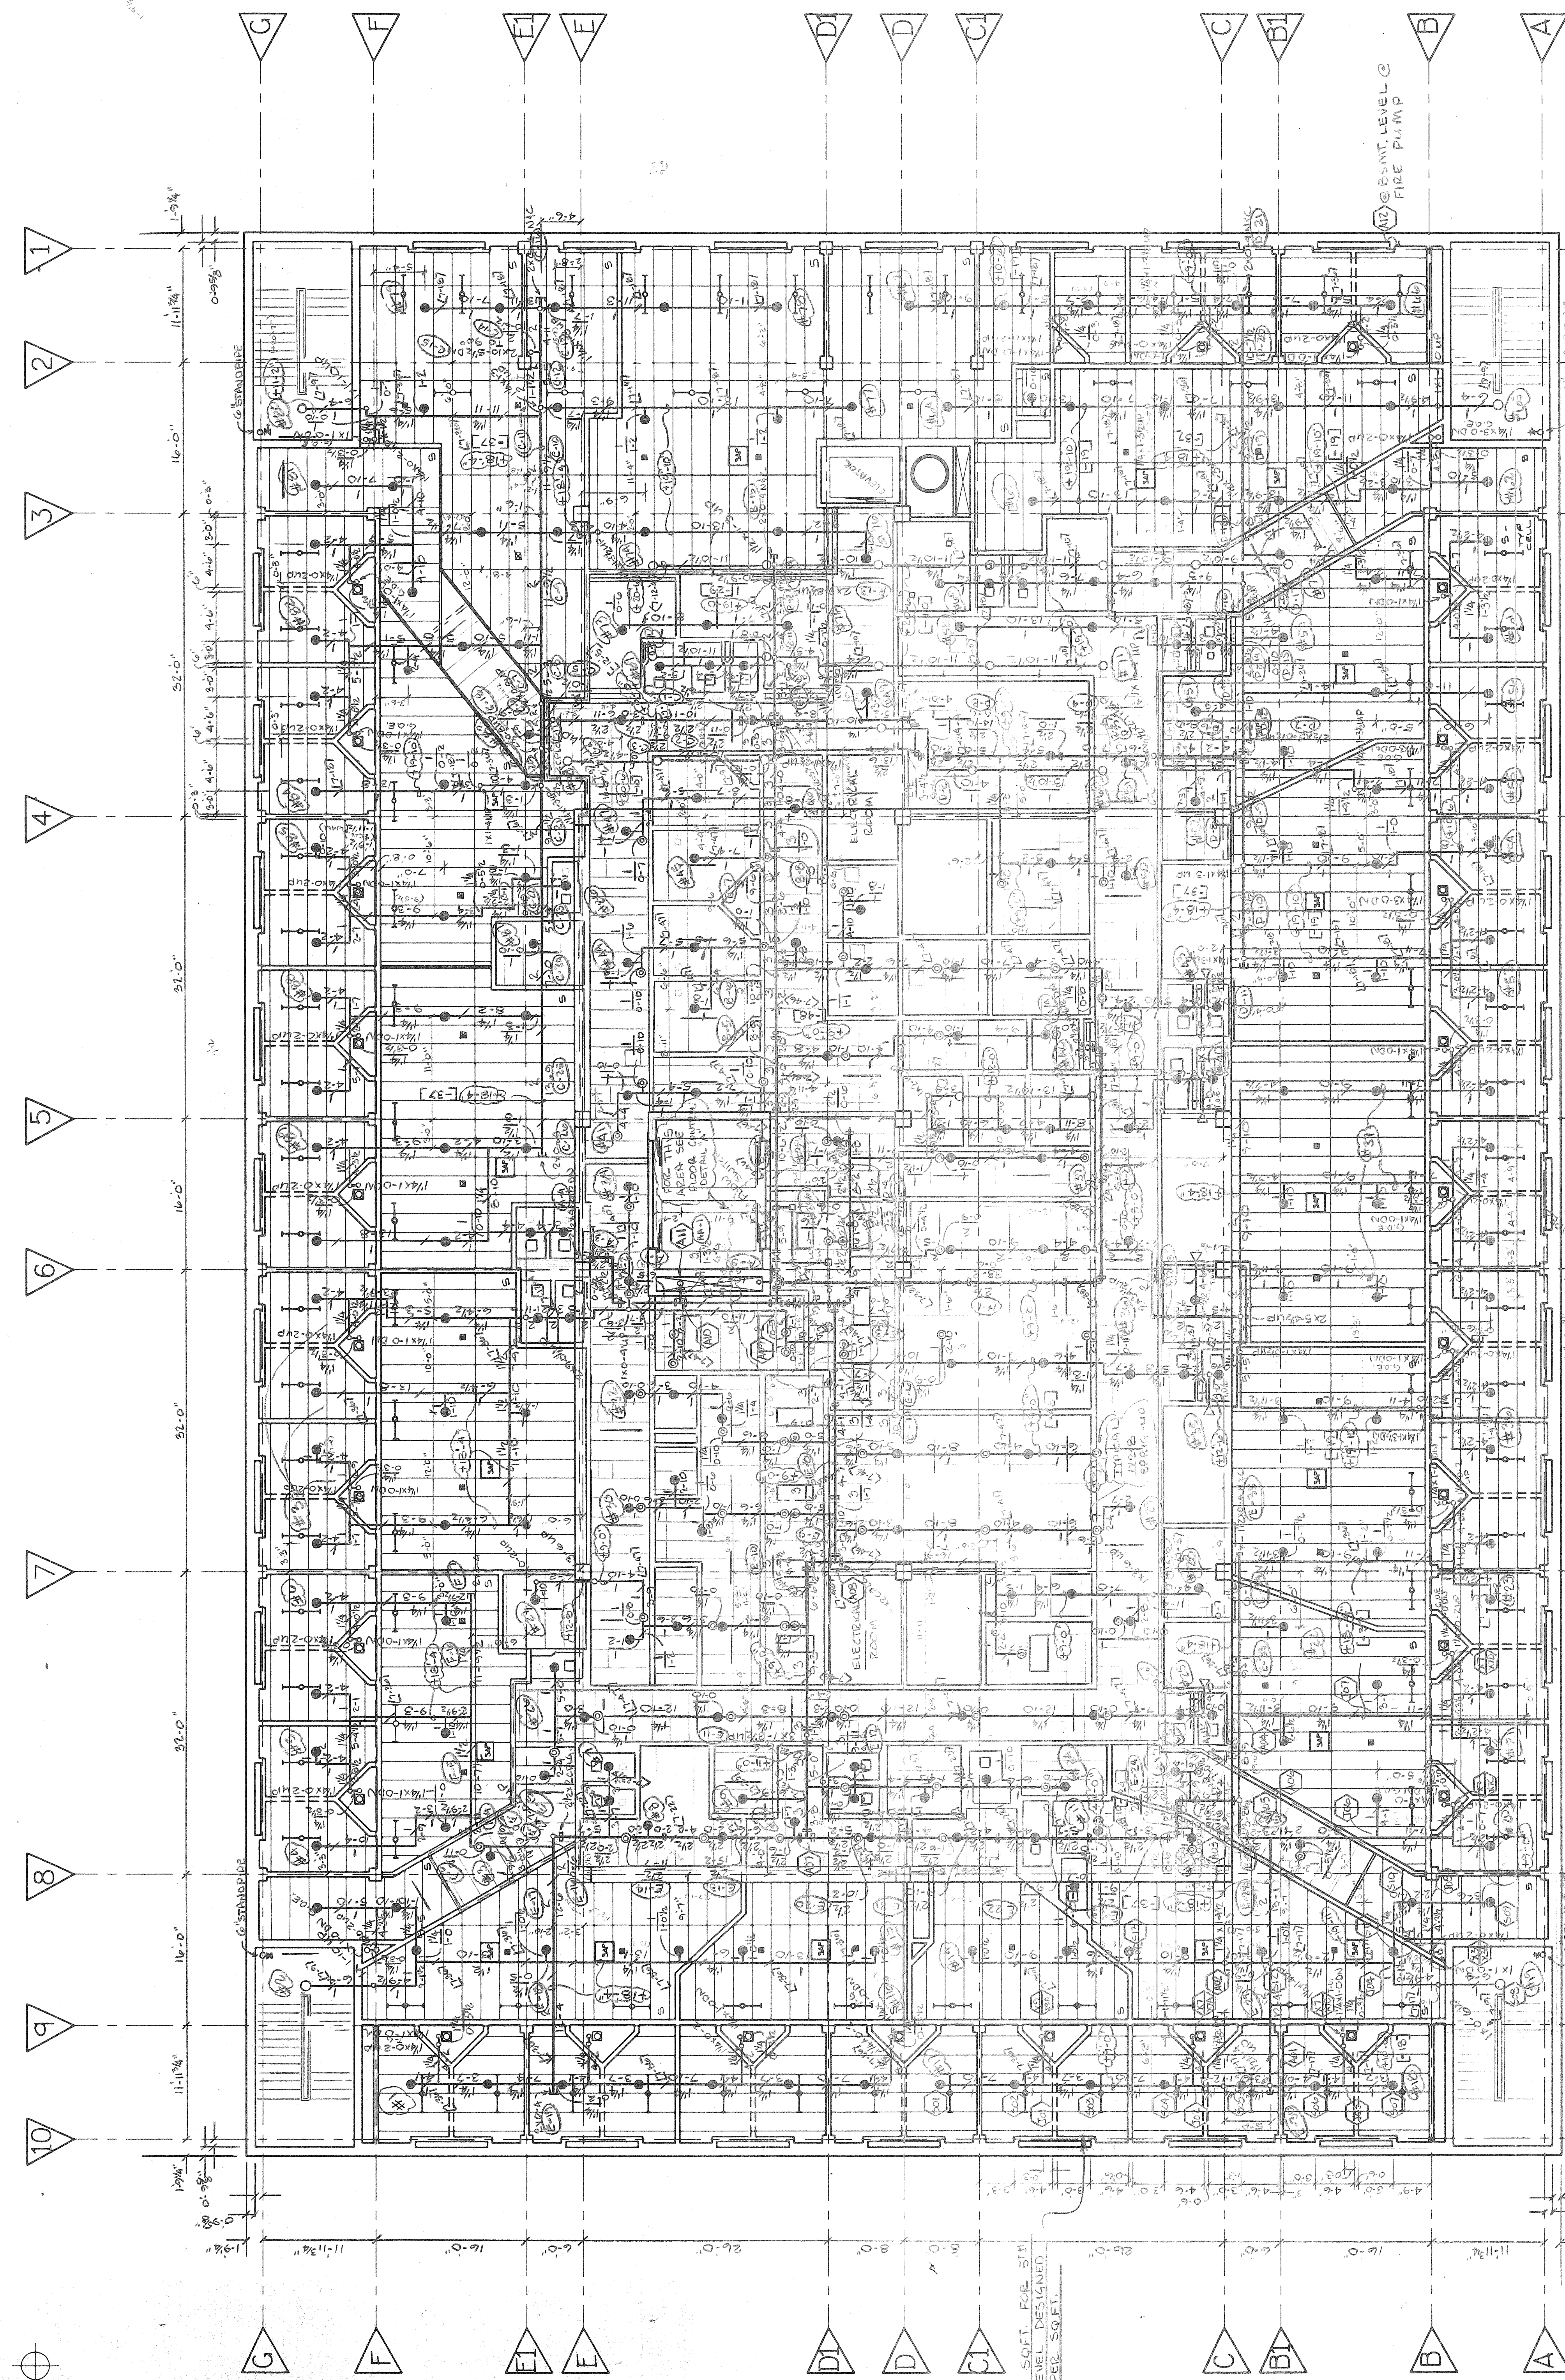
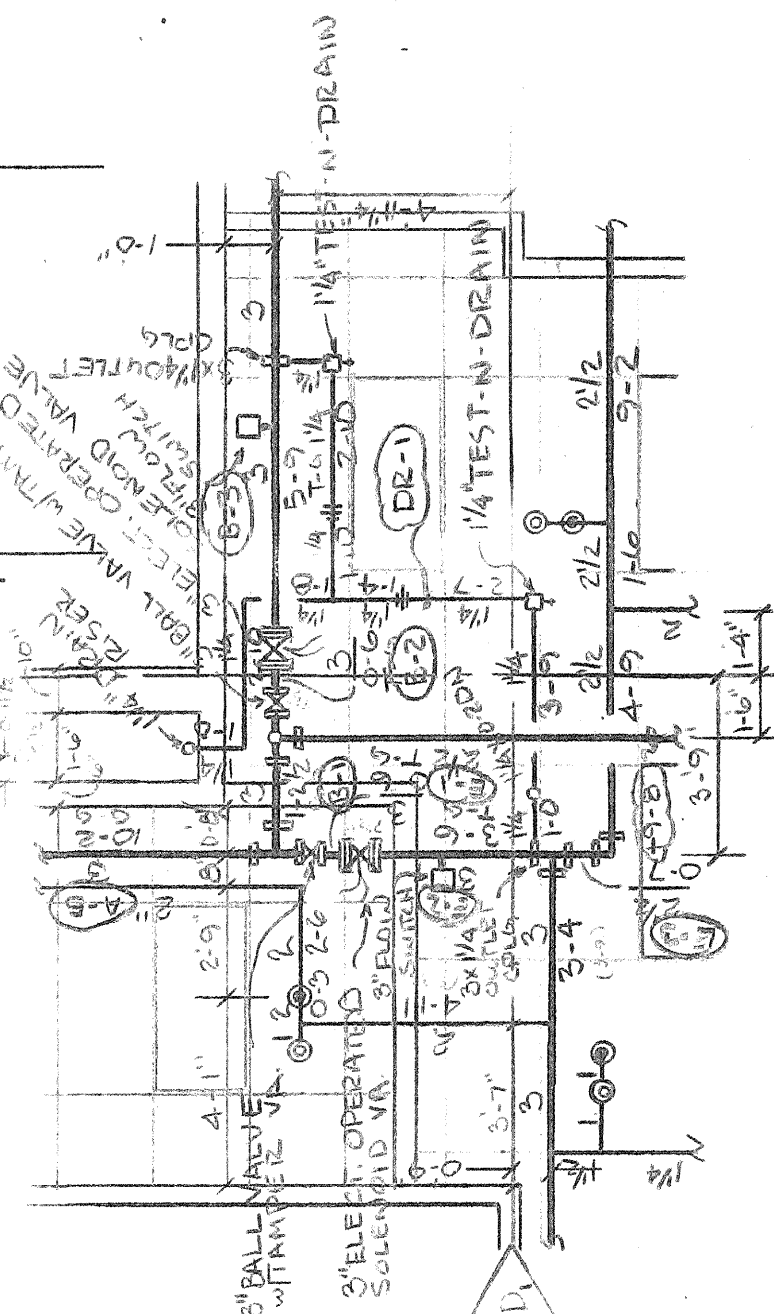
11th Floor Mezz. Automatic Sprinkler Plant	DATE: 8-12-91
11th Floor Mezz. Automatic Sprinkler Plant	DATE: 8-12-91

RECORD DRAWING
Date 11/20/92
United States
Fire Protection

[illegible]

UPPER LEVEL
FIFTH FLR
SCALE: 1/8" = 1'-0"

FLOOR CONTROL DETAIL "A"
SCALE: 1/4" = 1'-0"

[illegible]

ALL HANKERS FOR PIPING AT $+12.4^{\circ}$ TO BE $(7-3/8)^{\circ}$ (40" HANG)
ALL HANKERS FOR PIPING AT $+12.4^{\circ}$ TO BE $(7-3/8)^{\circ}$ (40" HANG)
ALL SPRINGS TO BE 1X2'S UNLESS NOTED
ALL DROPS FOR PIPING AT $+12.4^{\circ}$ TO BE 1X1-DIMENSIONAL
ALL DROPS FOR PIPING AT $+19-10^{\circ}$ (10'6" HANG) TO BE 1X2'S