

Porter Lawson
ARCHITECTS

15 BILLS POLE COURT
MADISON, WISCONSIN
608 274 2471

MW

Meyer Associates Incorporated
2000 UNIVERSITY AVENUE
CHICAGO, ILLINOIS 60602 312/685-1234

ARCHITECTS
AND
ASSOCIATES

135 EAST COLLEGE AVENUE
SUITE 200
APPLETON, WISCONSIN 54911
414/750-0855

ARNOLD & BERGERMAN, INC.
CONSULTING ENGINEERS

1000 UNIVERSITY AVENUE
MADISON, WISCONSIN 53706
608/277-8881

See & Notes

REFLECTED CEILING PLAN KEY

□

RECESSED
FLUORESCENT FIXTURE

□

RECESSED
FLUORESCENT FIXTURE

□

RECESSED
FLUORESCENT FIXTURE

□

RECESSED CAN
FIXTURE

○

SURFACE MOUNTED
CAN FIXTURE

○

SURFACE MOUNTED
OR SUSPENDED
FLUORESCENT FIXTURE

○

SURFACE MOUNTED
FLUORESCENT FIXTURE

○

SURFACE MOUNTED
FLUORESCENT FIXTURE

—

LINEAR DEFUSER

□

TRIMMED GRIFF
(SIZE VARIES)

□

NON-SECURITY
ACCESS PANEL
(SIZE VARIES)

□

SECURITY
ACCESS PANEL
(SIZE VARIES)

□

2'X2' SUSPENDED
CEILING

□

2'X4' SUSPENDED
CEILING

□

SECURITY CEILING

□

PLASTER CEILING

□


0'X0' CEILING

Date	Issued / Revisions	Symbol
0-29-00	FINISHED FOR FABRICATION	
0-1-00	ISSUED FOR APPROVAL	


APPLETON, WISCONSIN

OUTAGAMIE COUNTY
JUSTICE CENTER

Drawing Title	SECOND FLOOR AUTOMATIC SPRINKLER PLAN
Project No.	1544
Review Agency	I.S.O.W.
Date	10-1-90
Drawn By	OLSON
Drawing No.	FP-2

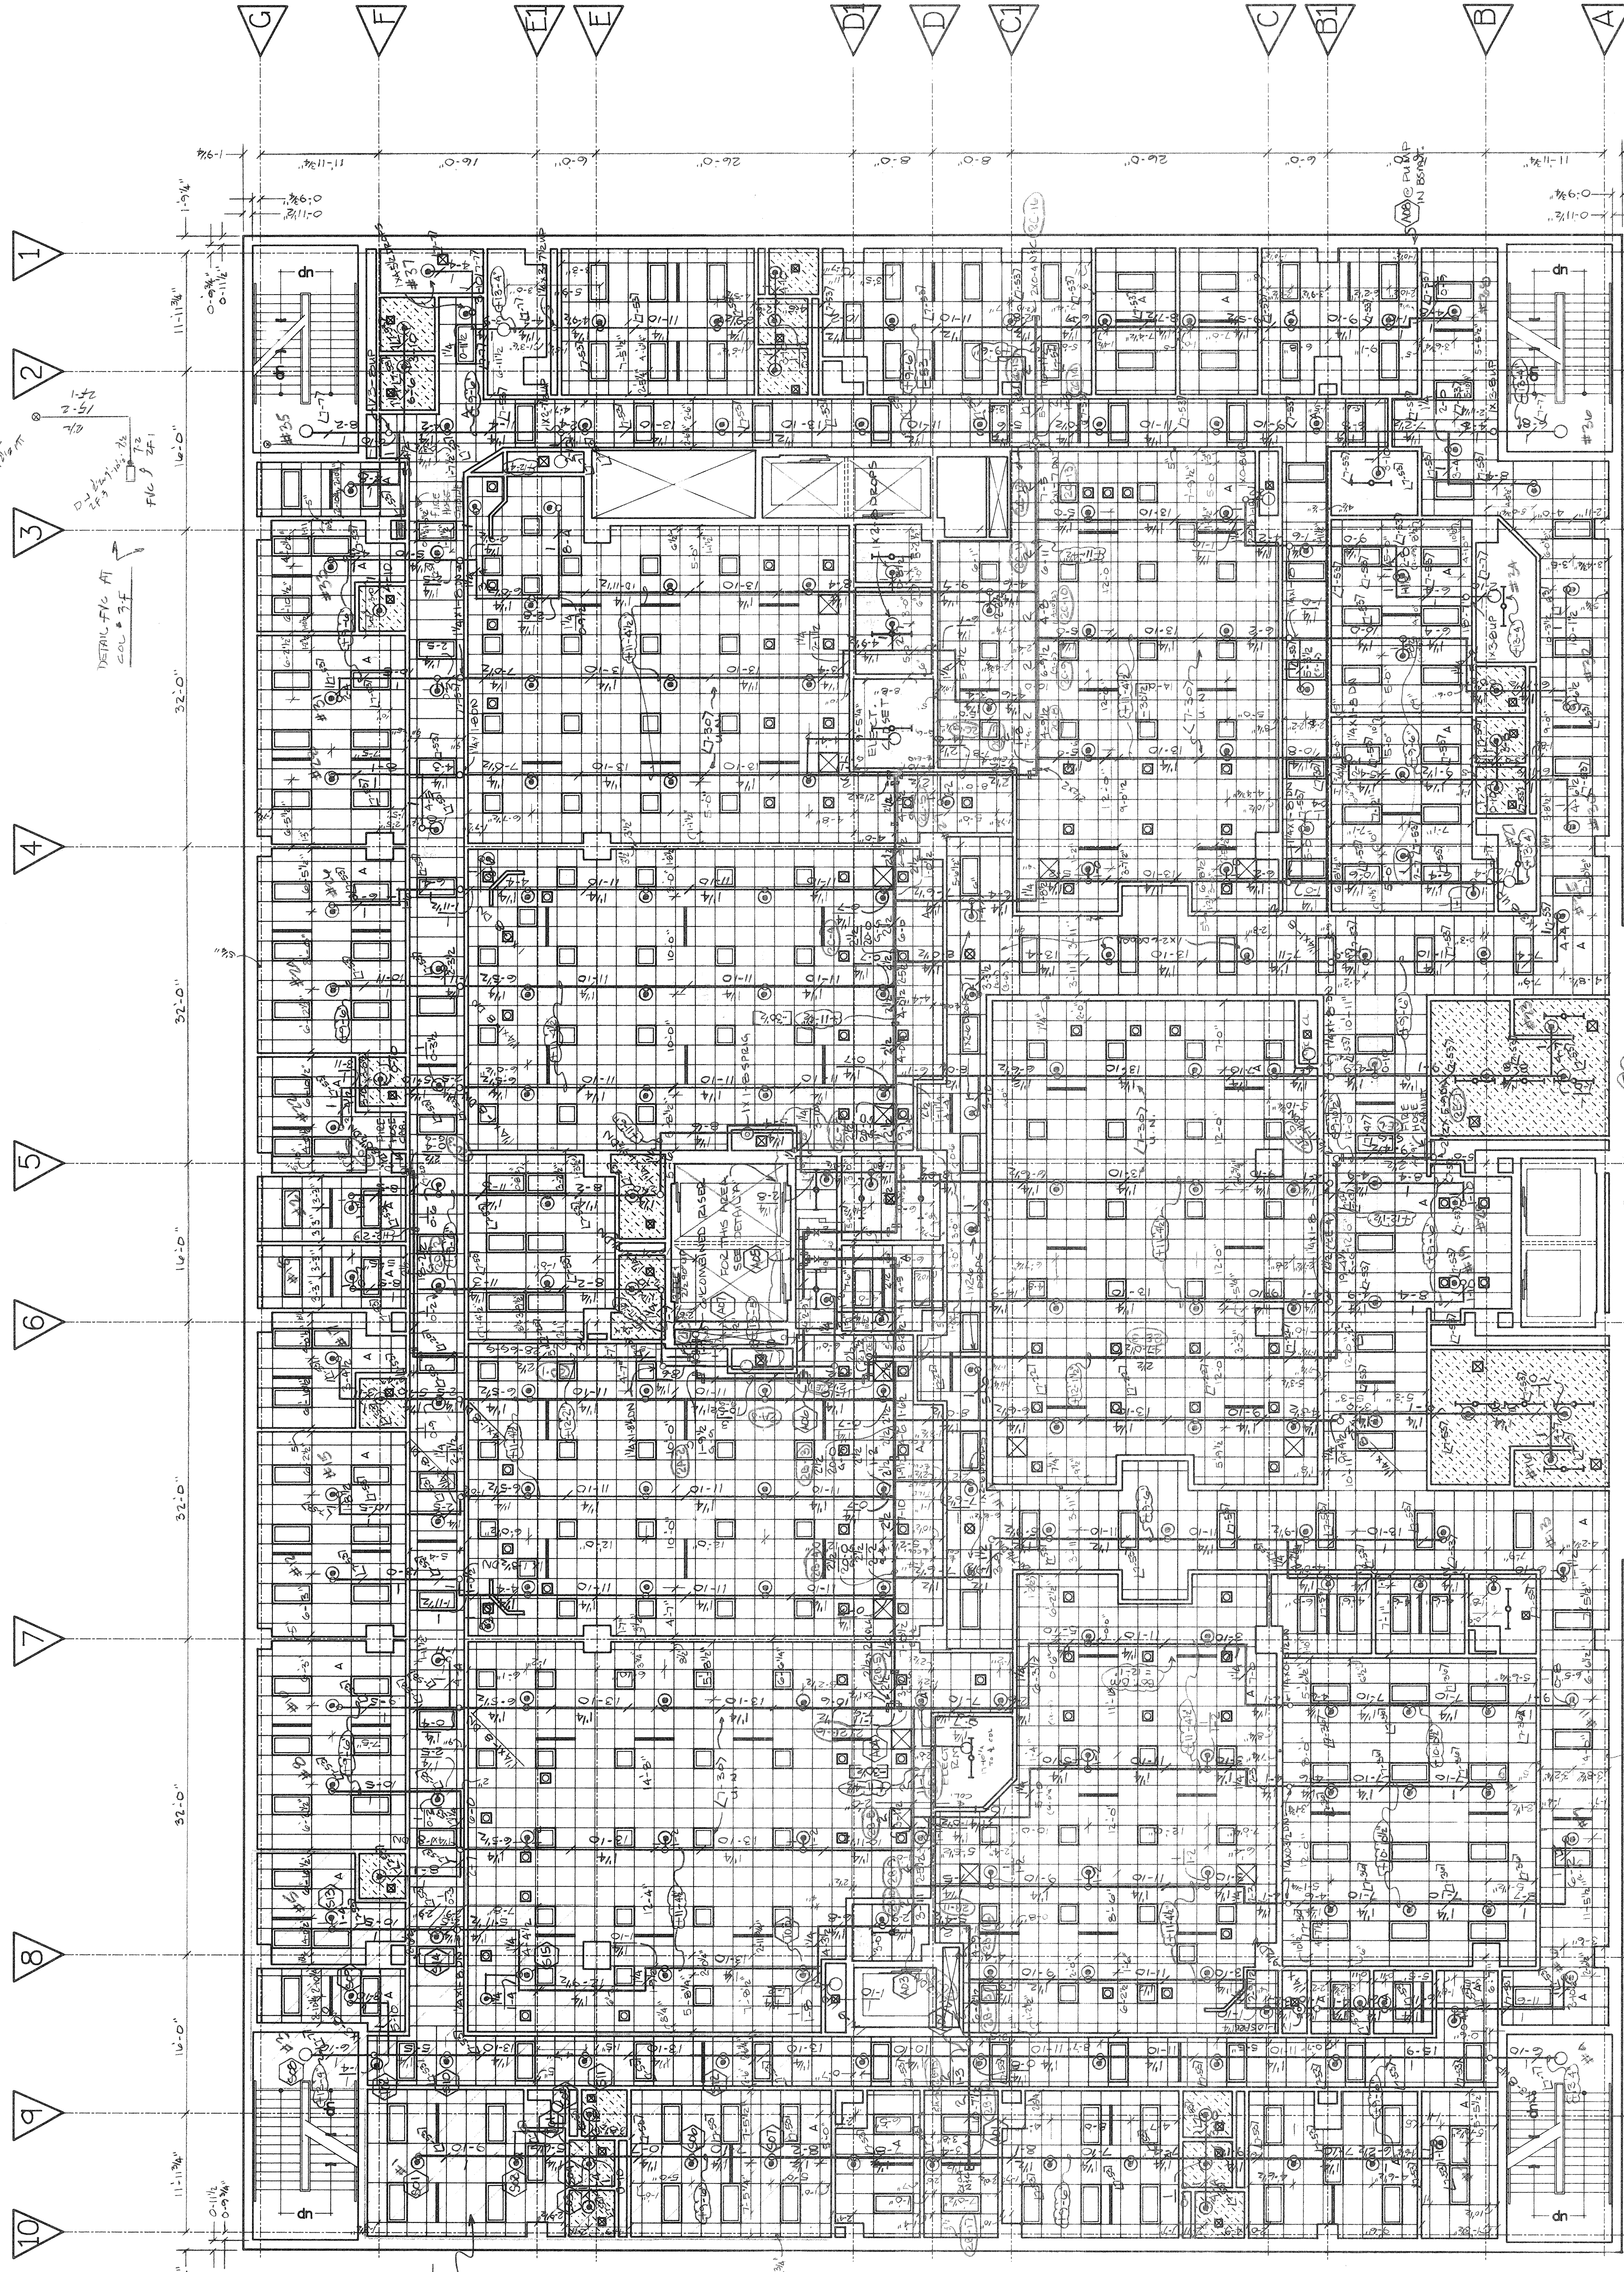

FOR NOTES SEE DRAWING FP-2
ALL HANGERS 2'-30" UNLESS NOTED
ALL DROPS 1'-0" 1/2 RED. C.L.G. FOR 2'-0" 1/2 PIPING
ALL DEEPS 1'-0" 1/2 RED. C.L.G. FOR 2'-0" 1/2 PIPING

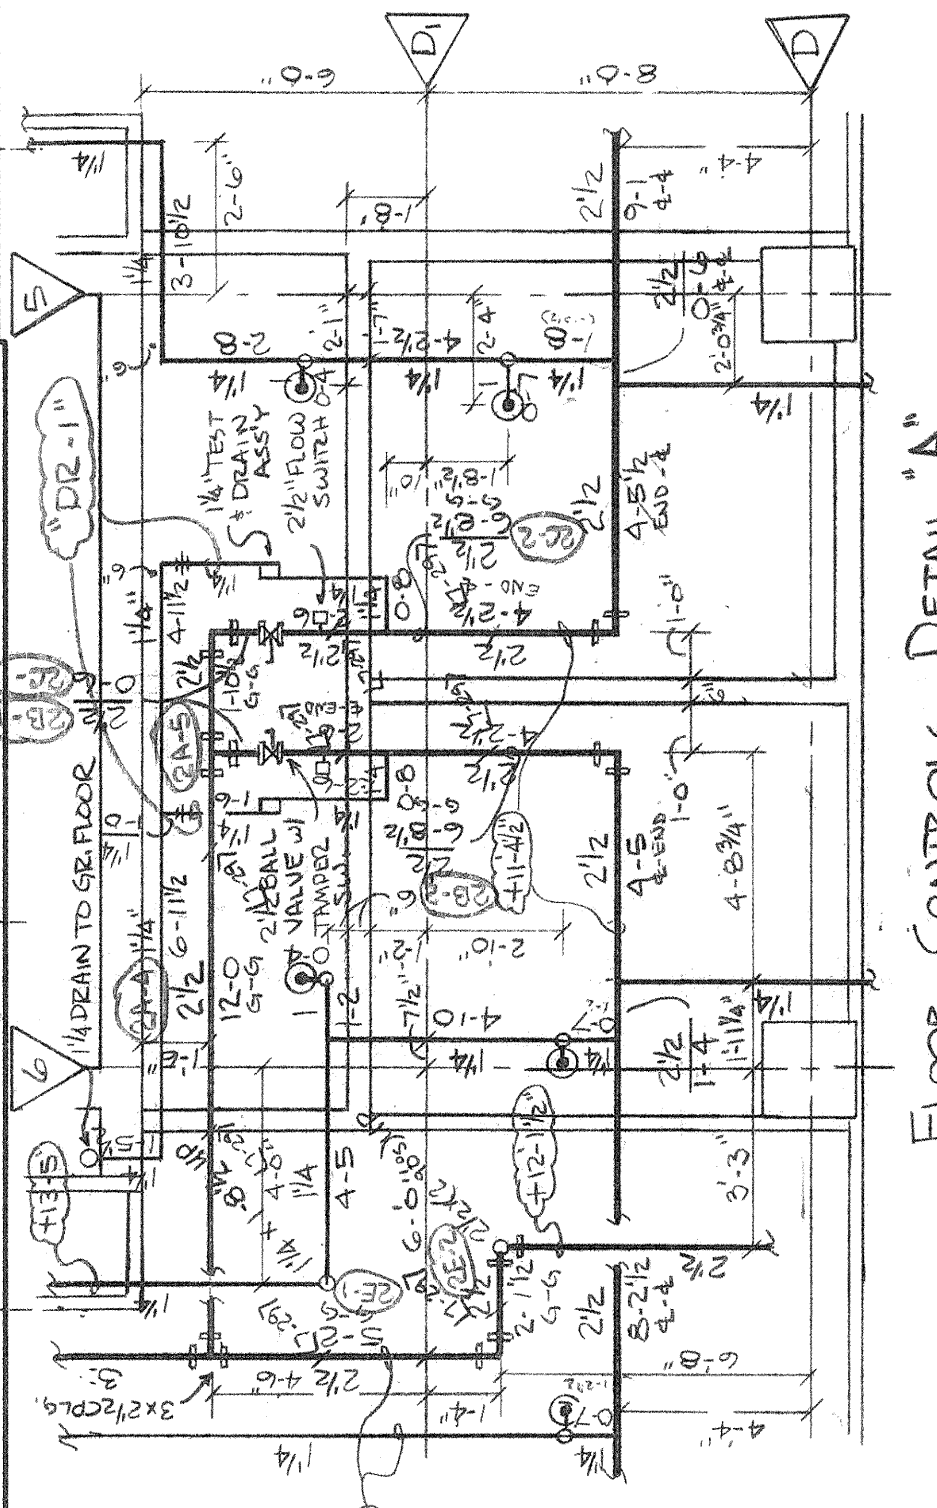

RECORD DRAWING
Date 11/20/92
United States
Fire Protection

OWNER	UNITED STATES FIRE PROTECTION
DESIGNER	UNITED STATES FIRE PROTECTION
DATE	11/20/92
SCALE	1/8" = 1'-0"

SECOND FLOOR PLAN
SCALE 1/8" = 1'-0"



FLOOR CONTROLS DETAIL "A"
SCALE: 1/4" = 1'-0"

2ND FLOOR NORTH REMOTE 1500 GPM
PUMP DESIGNED FOR 10 GPM PER
SQ. FT. LIGHT HAZARD
TYPICAL TO NORTH