


SEE SHEET C102
TO COORDINATE
SITE DEMOLITION

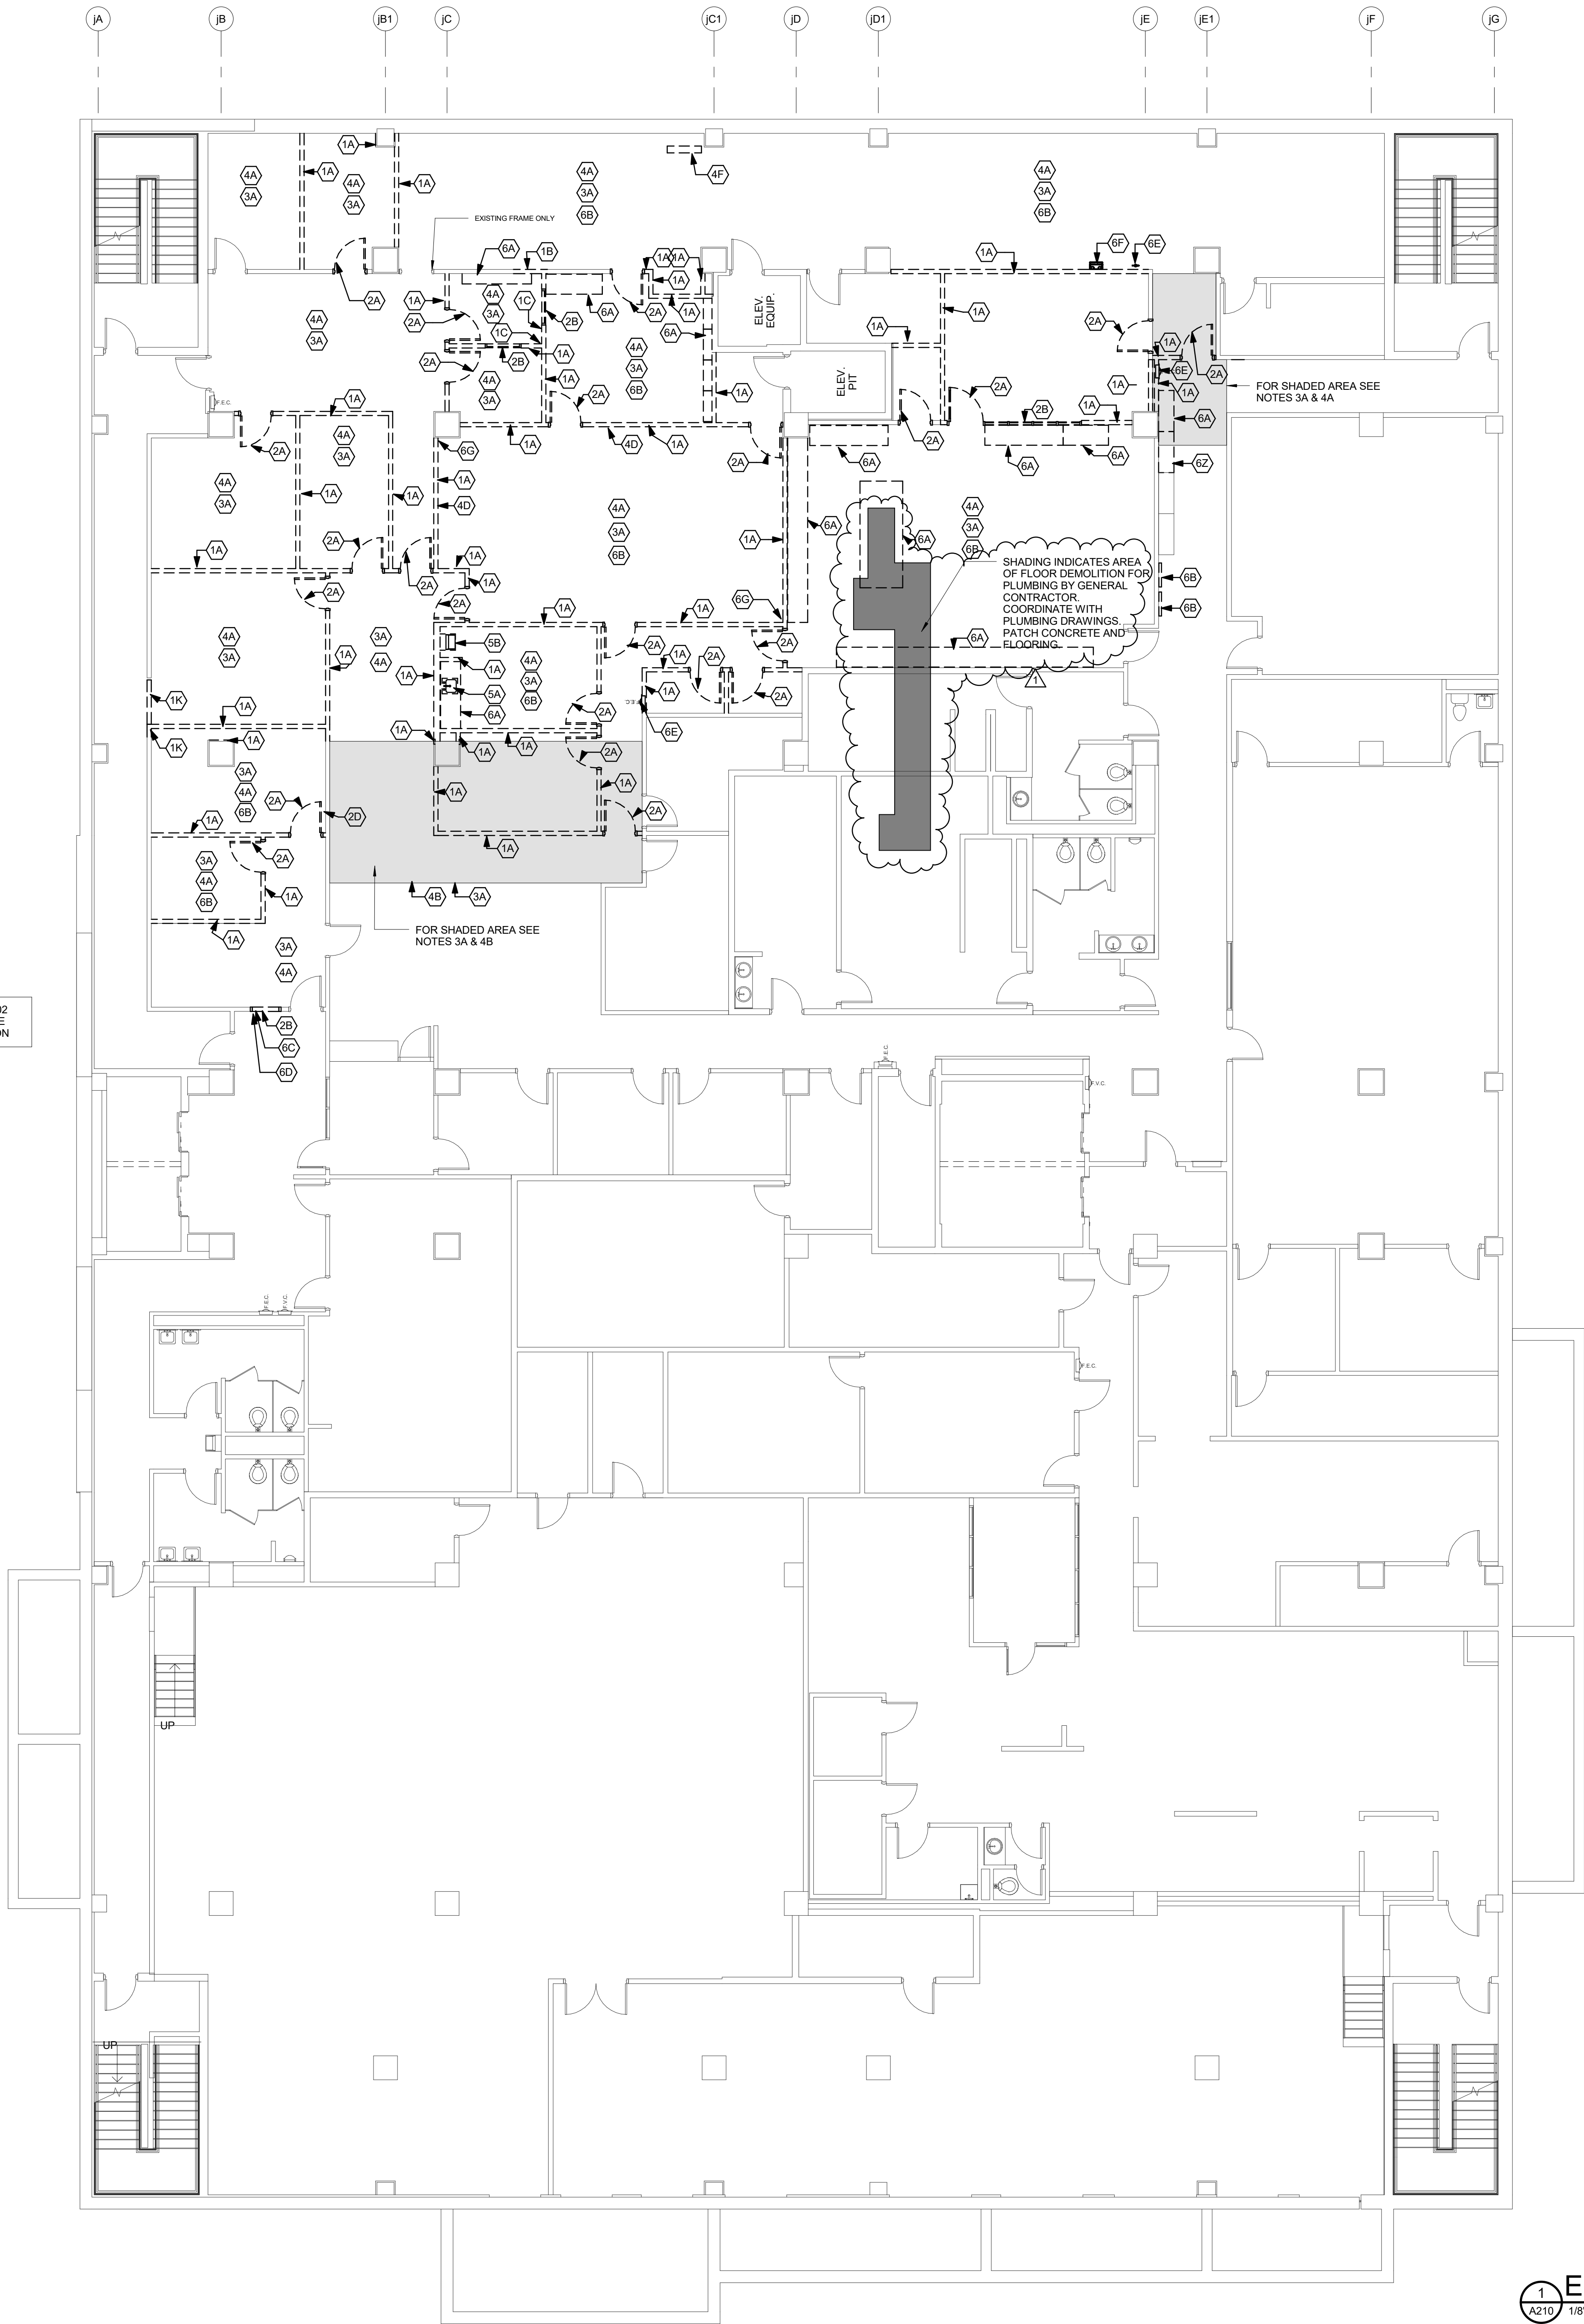


1 A210 ENLARGED DEMOLITION PLAN 1/8" = 1'-0"



GENERAL DEMOLITION NOTES

- EXISTING BUILDING HAS BEEN SHOWN ACCORDING TO ORIGINAL BUILDING PLANS. FIELD NOTES AND MEASUREMENTS. EXISTING CONDITIONS AND DIMENSIONS SHALL BE FIELD VERIFIED BY CONTRACTORS AND DISCREPANCIES REPORTED TO THE ARCHITECT.
- DASHED LINES INDICATE EXISTING WALLS, DOORS, WINDOWS, CABINETS & FIXTURES TO BE REMOVED.
- EXISTING WALLS, PARTITIONS, FLOOR LINES, DOORS AND FRAMES THAT REMAIN ARE SHOWN IN CONTINUOUS LINE WEIGHT. THESE AND EXISTING FLOOR AND WALL FINISHES THAT ARE SCHEDULED TO REMAIN SHALL BE PROTECTED FROM DAMAGE DURING DEMOLITION AND CONSTRUCTION.
- WHERE WALLS OR PARTITIONS ARE INDICATED TO BE REMOVED, REMOVE ENTIRE WALL OR PARTITIONS AS WELL AS DUCTS, PIPING, CONDUITS AND OTHER ELEMENTS IN OR ON THEM WHICH MAY OR MAY NOT BE SPECIFICALLY IDENTIFIED, UNLESS OTHERWISE NOTED. PATCH EXISTING ADJACENT CONSTRUCTION THAT IS TO REMAIN WHERE APPLICABLE.
- THE OWNER SHALL HAVE FIRST RIGHT OF REFUSAL ON ALL DOORS, HARDWARE, FIXTURES AND EQUIPMENT BEING REMOVED DURING DEMOLITION. COORDINATE WITH OWNER ALL EQUIPMENT TO BE SALVAGED AND/OR REUSED ON THE PROJECT.
- EXISTING FINISHES TO BE REMOVED SHALL HAVE THE ORIGINAL SUBSTRATE PREPARED TO RECEIVE NEW FINISHES.
- MAINTAIN AND PROTECT EXISTING UTILITY SERVICES TO REMAIN AND/OR TO BE OPERATIONAL DURING DEMOLITION AND CONSTRUCTION.
- ALL FIELD VERIFICATION FOR PLUMBING, MECHANICAL & ELECTRICAL DEMOLITION IS THE CONTRACTORS RESPONSIBILITY.
- SCOPE OF DEMOLITION AND REMOVAL WORK SHALL NOT BE LIMITED BY THESE DRAWINGS BUT SHALL INCLUDE ANY AND ALL WORK NECESSARY TO FACILITATE NEW CONSTRUCTION.
- CONTRACTOR TO PROTECT AREAS ADJACENT TO DEMOLITION DURING CONSTRUCTION.
- PROVIDE DUST CONTROL BETWEEN CONSTRUCTION AREAS AND OCCUPIED AREAS AT ALL TIMES.
- DEMOLITION WORK PERFORMED THAT IS NOT REQUIRED FOR NEW CONSTRUCTION IS TO BE PLACED AT NO CHARGE TO THE OWNER.
- ALL SHUTDOWNS OF MECHANICAL, SPRINKLER, FIRE ALARM AND/OR ELECTRICAL SYSTEMS TO BE COORDINATED WITH OWNER.
- CONTRACTOR TO COORDINATE DEMOLITION WORK WITH NEW CONSTRUCTION AS SHOWN ON DRAWINGS. REPORT ANY CONFLICTS TO THE ARCHITECT BEFORE DEMOLITION WORK BEGINS.
- SEQUENCE OF DEMOLITION WORK TO BE COORDINATED WITH NEW CONSTRUCTION.
- SEE OTHER DISCIPLINES' DRAWINGS FOR EXTENT OF ITEMS TO BE REMOVED AND SALVAGED FOR RE-USE.
- ALL "CUTTING AND PATCHING" IS THE RESPONSIBILITY OF THE GENERAL CONTRACTOR FOR WORK REQUIRED FOR ALL TRADES WHETHER INDICATED ON THE DRAWINGS OR NOT.
- SITE CLEAR ANY EXISTING FURRING ON COLUMNS WITHIN SCOPE OF PROJECT.
- REMOVE ALL SIGNAGE WITHIN SCOPE OF WORK AND TURNOVER TO OWNER.

DEMOLITION LEGEND:

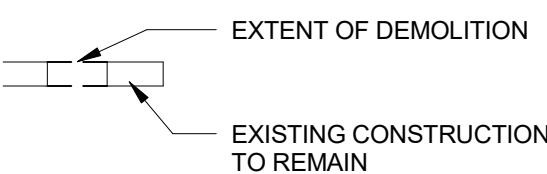

X DEMOLITION NOTES

WALLS

- 1A SITE CLEAR EXISTING WALL AND BASE AS REQUIRED FOR NEW CONSTRUCTION.
- 1B SITE CLEAR EXISTING WALL AS REQUIRED FOR NEW DOOR OPENING.
- 1C REMOVE EXISTING WALL COVERING AND TURN OVER TO OWNER.
- 1K SITE CLEAR EXISTING WALL AS REQUIRED FOR NEW OPENING.

DOOR & WINDOW

- 2A SITE CLEAR EXISTING DOOR, HARDWARE, AND FRAME. PATCH WALLS AS REQUIRED FOR NEW CONSTRUCTION.
- 2B SITE CLEAR EXISTING BORROWED LITE.
- 2D REMOVE EXISTING DOORSTOP AND PATCH AS REQUIRED FOR NEW CONSTRUCTION.

FLOORS

- 3A SITE CLEAR EXISTING FLOORING & BASE AS REQUIRED FOR NEW CONSTRUCTION.

ROOF & CEILING



- 4A SITE CLEAR EXISTING CEILING TILE AND GRID.
- 4B EXISTING SUSPENDED ACOUSTICAL CEILING TILE SYSTEM TO BE REMOVED, STORED, AND PROTECTED FOR RE-USE.
- 4D REMOVE EXISTING OVERHEAD SCREEN AND TURN OVER TO OWNER.
- 4F REMOVE EXISTING CEILING MOUNTED EQUIPMENT AND TURN OVER TO OWNER.

PLUMBING

- 5A SITE CLEAR EXISTING SINK. SEE PLUMBING DRAWINGS.
- 5B SITE CLEAR EXISTING DRINKING FOUNTAIN. SEE PLUMBING DRAWINGS.

MISC.

- 6A SITE CLEAR EXISTING CASEWORK.
- 6B REMOVE EXISTING BULLETIN BOARDS/WHITEBOARDS AND TURN OVER TO OWNER.
- 6C REMOVE EXISTING TRANSACTION COUNTER. PATCH AND PREP WALL AS REQUIRED FOR NEW WORK.
- 6D REMOVE EXISTING WINDOW TREATMENT AND TURN OVER TO THE OWNER.
- 6E REMOVE EXISTING FIRE EXTINGUISHER AND CABINET WHERE EXIST. STORE AND PROTECT MATERIALS FOR RE-USE. PATCH AND PREP WALL AS REQUIRED FOR NEW CONSTRUCTION.
- 6F REMOVE EXISTING SHARPS CONTAINER AND TURN OVER TO OWNER.
- 6G REMOVE EXISTING WALL MOUNTED TELEVISION AND TURN OVER TO OWNER.
- 6Z REMOVE EXISTING CASEWORK AND BASE. RELOCATE AT OTHER END OF EXISTING CASEWORK IN THIS CORRIDOR.

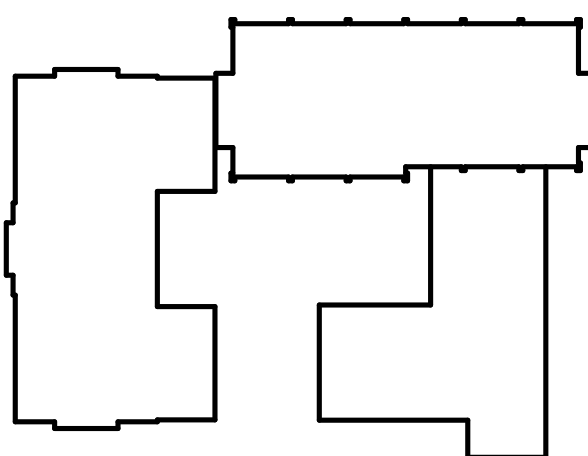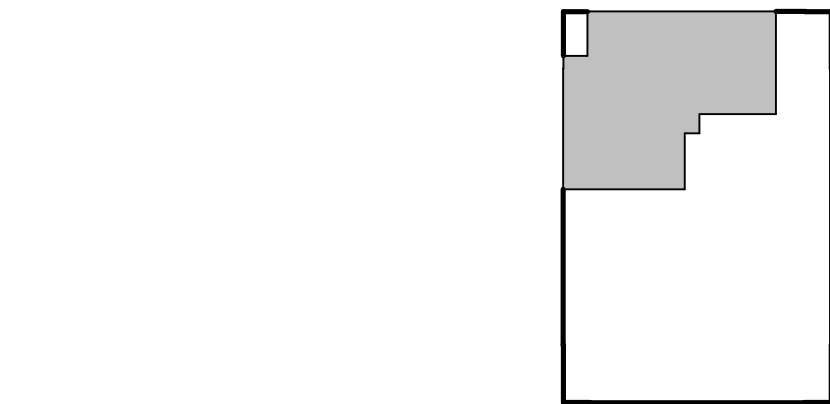


PLAN KEY
NOT TO SCALE




NO.	DATE	REVISION
1	3/30/2017	ADDENDUM 1

DESIGNED MAG	DRAWN BLG
PROJECT NO. 00002-61600160	
DATE MARCH 3, 2017	
SHEET NO.	

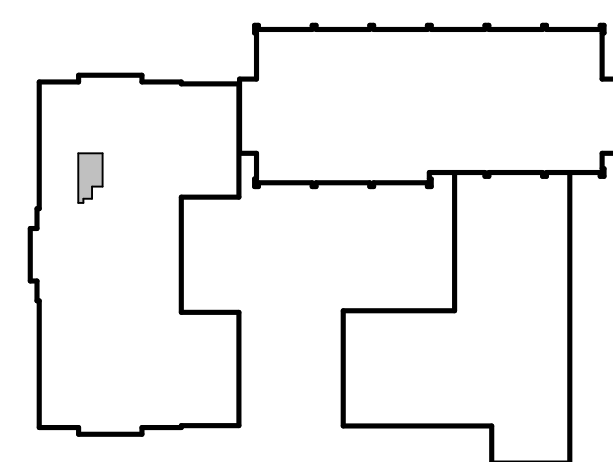

PLAN KEY

NOT TO SCALE

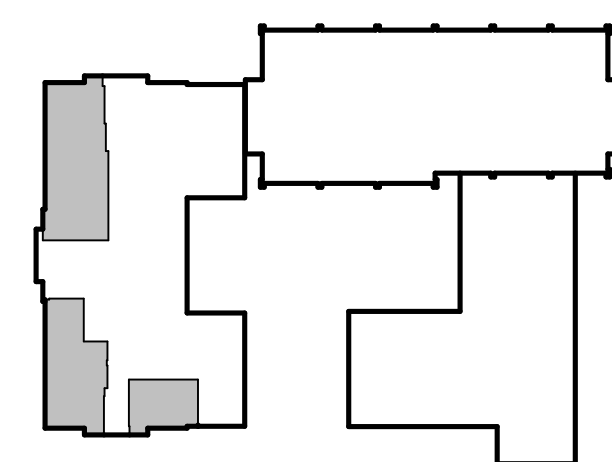


PLAN KEY
NOT TO SCALE


6A	SITE CLEAR EXISTING CASEWORK.
6B	REMOVE EXISTING BULLETIN BOARDS/SWITCHBOARDS AND TURN OVER TO OWNER.
6C	REMOVE EXISTING WINDOW TREATMENT AND TURN OVER TO THE OWNER.
6D	REMOVE EXISTING WALL MOUNTED TELEVISION AND TURN OVER TO OWNER.
6E	REMOVE EXISTING PAPER TOWEL DISPENSER AND TURNOVER TO OWNER.
6F	REMOVE EXISTING WALL MOUNTED EQUIPMENT AND TURN OVER TO OWNER.
6G	REMOVE EXISTING SOAP DISPENSER AND TURN OVER TO OWNER. CONTRACTOR TO COORDINATE THE RELOCATION OF EXISTING SINK WITH OWNER.
6H	REMOVE EXISTING HIGH DENSITY SHELVING SYSTEM AND TURN OVER TO OWNER.
6I	REMOVE EXISTING APPLIANCE AND TURN OVER TO OWNER.
6J	SITE CLEAR EXISTING PLASTIC LAMINATE TRANSACTION COUNTER. TEMPORARILY RELOCATE STAINLESS STEEL FURNITURE PRIOR TO CONSTRUCTION.

DESIGNED MAG	DRAWN BLG
PROJECT NO. O0002-61600160	
DATE MARCH 3, 2017	
SHEET NO.	

A212

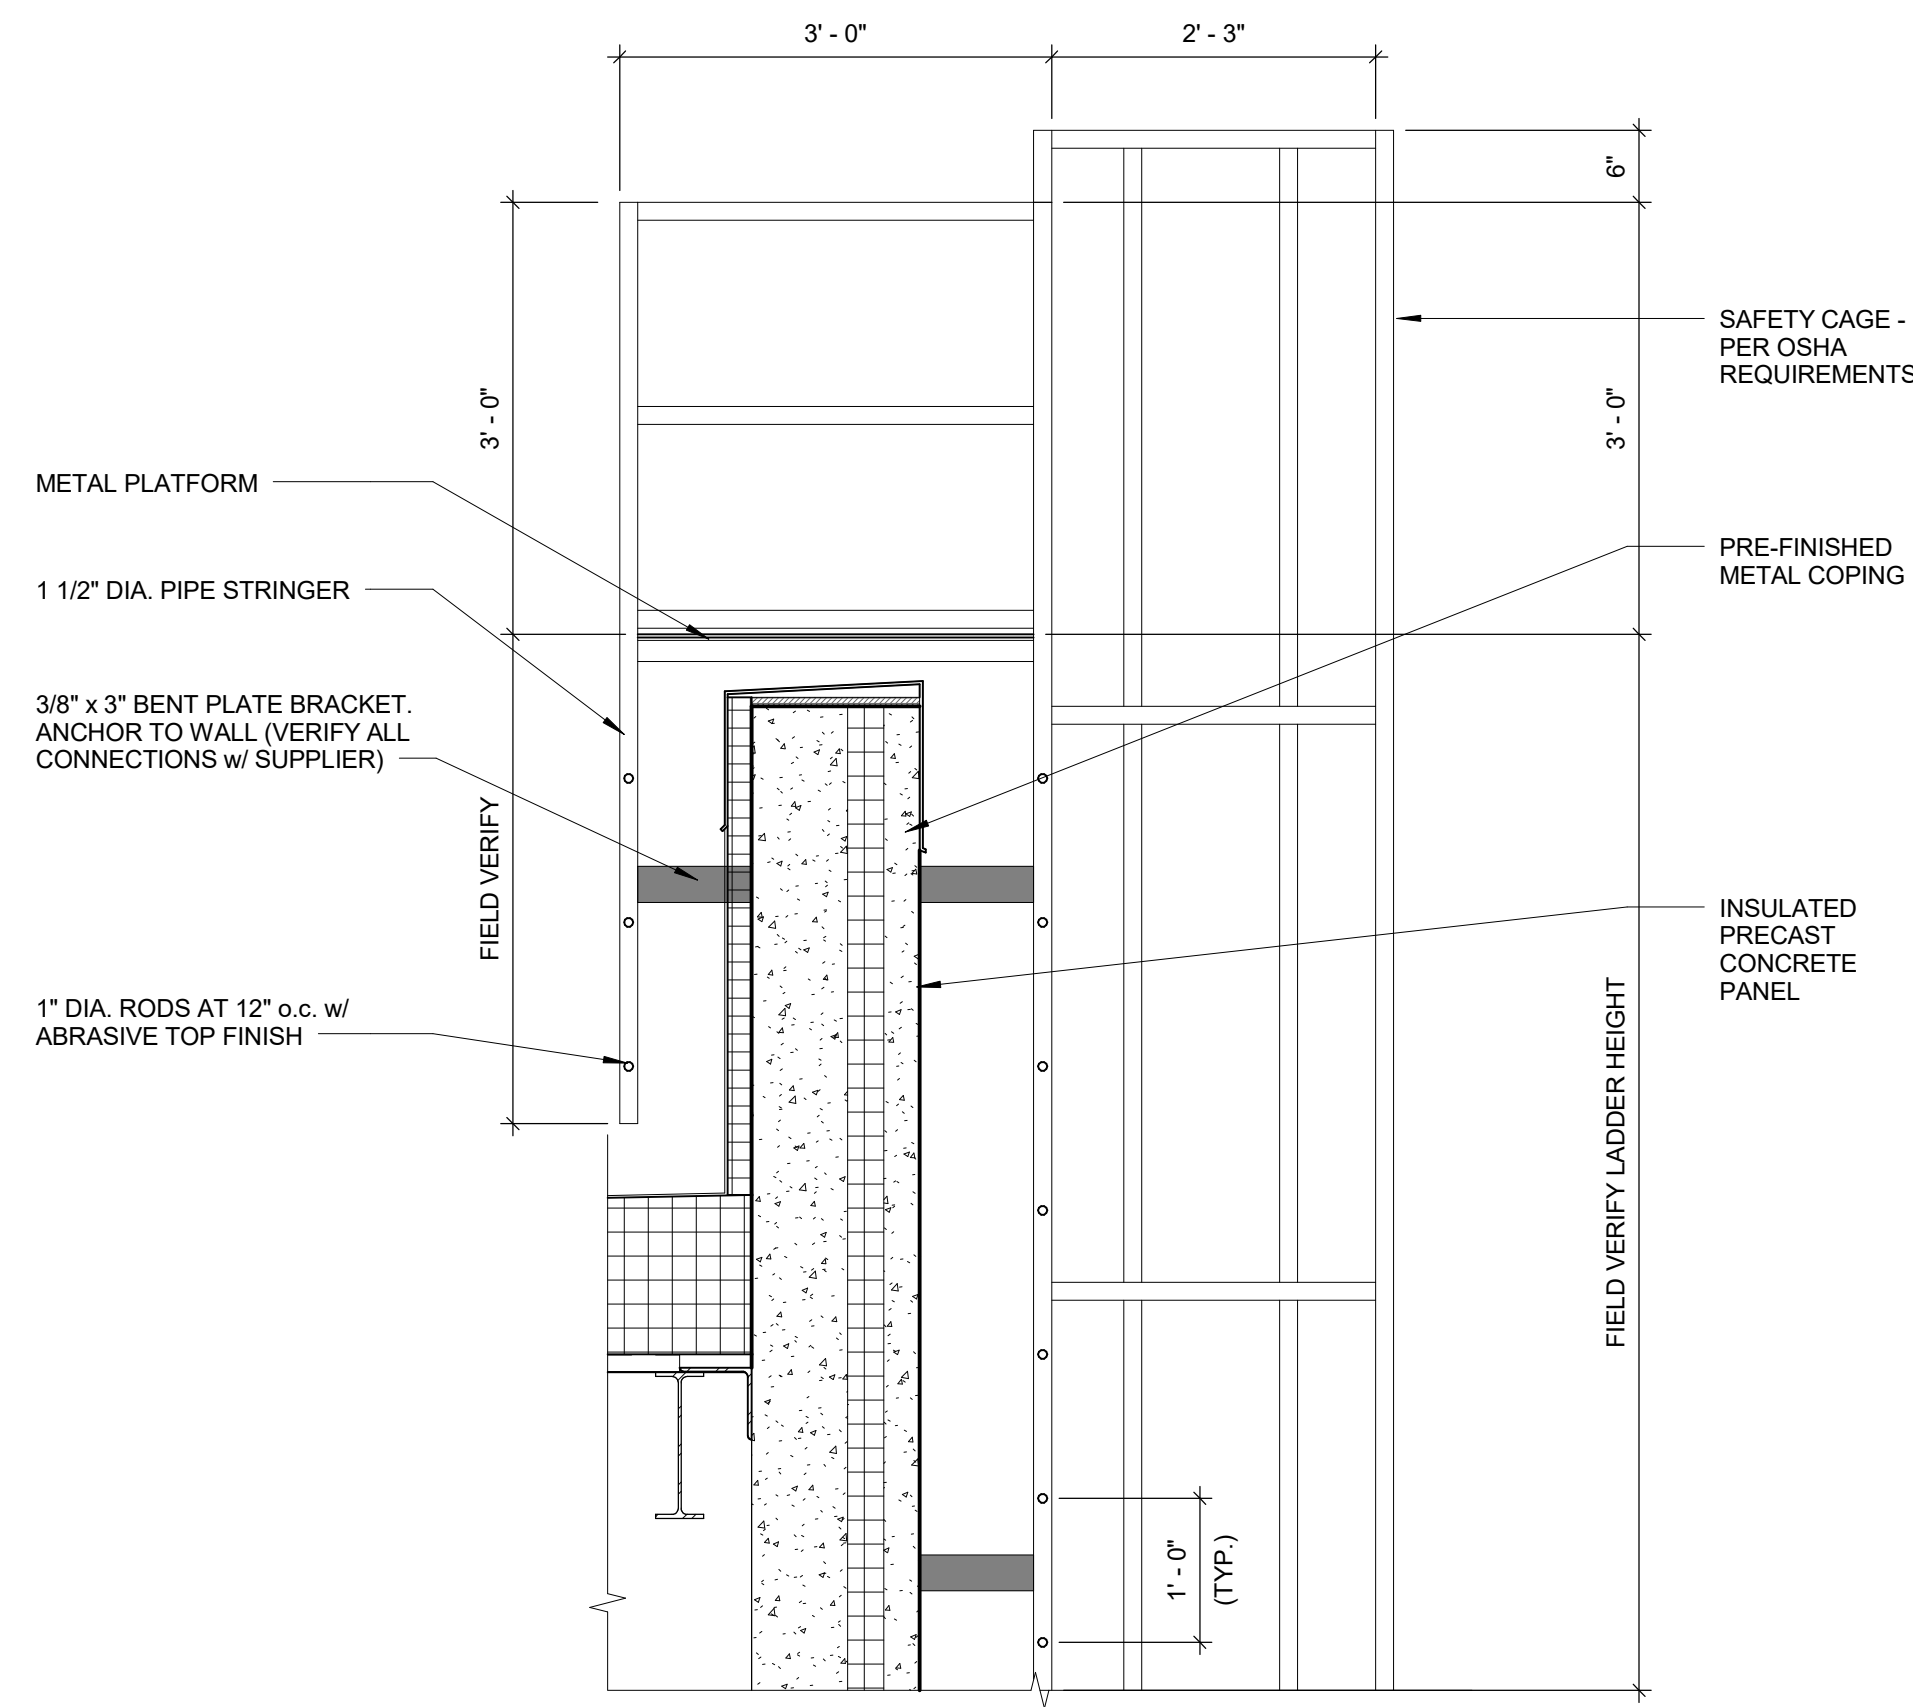


3 ROOF ACCESS LADDER DETAIL
A226 3/4" = 1'-0"

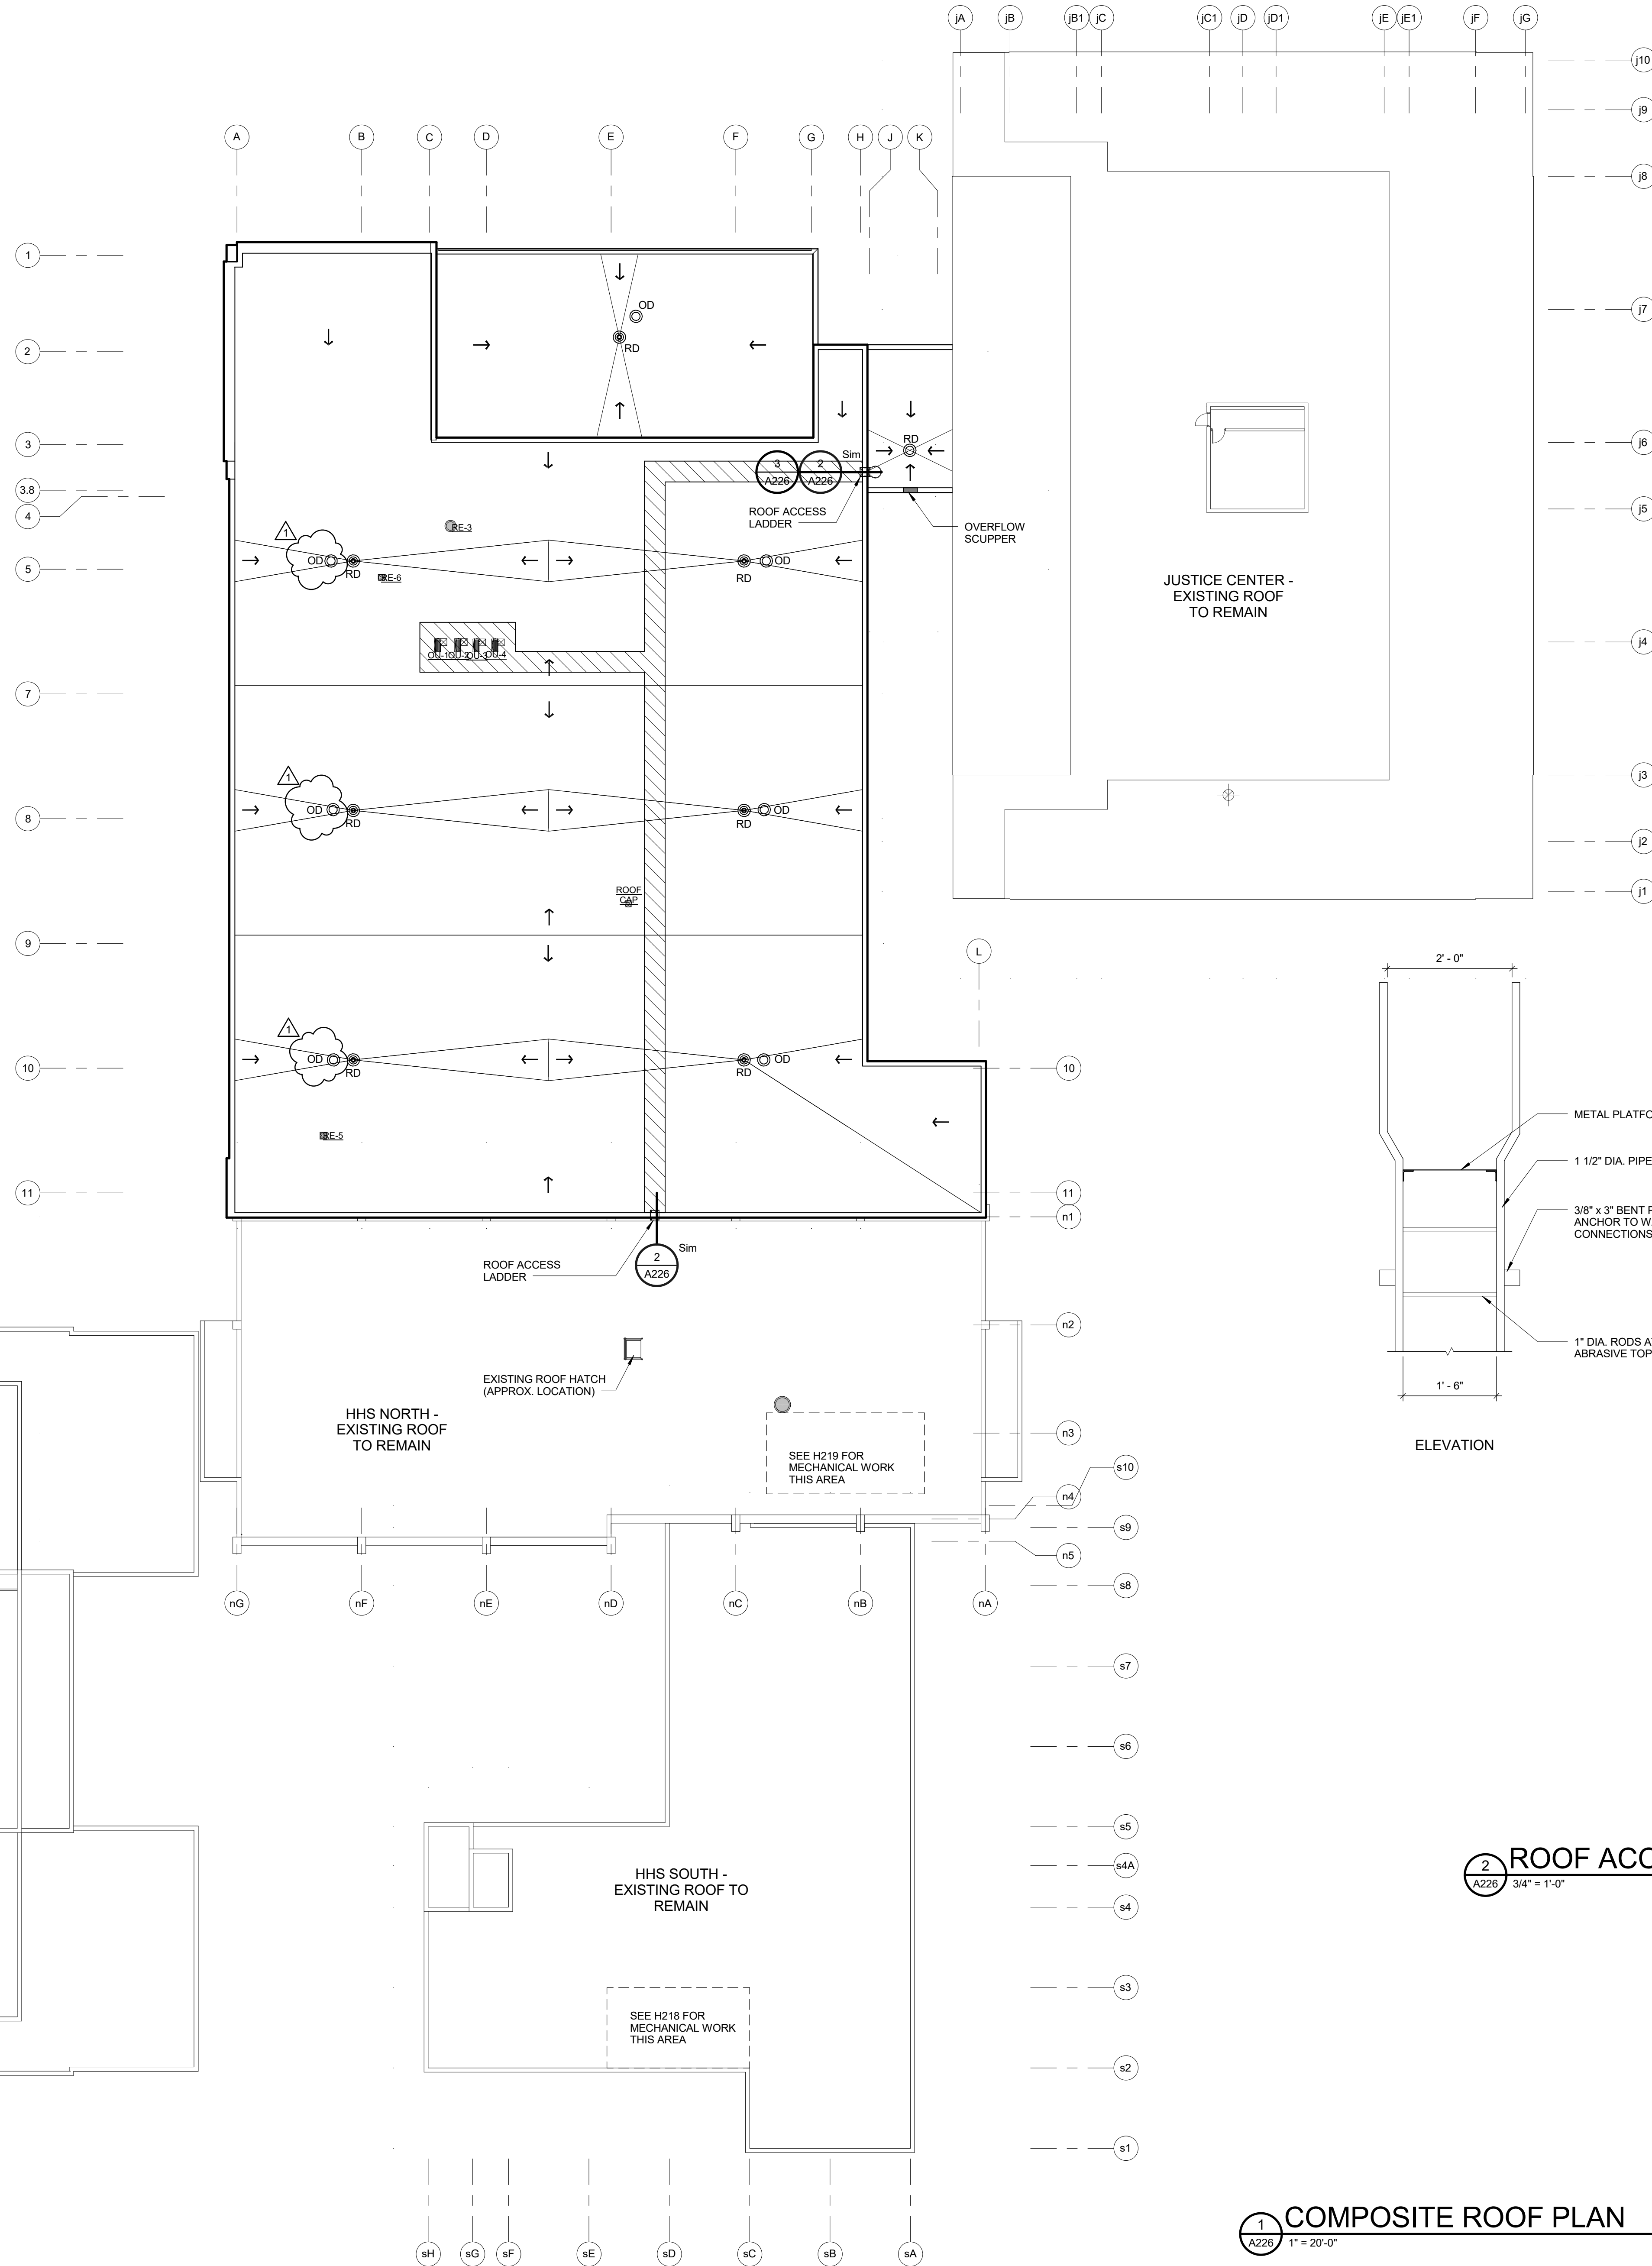

1 COMPOSITE ROOF PLAN
A226 1" = 20'-0"

- GENERAL ROOF PLAN NOTES**
- SLOPE TAPERED INSULATION MINIMUM 1/4" PER FOOT TO ROOF DRAINS, 2" MINIMUM THICKNESS AT DRAINS. AVERAGE ROOF INSULATION MIN. 4"
 - NOT ALL ROOF PENETRATIONS INDICATED. ROOFING CONTRACTOR TO VERIFY PENETRATIONS WITH ALL BUILDING TRADES. PROVIDE APPROPRIATE FLASHING AS REQUIRED TO MAKE WATERTIGHT.
 - SEE HVAC DRAWINGS FOR SIZES, QUANTITIES LOCATIONS AND TYPES OF HVAC PENETRATIONS AND ROOF TOP MOUNTED EQUIPMENT.
 - PROVIDE ROOF INSULATION SADDLES AT ANY ROOF INTERFERENCES. SLOPE ON SADDLE TO BE 1/2" PER FOOT.

- ROOF PLAN LEGEND:**
- RD ROOF DRAIN - SEE DETAILS AND SPECIFICATIONS FOR ADDITIONAL INFORMATION
 - OD OVERFLOW ROOF DRAIN - SEE DETAILS AND SPECIFICATIONS FOR ADDITIONAL INFORMATION
 - SCUPPER OVERFLOW ROOF DRAIN - SEE DETAILS AND SPECIFICATIONS FOR ADDITIONAL INFORMATION
 - REINFORCED ROOF WALKWAY
 - TAPERED RIGID INSULATION- 1/4" PER FOOT MINIMUM, 1/2" PER FOOT @ EQUIPMENT SADDLES

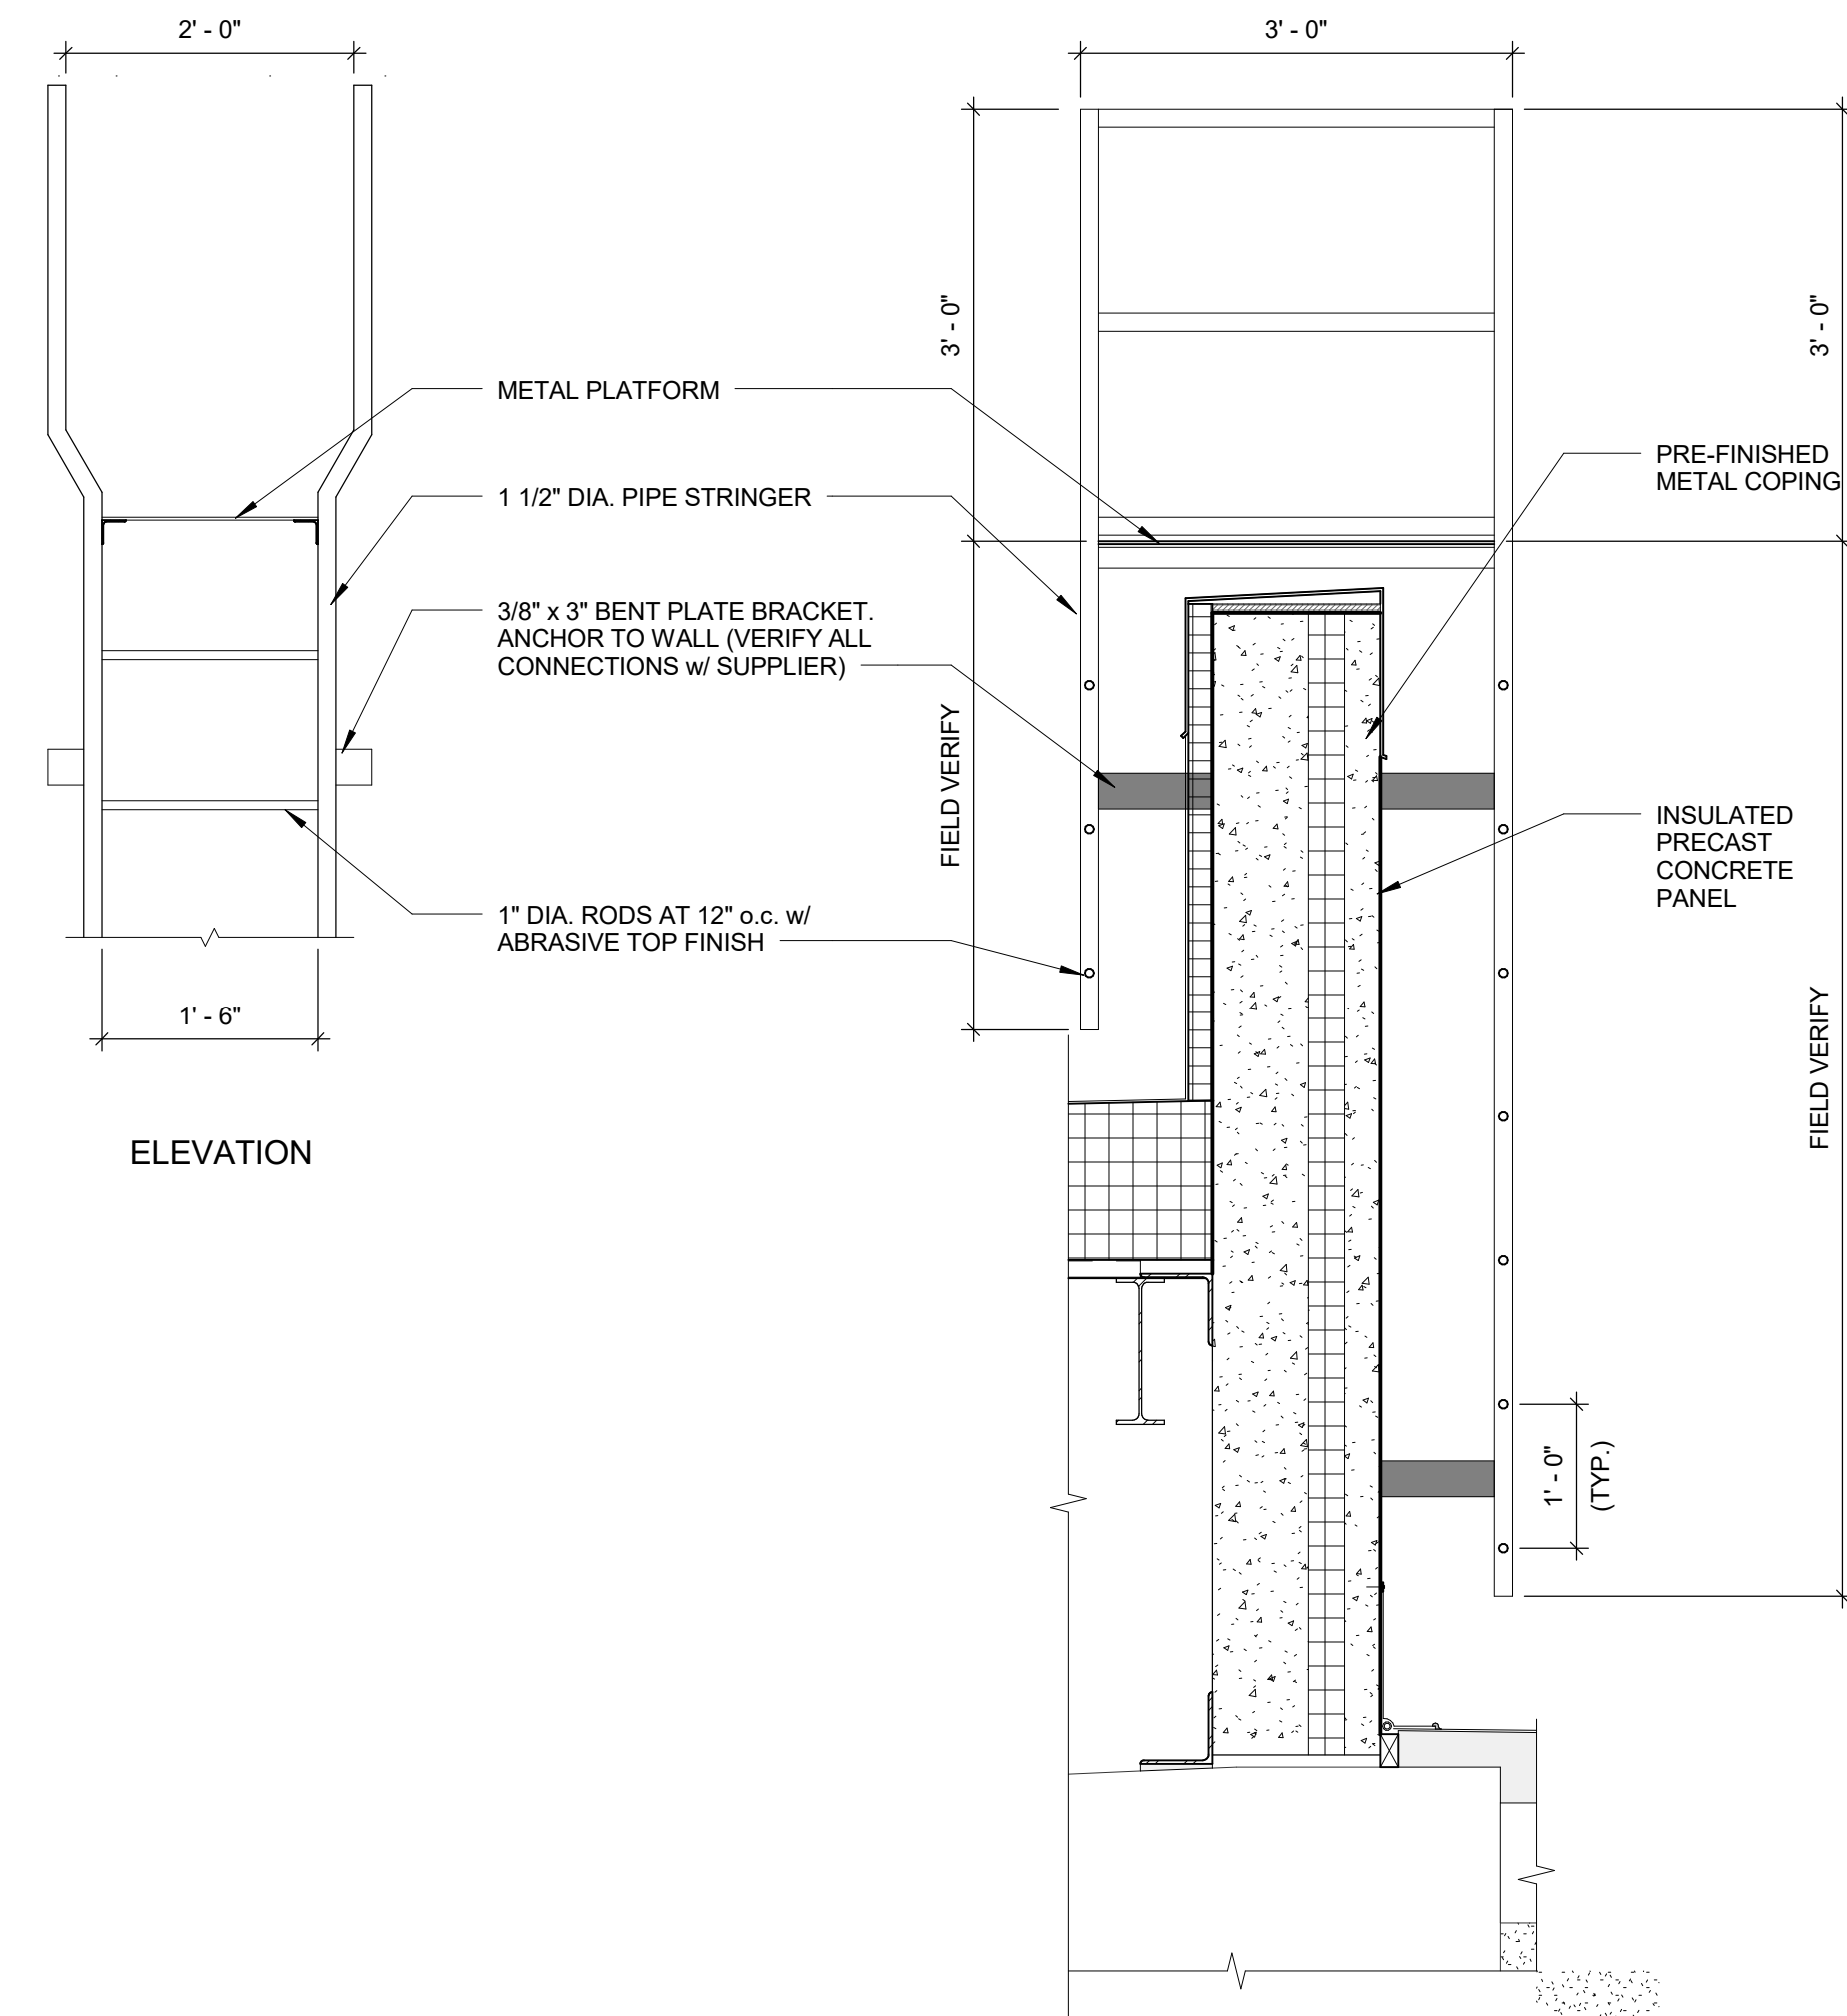


2 ROOF ACCESS LADDER DETAIL
A226 3/4" = 1'-0"

NO.	DATE	REVISION
1	3/3/2017	ADDENDUM 1

DESIGNED ASF	DRAWN BLG
PROJECT NO. 00002-61600160	DATE MARCH 3, 2017
SHEET NO.	






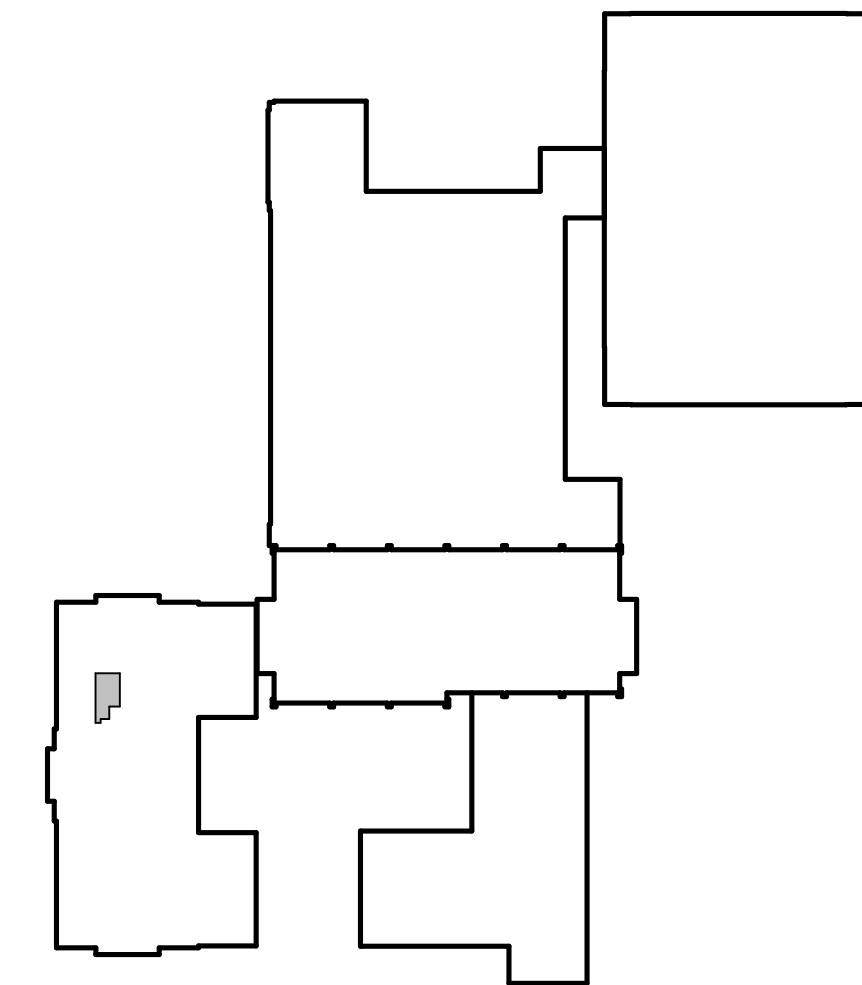


PLAN KEY

NOT TO SCALE

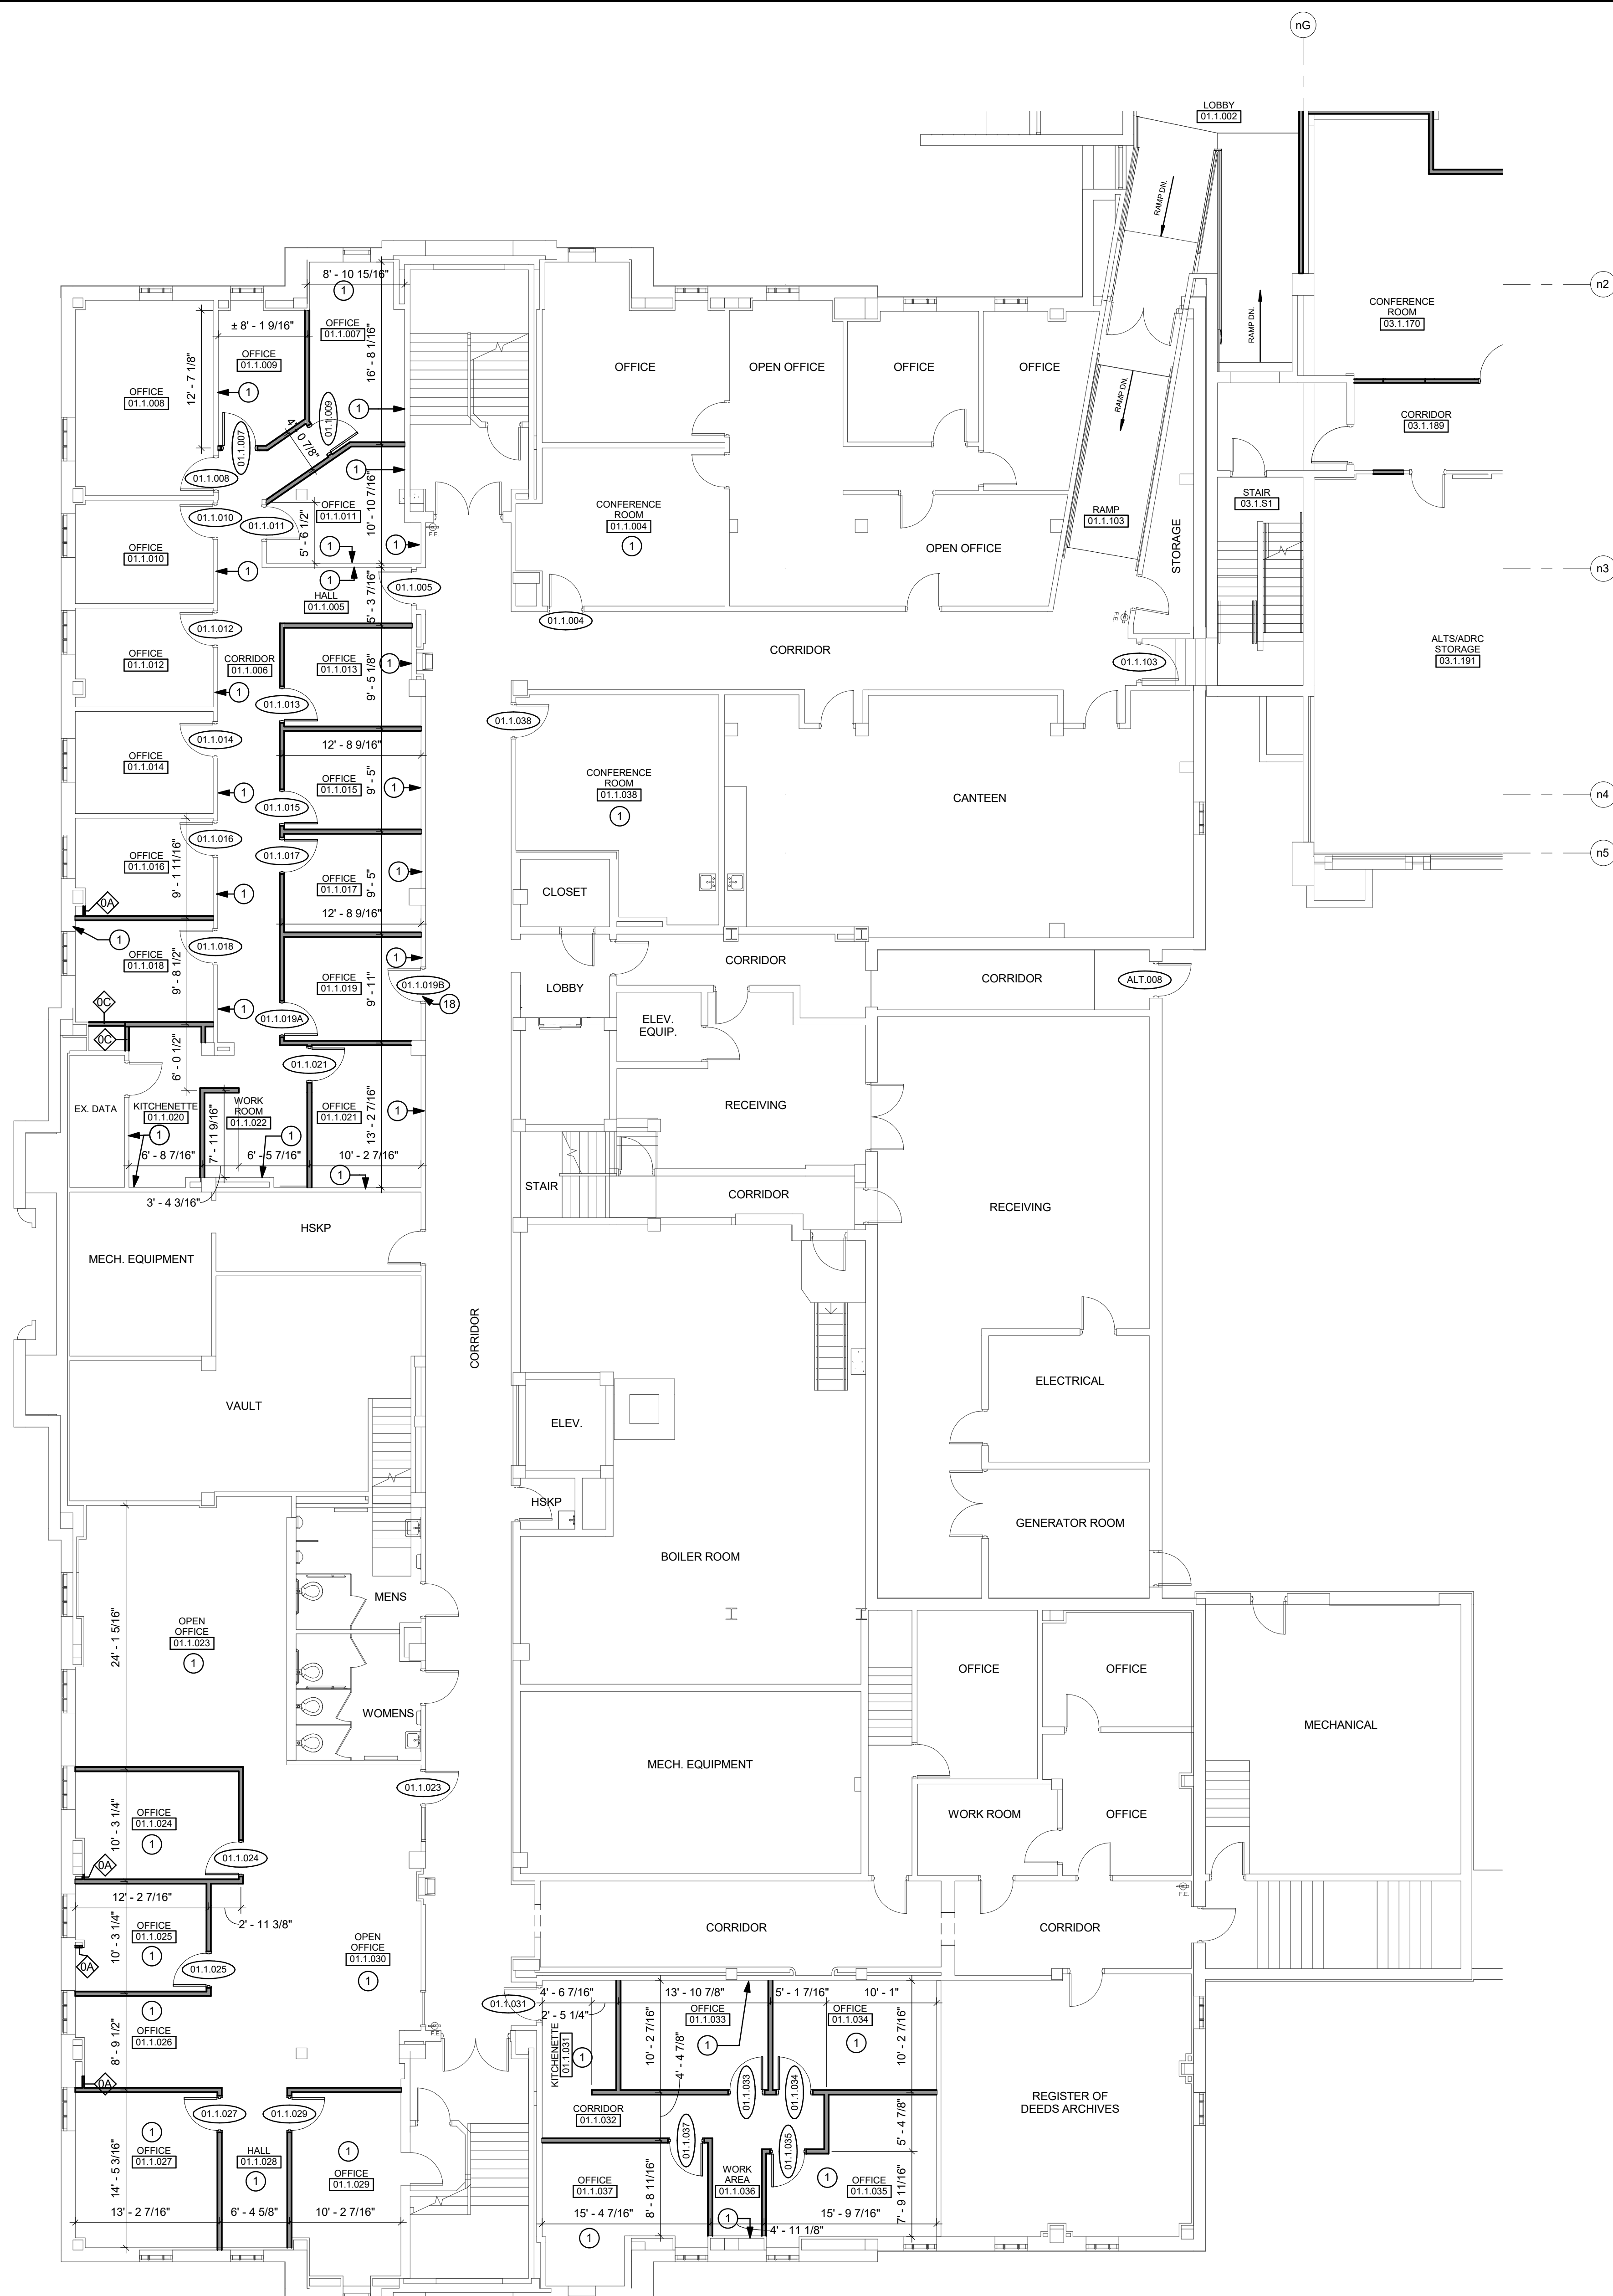

1 ENLARGED FLOOR PLAN - LEVEL 790.00

A232 $1/8" = 1'-0"$

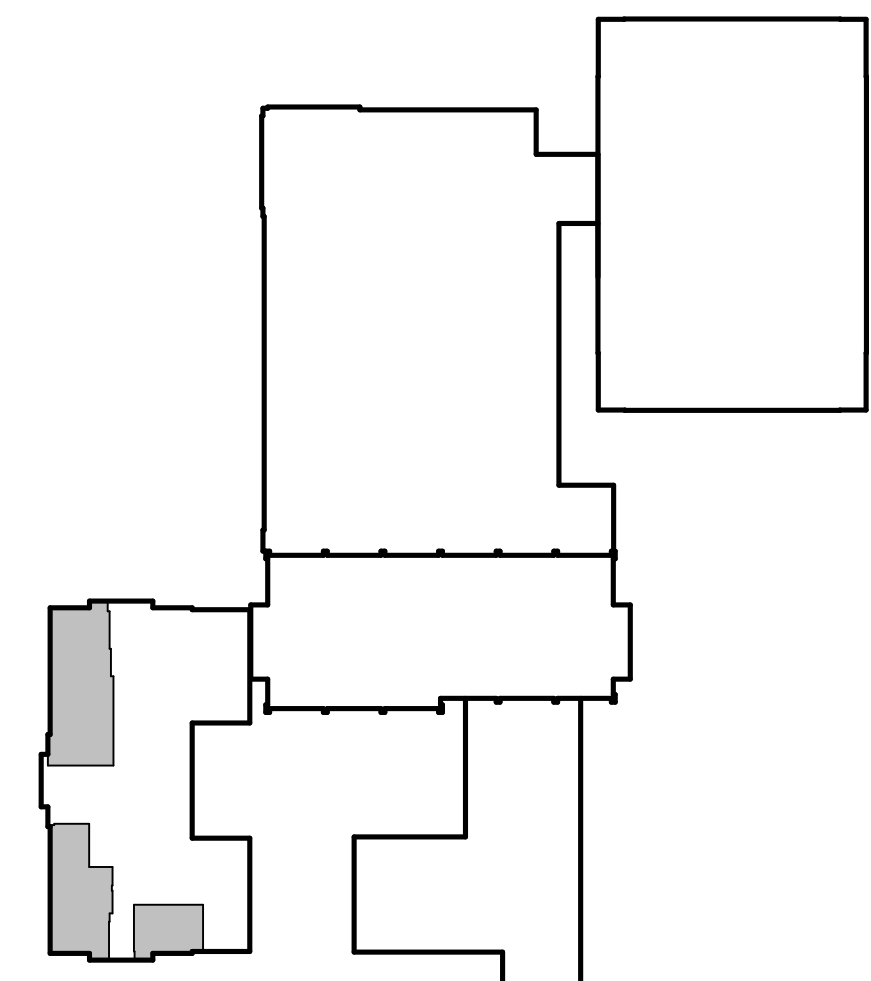

PLAN KEY

NOT TO SCALE



GENERAL PLAN NOTES

- SEE SHEET A002 FOR WALL TYPE DESCRIPTIONS.
- ALL NEW STUD PARTITIONS SHALL BE TYPE 08 UNLESS NOTED OTHERWISE.
- VERIFY EXISTING DIMENSIONS, CONDITIONS AND FINISHES BEFORE PROCEEDING WITH WORK. DO NOT SCALE FROM DRAWINGS. PRIOR ANY DISCREPANCIES TO THE ARCHITECTS AT THE OFFICE ON IMMEDIATELY.
- COORDINATE LOCATIONS AND QUANTITIES OF WORK WITH MECHANICAL, ELECTRICAL, AND PLUMBING CONTRACTORS.
- ALL DIMENSIONS ARE CLEAR FROM CENTERLINE OF WALL/PARTITION TO CENTERLINE OF WALL/PARTITION OR FACE OF EXISTING WALLS ACTUAL FACE.
- ALL PIPING, CONDUIT AND RELATED MECHANICAL AND ELECTRICAL ITEMS SHALL BE CONCEALED WITH GYPSUM BOARD CURING AS REQUIRED IN FINISHED AREAS UNLESS SHOWN ON DRAWINGS OR NOT. UNLESS NOTED OTHERWISE.
- PROVIDE METAL PLATE BACKING AND/OR TREATED WOOD BLOCKING IN WALLS WHERE WALL-MOUNTED EQUIPMENT IS SHOWN ON OR OUT OF ELEVATIONS. VERIFY HEIGHT AND LENGTH WITH EXISTING EQUIPMENT.
- MATCH FINISHED WALL OR PARTITION THICKNESS WHERE NEW WALLS OR PARTITIONS OCCUR IN LINE WITH EXISTING WALL FINISHES. REGARDLESS OF PARTITION TAG.
- PROVIDE STUD CONTROL BETWEEN CONSTRUCTION AREAS AND OCCUPIED AREAS AT ALL TIMES.
- PATCH, LEVEL, AND PAINT EXISTING WALLS AND COLUMNS SCHEDULED TO RECEIVE WALL FINISHES.
- FILL LEVEL, AND ALIGN EXISTING FLOORS AS REQUIRED TO RECEIVE NEW FLOOR FINISHES.
- REMOVE ALL DEMOLITION AND CONSTRUCTION DEBRIS FROM THE CONSTRUCTION SITE DAILY AND PLACE IN THE APPROPRIATE REUSE OR RECYCLING CONTAINERS. WORK AREA SHALL BE KEPT CLEAN AND FREE FROM DUST, DIRT, AND DEBRIS.
- SEE CODE PLAN AND SUMMARY SCHEDULES FOR LIFE SAFETY PLANS AND FIRE PROTECTION RATING REQUIREMENTS.
- COORDINATE WALL BUCKING LOCATIONS FOR SYSTEMS FURNITURE V OWNER'S FURNITURE VENDOR.

PLAN KEY

----- DASHED LINE INDICATES WHERE PARTITION
GOES TO STRUCTURE W/ MINERAL WOOL
INSULATION. SEE A002 FOR DETAILS.

PLAN KEYED NOTES

- 1 PATCH & PREP EXISTING WALL TO RECEIVE NEW FINISH AS
REQUIRED FOR NEW CONSTRUCTION.
18 RELOCATE EXISTING EXIT SIGN TO ABOVE DOOR 01.1.005.

ALTERATION / ADDITION

OUTAGAMIE COUNTY ADMINISTRATION CENTER
S. WALNUT & W. 8TH, APPLETON WI 54911

LEVEL 790.00 AND 820.00 ENLARGED ALTERATION PLAN - CAB

DESIG
MA

DRAWN
RLG

PROJECT NO.	
-------------	--

DATE _____


SHEET NO.

SHEET NO.

A232

McMAHON
ENGINEERS ARCHITECTS
1445 McMAHON DRIVE NEENAH, WI 54956
Mailing: P.O. BOX 1025 NEENAH, WI 54957-1025
Tel: (920) 751-4200 Fax: (920) 751-4284
www.mcmgrp.com

McMahon provides this drawing and data, regardless of form, as instruments of service. All rights including copyrights are retained by McMahon. The client and/or recipient agrees to the fullest extent permitted by law to indemnify and hold McMahon harmless for any reuse of or changes made to the original drawing or data without prior written consent by McMahon.

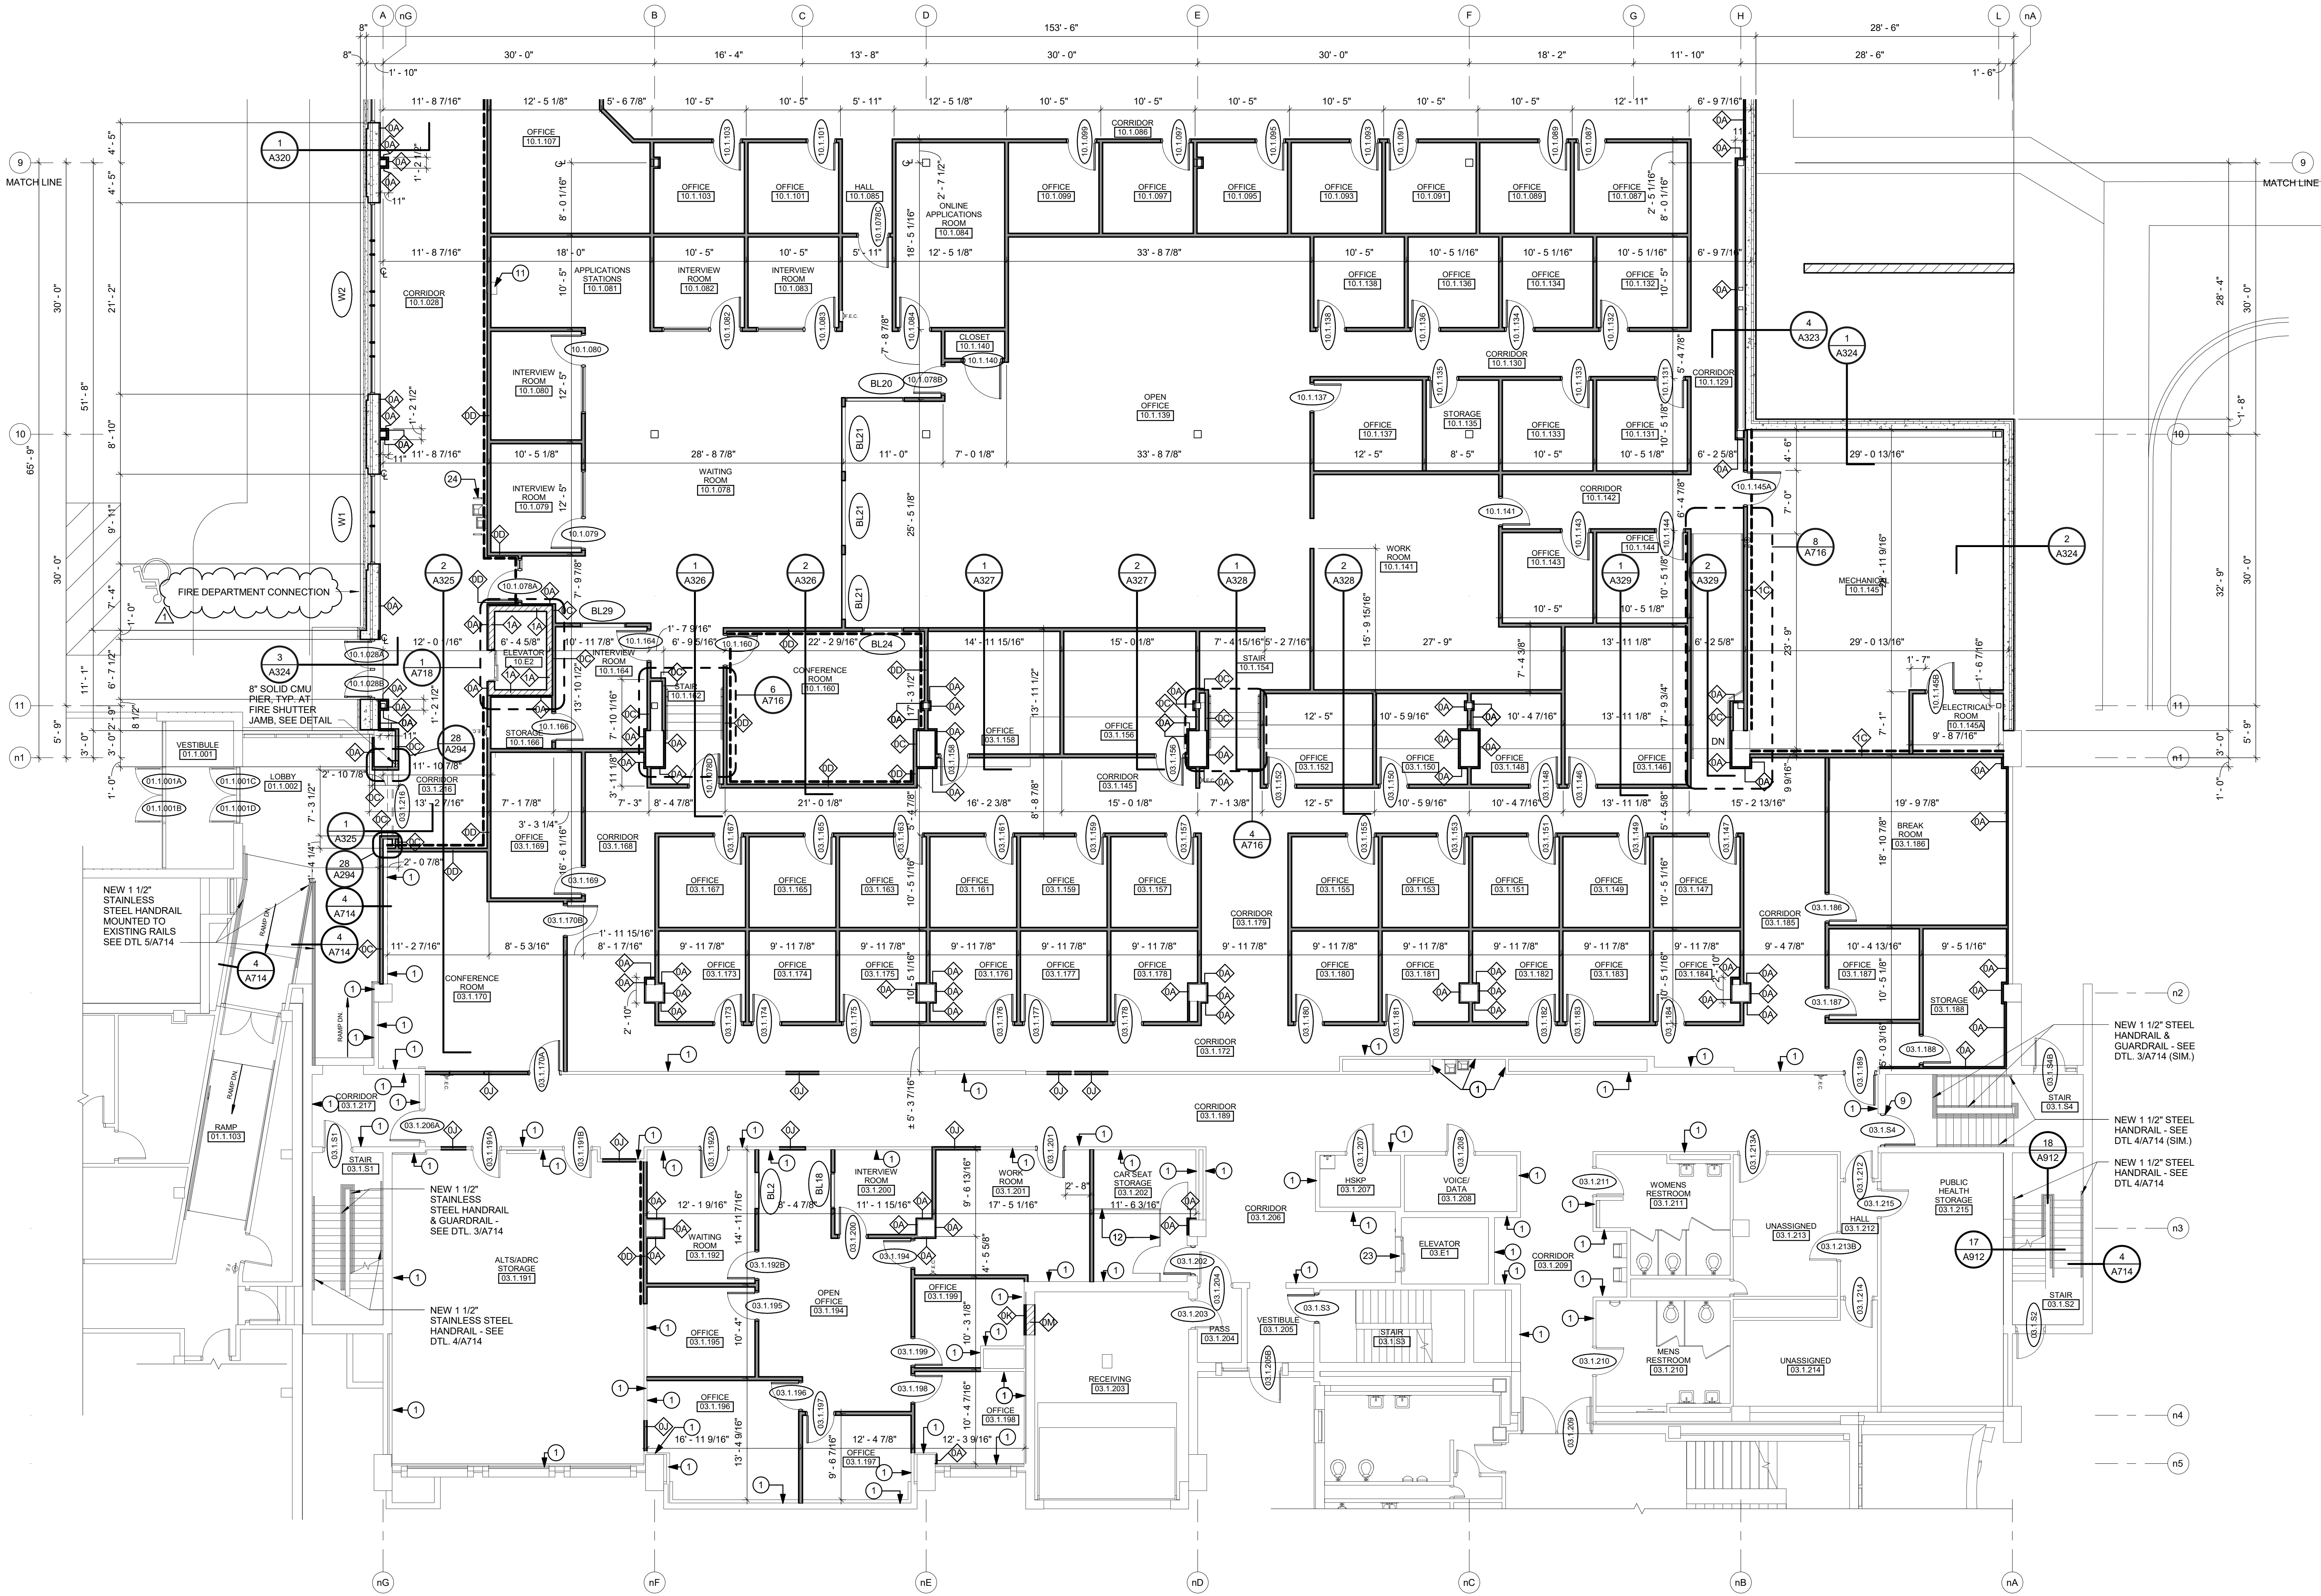

GENERAL PLAN NOTES


- SEE SHEET A002 FOR WALL TYPE DESCRIPTIONS.
- ALL NEW STUD PARTITIONS SHALL BE TYPE 08 UNLESS NOTED OTHERWISE.
- VERIFY EXISTING DIMENSIONS, CONDITIONS, AND FINISHES BEFORE PROCEEDING WITH WORK. DO NOT SCALE FROM DRAWINGS. BRING ANY DISCREPANCIES TO THE ARCHITECTS ATTENTION IMMEDIATELY.
- COORDINATE LOCATIONS AND QUANTITY OF WORK WITH MECHANICAL, ELECTRICAL, AND PLUMBING CONTRACTORS.
- ALL DIMENSIONS ARE CLEAR FROM CENTERLINE OF WALL/PARTITION TO CENTERLINE OF WALL/PARTITION OR FACE OF EXISTING WALLS ACTUAL FACE.
- ALL PIPING, CONDUIT AND RELATED MECHANICAL AND ELECTRICAL ITEMS SHALL BE CONCEALED WITHIN GYPSUM BOARD FURRING AS REQUIRED IN FINISHED AREAS WHETHER SHOWN ON DRAWINGS OR NOT, UNLESS NOTED OTHERWISE.
- PROVIDE METAL PLATE BACKING AND/OR TREATED WOOD BLOCKING IN WALLS WHERE WALL-MOUNTED EQUIPMENT IS SHOWN ON PLANS OR ELEVATIONS. VERIFY HEIGHT AND LENGTH WITH ACTUAL EQUIPMENT.
- MATCH FINISHED WALL OR PARTITION THICKNESS WHERE NEW WALLS OR PARTITIONS OCCUR IN LINE WITH EXISTING WALL FINISHES. REGARDLESS OF PARTITION TAG.
- PROVIDE DUST CONTROL BETWEEN CONSTRUCTION AREAS AND OCCUPIED AREAS AT ALL TIMES.
- PATCH, LEVEL, AND PREP ALL EXISTING WALLS AND COLUMNS SCHEDULED TO RECEIVE WALL FINISHES.
- FILL, LEVEL, AND ALIGN EXISTING FLOORS AS REQUIRED TO RECEIVE NEW FLOOR FINISHES.
- REMOVE ALL DEMOLITION AND CONSTRUCTION DEBRIS FROM THE CONSTRUCTION SITE DAILY AND PLACE IN THE APPROPRIATE REFUSE OR RECYCLING CONTAINERS. WORK AREA SHALL BE KEPT CLEAN AND FREE OF DUST, DIRT, AND DEBRIS.
- SEE CODE PLAN AND SUMMARY SHEETS FOR LIFE SAFETY PLANS AND FIRE PARTITION RATINGS.
- COORDINATE WALL BACKING LOCATIONS FOR SYSTEMS FURNITURE w/ OWNER'S FURNITURE VENDOR.

PLAN KEY

- DASHED LINE INDICATES WHERE PARTITION GOES TO STRUCTURE W/ MINERAL WOOL INSULATION. SEE A002 FOR DETAILS.
- INDICATES EXISTING WALL TO REMAIN.

PLAN KEYED NOTES

- PATCH & PREP EXISTING WALL TO RECEIVE NEW FINISH AS REQUIRED FOR NEW CONSTRUCTION.
- VERIFY EXISTING OPENING FOR NEW DOOR REPLACEMENT.
- RELOCATED EXISTING MAIL SLOT AND DROPBOX.
- FENCING - SEE SPECIFICATIONS FOR DETAILS.
- UPGRADES TO EXISTING ELEVATOR - SEE SPECIFICATIONS.
- STAINLESS STEEL GUARD RAILS - SEE DETAIL 3/A912.

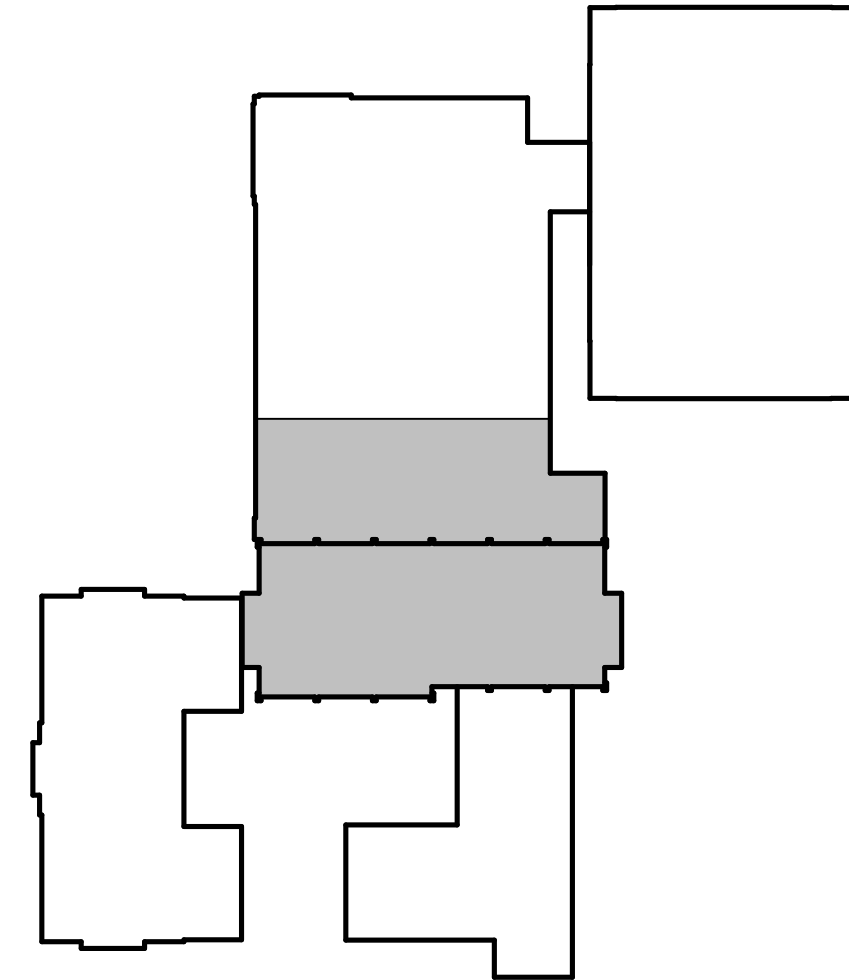

1 ENLARGED FLOOR PLAN
A233 1/8" = 1'-0"

PLAN KEY
NOT TO SCALE



GENERAL PLAN NOTES

- SEE SHEET A002 FOR WALL TYPE DESCRIPTIONS.
- ALL NEW STUD PARTITIONS SHALL BE TYPE 08 UNLESS NOTED OTHERWISE.
- VERIFY EXISTING DIMENSIONS, CONDITIONS, AND FINISHES BEFORE PROCEEDING WITH WORK. DO NOT SCALE FROM DRAWINGS. BRING ANY DISCREPANCIES TO THE ARCHITECTS ATTENTION IMMEDIATELY.
- COORDINATE LOCATIONS AND QUANTITY OF WORK WITH MECHANICAL, ELECTRICAL AND PLUMBING CONTRACTORS.
- ALL DIMENSIONS ARE CLEAR FROM CENTERLINE OF WALL/PARTITION OR FACE OF EXISTING WALLS ACTUAL FACE.
- ALL PIPING, CONDUIT AND RELATED MECHANICAL AND ELECTRICAL ITEMS SHALL BE CONCEALED WITHIN GYPSUM BOARD FURRING AS REQUIRED IN FINISHED AREAS WHETHER SHOWN ON DRAWINGS OR NOT, UNLESS NOTED OTHERWISE.
- PROVIDE METAL PLATE BACKING AND/OR TREATED WOOD BLOCKING IN WALLS WHERE WALL-MOUNTED EQUIPMENT IS SHOWN ON PLANS OR ELEVATIONS. VERIFY HEIGHT AND LENGTH WITH ACTUAL EQUIPMENT.
- MATCH FINISHED WALL OR PARTITION THICKNESS WHERE NEW WALLS OR PARTITIONS OCCUR IN LINE WITH EXISTING WALL FINISHES, REGARDLESS OF PARTITION TAG.
- PROVIDE DUST CONTROL BETWEEN CONSTRUCTION AREAS AND OCCUPIED AREAS AT ALL TIMES.
- PATCH LEVEL AND PREP ALL EXISTING WALLS AND COLUMNS SCHEDULED TO RECEIVE WALL FINISHES.
- FILL, LEVEL, AND ALIGN EXISTING FLOORS AS REQUIRED TO RECEIVE NEW FLOOR FINISHES.
- REMOVE ALL DEMOLITION AND CONSTRUCTION DEBRIS FROM THE CONSTRUCTION SITE DAILY AND PLACE IN THE APPROPRIATE REFUSE OR RECYCLING CONTAINERS. WORK AREA SHALL BE KEPT CLEAN AND FREE OF DUST, DIRT, AND DEBRIS.
- SEE CODE PLAN AND SUMMARY SHEETS FOR LIFE SAFETY PLANS AND FIRE PARTITION RATINGS.
- COORDINATE WALL BACKING LOCATIONS FOR SYSTEMS FURNITURE w/ OWNER'S FURNITURE VENDOR.

PLAN KEY

- DASHED LINE INDICATES WHERE PARTITION GOES TO STRUCTURE W/ MINERAL WOOL INSULATION. SEE A002 FOR DETAILS.
- INDICATES EXISTING WALL TO REMAIN.


PLAN KEYED NOTES

- 1 PATCH & PREP EXISTING WALL TO RECEIVE NEW FINISH AS REQUIRED FOR NEW CONSTRUCTION.
- 2 PATCH AND PAINT DOOR FRAME WHERE TRIM IS REMOVED.
- 23 UPGRADES TO EXISTING ELEVATOR - SEE SPECIFICATIONS.
- 24 STAINLESS STEEL GUARD RAILS - SEE DETAIL 3/A912.

1 ENLARGED FLOOR PLAN
1/8" = 1'-0"



PLAN KEY
NOT TO SCALE

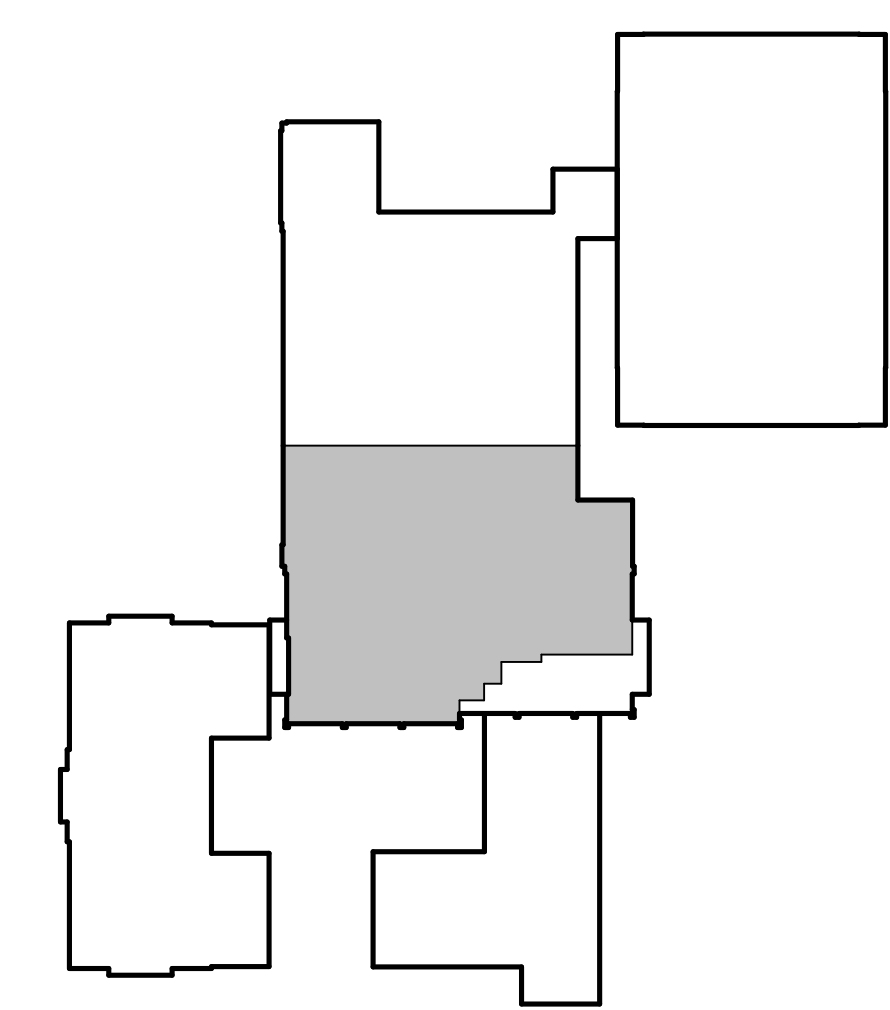

McMAHON

ENGINEERS ARCHITECTS

McMAHON

ENGINEERS ARCHITECTS

McMAHON

ENGINEERS ARCHITECTS

McMAHON

ENGINEERS ARCHITECTS

DESIGNED

ASF/MAG

DRAWN

BLG

PROJECT NO.

00002-61600160

DATE

MARCH 3, 2017

SHEET NO.

A236

ALTERATION / ADDITION

OUTAGAMIE COUNTY ADMINISTRATION CENTER

S. WALNUT & W. 8TH, APPLETON WI 54911

LEVEL 805.00 ENLARGED ALTERATION AND ADDITION PLAN - HHS NORTH/CAC SOUTH

NO.

1

DATE

3/30/2017

REVISION

ADDENDUM 1

McMAHON


ENGINEERS ARCHITECTS

McMAHON


ENGINEERS ARCHITECTS

McMAHON

ENGINEERS ARCHITECTS

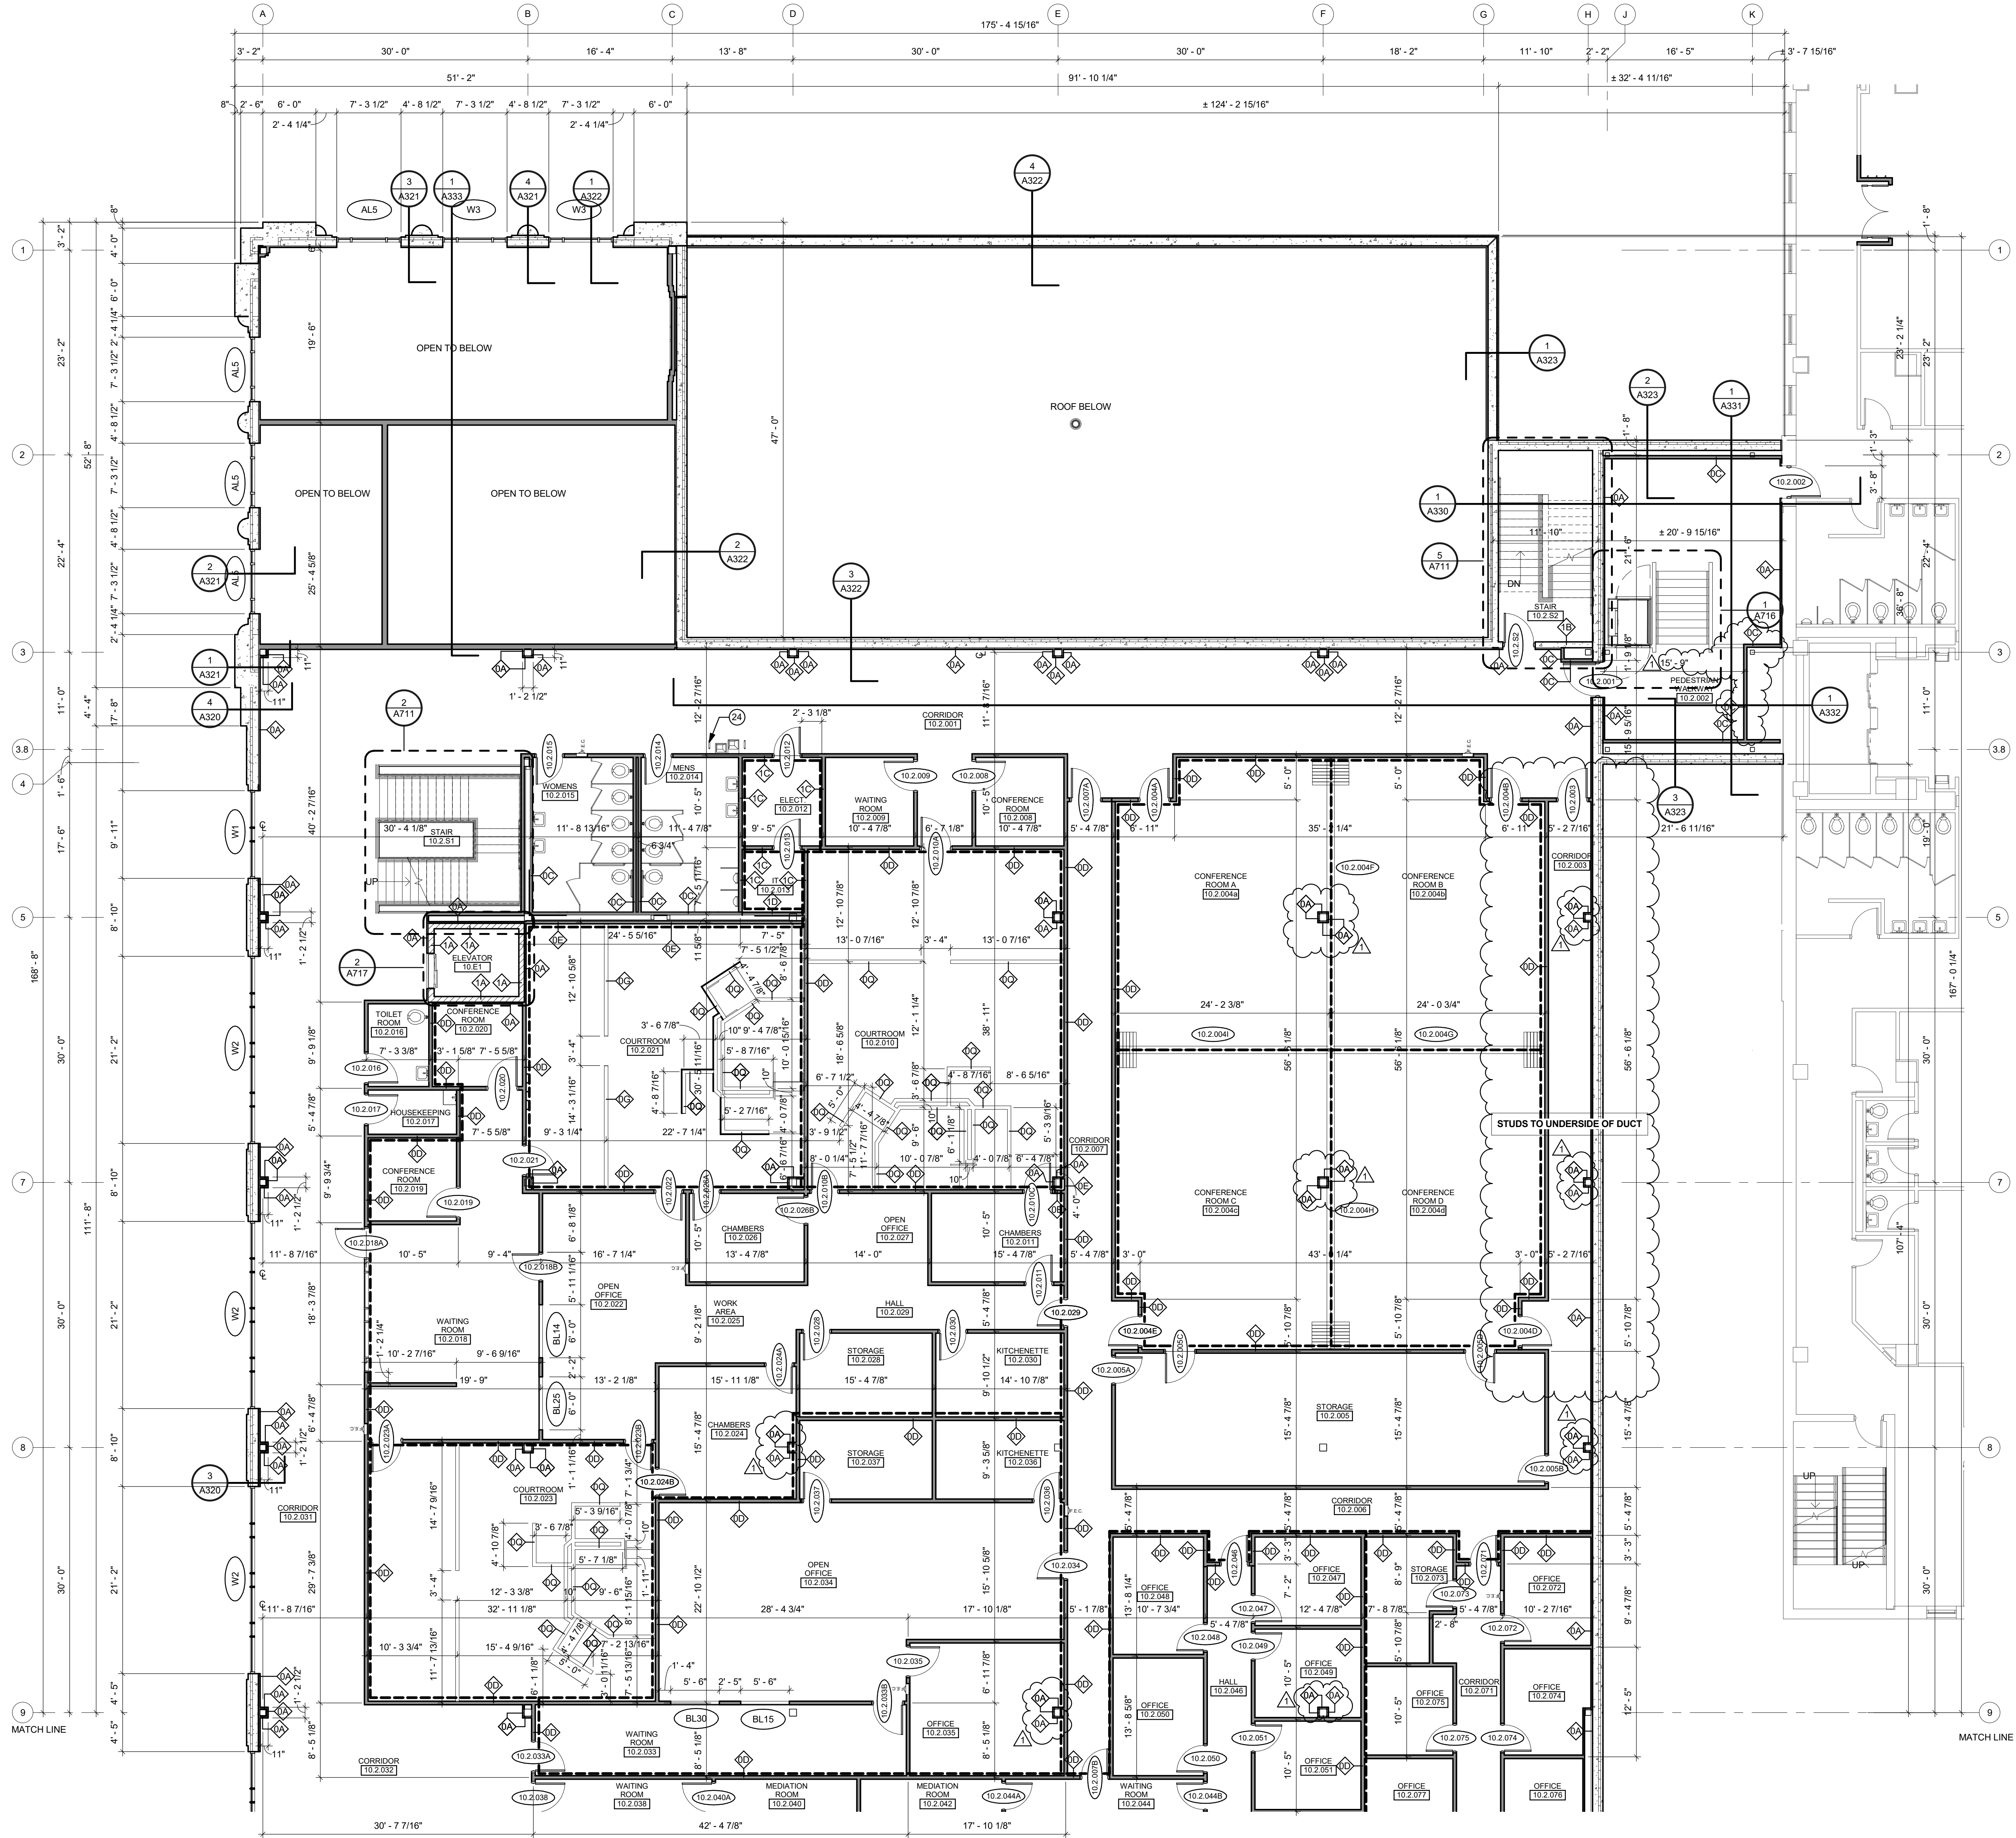

1 ENLARGED FLOOR PLAN
A237 1/8" = 1'-0"

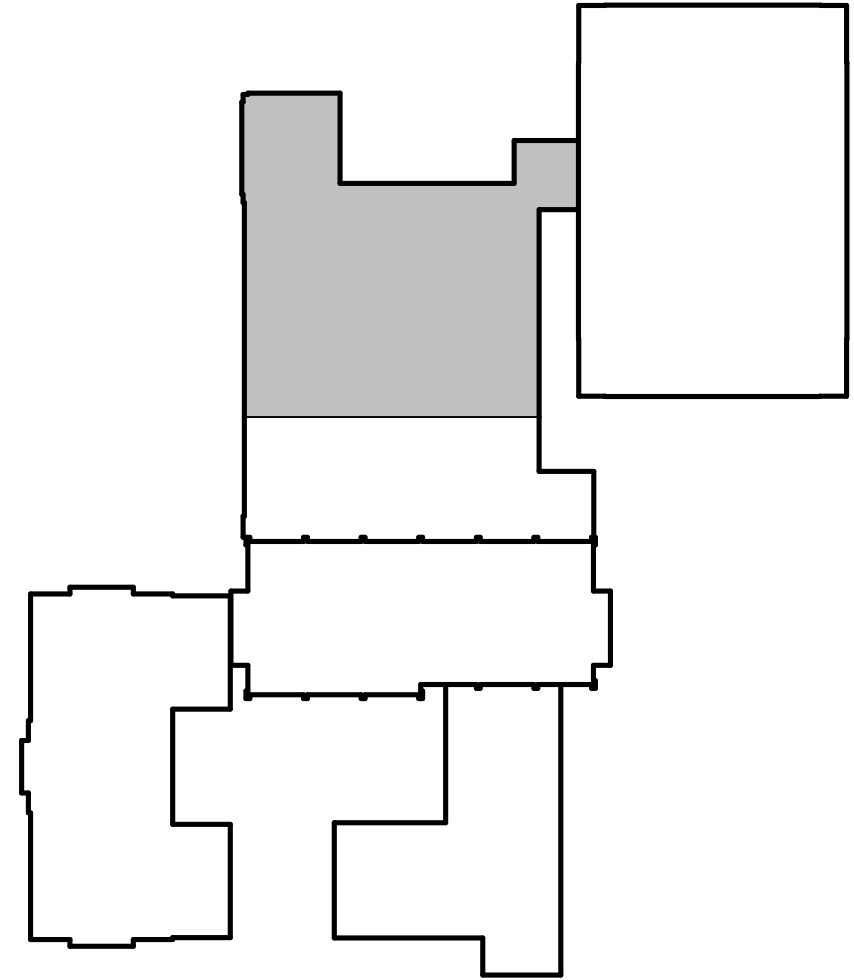

PLAN KEY
NOT TO SCALE




- GENERAL PLAN NOTES**
- SEE SHEET A002 FOR WALL TYPE DESCRIPTIONS.
 - ALL NEW STUD PARTITIONS SHALL BE TYPE 0B UNLESS NOTED OTHERWISE.
 - VERIFY EXISTING DIMENSIONS, CONDITIONS, AND FINISHES BEFORE PROCEEDING WITH WORK. DO NOT SCALE FROM DRAWINGS. BRING ANY DISCREPANCIES TO THE ARCHITECTS ATTENTION IMMEDIATELY.
 - COORDINATE LOCATIONS AND QUANTITY OF WORK WITH MECHANICAL, ELECTRICAL, AND PLUMBING CONTRACTORS.
 - ALL DIMENSIONS ARE CLEAR FROM CENTERLINE OF WALL/PARTITION TO CENTERLINE OF WALL/PARTITION OR FACE OF EXISTING WALLS ACTUAL FACE.
 - ALL PIPING, CONDUIT AND RELATED MECHANICAL AND ELECTRICAL ITEMS SHALL BE CONCEALED WITHIN GYPSUM BOARD FURNISHING AS REQUIRED IN FINISHED AREAS WHETHER SHOWN ON DRAWINGS OR NOT. UNLESS NOTED OTHERWISE.
 - PROVIDE METAL PLATE BACKING AND/OR TREATED WOOD BLOCKING IN WALLS WHERE WALL-MOUNTED EQUIPMENT IS SHOWN ON PLANS OR ELEVATIONS. VERIFY HEIGHT AND LENGTH WITH ACTUAL EQUIPMENT.
 - MATCH FINISHED WALL OR PARTITION THICKNESS WHERE NEW WALLS OR PARTITIONS OCCUR IN LINE WITH EXISTING WALL FINISHES, REGARDLESS OF PARTITION TAG.
 - PROVIDE DUST CONTROL BETWEEN CONSTRUCTION AREAS AND OCCUPIED AREAS AT ALL TIMES.
 - PATCH, LEVEL, AND PREP ALL EXISTING WALLS AND COLUMNS SCHEDULED TO RECEIVE WALL FINISHES.
 - FILL, LEVEL, AND ALIGN EXISTING FLOORS AS REQUIRED TO RECEIVE NEW FLOOR FINISHES.
 - REMOVE ALL DEMOLITION AND CONSTRUCTION DEBRIS FROM THE CONSTRUCTION SITE DAILY AND PLACE IN THE APPROPRIATE REFUSE OR RECYCLING CONTAINERS. WORK AREA SHALL BE KEPT CLEAN AND FREE OF DUST, DIRT, AND DEBRIS.
 - SEE CODE PLAN AND SUMMARY SHEETS FOR LIFE SAFETY PLANS AND FIRE PARTITION RATINGS.
 - COORDINATE WALL BACKING LOCATIONS FOR SYSTEMS FURNITURE W/ OWNER'S FURNITURE VENDOR.
- PLAN KEY**
- DASHED LINE INDICATES WHERE PARTITION GOES TO STRUCTURE W/ MINERAL WOOL INSULATION. SEE A002 FOR DETAILS.
 - INDICATES EXISTING WALL TO REMAIN.
- PLAN KEYED NOTES**
- 24 STAINLESS STEEL GUARD RAILS - SEE DETAIL 3/A912.

ALTERATION / ADDITION
OUTAGAMIE COUNTY ADMINISTRATION CENTER
S. WALNUT & W. 8TH, APPLETON WI 54911
LEVEL 805.00 ENLARGED ADDITION PLAN - OCAC NORTH

DESIGNED	DRAWN
ASF/MAG	BLG
PROJECT NO.	
00002-61600160	
DATE	
MARCH 3, 2017	
SHEET NO.	

A237

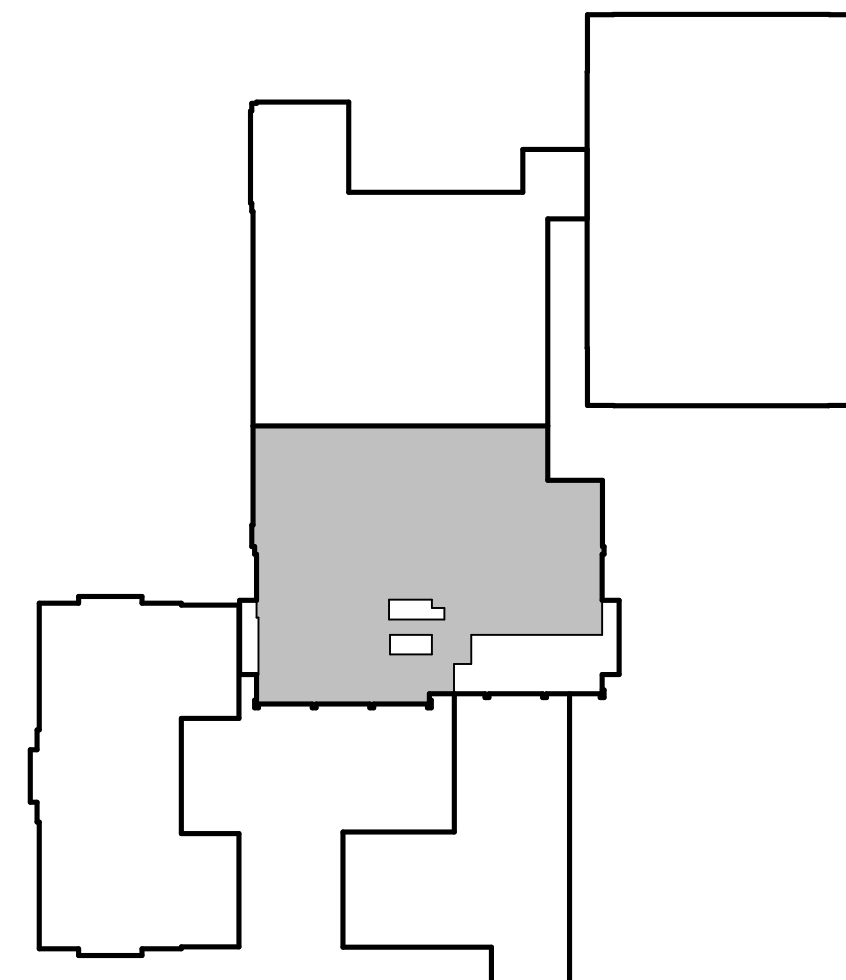

NORTH

A circular icon with a black border and a white background, containing a black arrow pointing upwards. The word "NORTH" is printed in black capital letters above the circle.

NOT TO SCALE

- SEE SHEET A002 FOR WALL TYPE DESCRIPTIONS.
- ALL NEW STUD PARTITIONS SHALL BE TYPE 0B UNLESS NOTED OTHERWISE.
- VERIFY EXISTING DIMENSIONS, CONDITIONS, AND FINISHES BEFORE PROCEEDING WITH WORK. DO NOT SCALE FROM DRAWINGS. BRING ANY DISCREPANCIES TO THE ARCHITECTS ATTENTION IMMEDIATELY.
- COORDINATE LOCATIONS AND QUANTITY OF WORK WITH MECHANICAL, ELECTRICAL, AND PLUMBING CONTRACTORS.
- ALL DIMENSIONS ARE CLEAR FROM CENTERLINE OF WALL/PARTITION TO CENTERLINE OF WALL/PARTITION OR FACE OF EXISTING WALLS ACTUAL FACE.
- ALL PIPING, CONDUIT AND RELATED MECHANICAL AND ELECTRICAL ITEMS SHALL BE CONCEALED WITHIN GYPSSUM BOARD FURRING AS REQUIRED IN FINISHED AREAS WHETHER SHOWN ON DRAWINGS OR NOT; UNLESS NOTED OTHERWISE.
- PROVIDE METAL PLATE BACKING AND/OR TREATED WOOD BLOCKING IN WALLS WHERE WALL-MOUNTED EQUIPMENT IS LOCATED. VERIFY LOCATIONS, VERIFY HEIGHT AND LENGTH WITH ACTUAL EQUIPMENT.
- MATCH FINISHED WALL OR PARTITION THICKNESS WHERE NEW WALLS OR PARTITIONS OCCUR IN LINE WITH EXISTING WALL FINISHES. REGARDLESS OF PARTITION TAG.
- PROVIDE DUST CONTROL BETWEEN CONSTRUCTION AREAS AND OCCUPYED AREAS AT ALL TIMES.
- PATCH, LEVEL AND PREP ALL EXISTING WALLS AND COLUMNS SUBJECT TO RECEIVE NEW FINISHES.
- FILL, LEVEL, AND ALIGN EXISTING FLOORS AS REQUIRED TO RECEIVE NEW FLOOR FINISHES.
- REMOVE ALL DEMOLITION AND CONSTRUCTION DEBRIS FROM CONSTRUCTION SITE DAILY AND PLACE IN THE APPROPRIATE REUSE OR RECYCLING CONTAINERS. WORK AREA SHALL BE FREE OF ALL DEBRIS, DIRT, AND DEBRIS.
- SEE CODE PLAN AND SUMMARY SHEETS FOR LIFE SAFETY PLAN AND FIRE PARTITION RATINGS.
- COORDINATE WALL BACKING LOCATIONS FOR SYSTEMS FURNITURE w/ OWNER'S FURNITURE VENDOR.

----- DASHED LINE INDICATES WHERE PARTITION
GOES TO STRUCTURE W/ MINERAL WOOL
INSULATION. SEE A002 FOR DETAILS.

INDICATES EXISTING WALL TO REMAIN.

1 PATCH & PREP EXISTING WALL TO RECEIVE NEW FINISH AS
7 REQUIRED FOR NEW CONSTRUCTION.
23 PATCH EXISTING CERAMIC TILE WALL WHERE TRIM IS REMOVED
24 UPGRADES TO EXISTING ELEVATOR - SEE SPECIFICATIONS.
25 STAINLESS STEEL GUARD RAILS - SEE DETAIL 3/A912.
25 FINISH WALL FACING EXISTING WINDOW WITH BREAK METAL TO
MATCH EXISTING WINDOW FRAMING.

McMahon provides this drawing and data, regardless of form, instruments of service. All rights including copyrights are retained by McMahon. The client and/or recipient agrees to the fullest extent permitted by law to indemnify and hold McMahon harmless for any reuse of or changes made to the original drawing or data without prior written consent by McMahon.

ALTERATION / ADDITION
OUTAGAMIE COUNTY ADMINISTRATION CENTER
S. WALNUT & W. 8TH, APPLETON WI 54911
LEVEL 820.00 ENLARGED ALTERATION AND ADDITION PLAN - HHS NORTH/OCAC SOUTH

A239



P-1	PAINT: PITTSBURGH PAINTS: SPEEDHIDE INTERIOR FLAT LATEX. COLOR: WHITE ROK 511-2
P-2	PAINT: PITTSBURGH PAINTS. COLOR: TO BE SELECTED BY ARCHITECT.
P-3	PAINT: PITTSBURGH PAINTS. COLOR: TO BE SELECTED BY ARCHITECT.
EP	EPOXY PAINT: PITTSBURGH PAINTS. COLOR: TO BE SELECTED BY ARCHITECT
WD	WOOD PANELING: MATCH WOOD DOOR FINISH
PT	PORCELAIN TILE: SEE INTERIOR ELEVATIONS FOR SPECIFIC LOCATIONS OF THE BELOW: PT-1 PORCELAIN TILE: FACTORY MOUNTED GLAZED CERAMIC TILE. COLOR: MATCH EXISTING. PT-2 PORCELAIN TILE: FACTORY MOUNTED GLAZED CERAMIC TILE. COLOR: MATCH EXISTING. PT-3 PORCELAIN TILE: FACTORY MOUNTED GLAZED CERAMIC TILE. COLOR: MATCH EXISTING.



McMAHON
ENGINEERS ARCHITECTS
1445 McMAHON DRIVE NEENAH, WI 54956
Mailing: P.O. BOX 1025 NEENAH, WI 54957-1025
Tel: (920) 751-4200 Fax: (920) 751-4284
www.mcmgrp.com


McMahon provides this drawing and data, regardless of form, as instruments of service. All rights including copyrights are retained by McMahon. The client and/or recipient agrees to the fullest extent permitted by law to indemnify and hold McMahon harmless for any reuse of or changes made to the original drawing or data without prior written consent by McMahon.

[illegible]

ALTERATION / ADDITION
OUTAGAMIE COUNTY ADMINISTRATION CENTER
S. WALNUT & W. 8TH, APPLETON WI 54911
LEVEL 790.00 AND 820.00 ENLARGED EQUIPMENT PLAN - CAB


DESIGNED MAG	DRAWN BLG
PROJECT NO. O0002-61600160	
DATE MARCH 3, 2017	
SHEET NO.	

A272

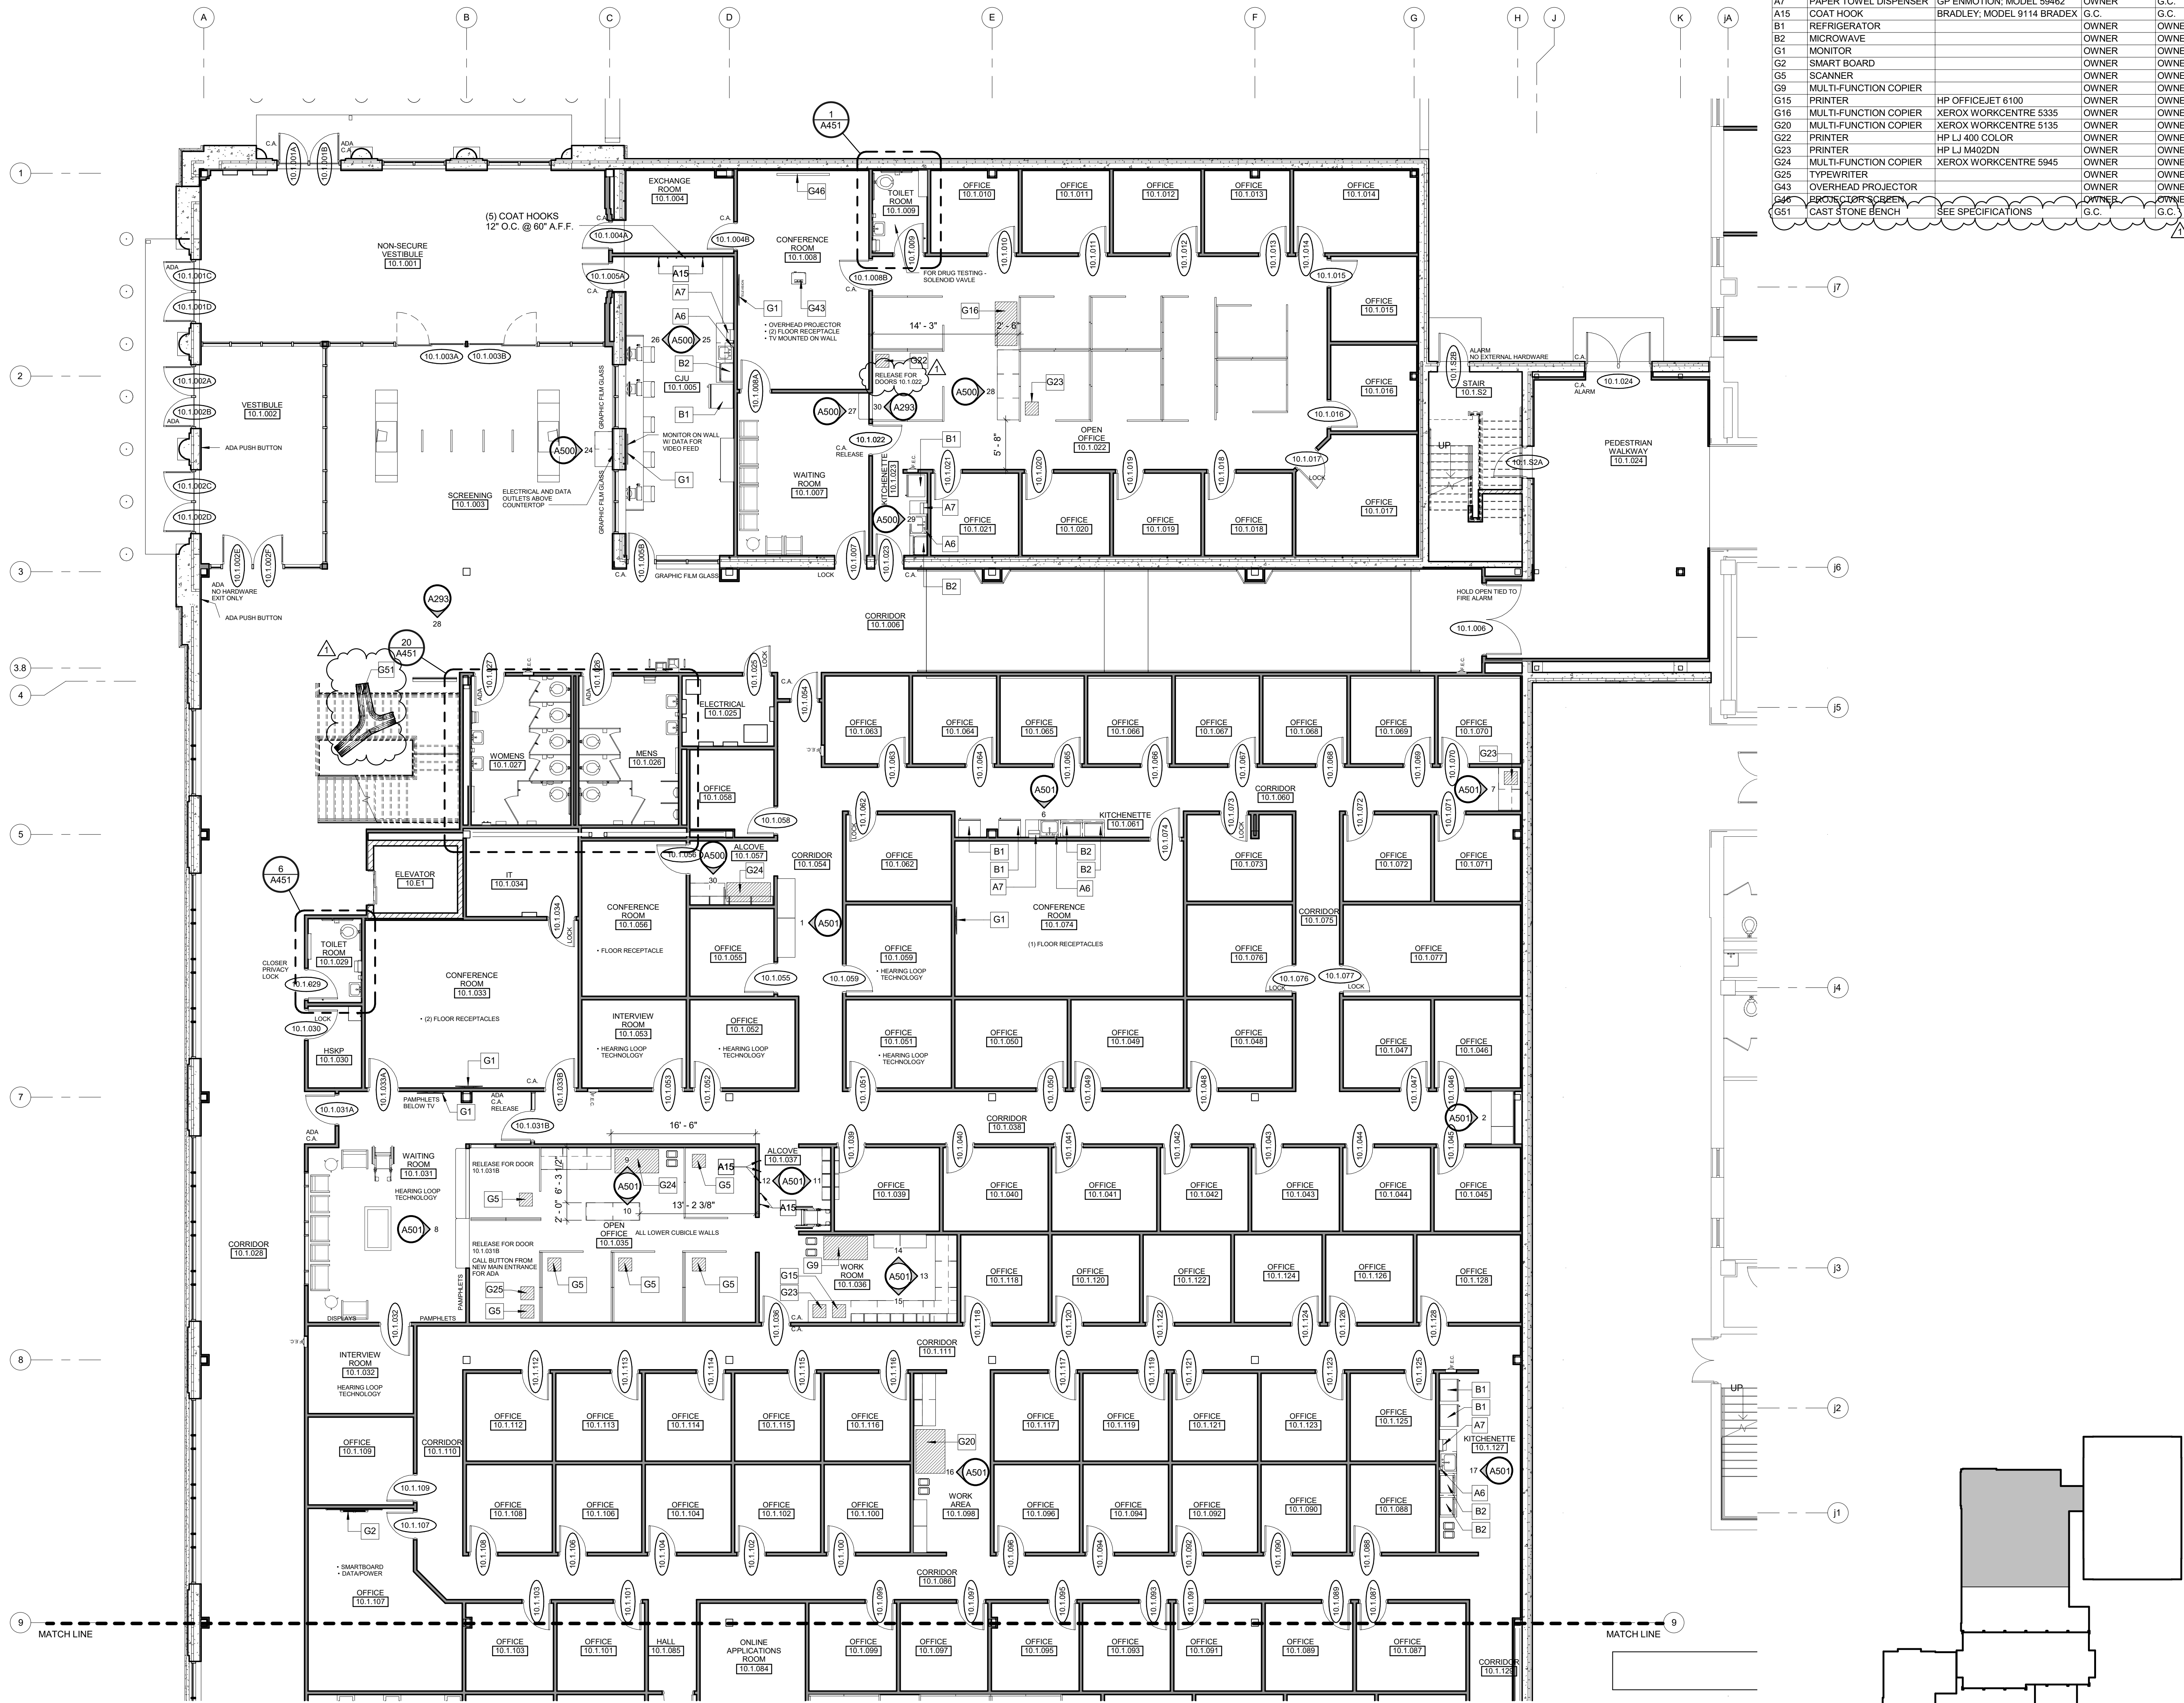

EQUIPMENT SCHEDULE - SHEET A274				
MARK	DESCRIPTION	MODEL	FURNISHED BY	INSTALLED BY
A6	SOAP DISPENSER	GOJO: MODEL ADX-7	OWNER	G.C.
A7	PAPER TOWEL DISPENSER	GP ENMOTION: MODEL 59462	OWNER	G.C.
A15	COAT HOOK	BRADLEY: MODEL 9114 BRADEX	G.C.	G.C.
B1	REFRIGERATOR		OWNER	OWNER
B2	MICROWAVE		OWNER	OWNER
G1	MONITOR		OWNER	OWNER
G2	SMART BOARD		OWNER	OWNER
G5	SCANNER		OWNER	OWNER
G9	MULTI-FUNCTION COPIER		OWNER	OWNER
G15	PRINTER	HP OFFICEJET 6100	OWNER	OWNER
G16	MULTI-FUNCTION COPIER	XEROX WORKCENTRE 5335	OWNER	OWNER
G20	MULTI-FUNCTION COPIER	XEROX WORKCENTRE 5135	OWNER	OWNER
G22	PRINTER	HP LJ 400 COLOR	OWNER	OWNER
G23	PRINTER	HP LJ M402DN	OWNER	OWNER
G24	MULTI-FUNCTION COPIER	XEROX WORKCENTRE 5845	OWNER	OWNER
G25	TYPEWRITER		OWNER	OWNER
G43	OVERHEAD PROJECTOR		OWNER	OWNER
G44	BACKLIT OFFICE LIGHTS		OWNER	OWNER
G51	CAST STONE BENCH	SEE SPECIFICATIONS	G.C.	G.C.

1 ENLARGED EQUIPMENT PLAN
A274 1/8" = 1'-0"

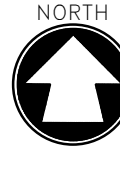

PLAN KEY
NOT TO SCALE




ALTERATION / ADDITION
OUTAGAMIE COUNTY ADMINISTRATION CENTER
S. WALNUT & W. 8TH, APPLETON WI 54911
LEVEL 790.00 ENLARGED EQUIPMENT PLAN - OCAC NORTH

DESIGNED	DRAWN
MAG	BLG
PROJECT NO.	
00002-61600160	
DATE	
MARCH 3, 2017	
SHEET NO.	
A274	

McMAHON
ENGINEERS ARCHITECTS
1000 N. KENNAWAY, SUITE 200
APPLETON, WI 54911
Tel: (920) 751-4200 Fax: (920) 751-4284
www.mcmgnc.com

McMahon provides this drawing as an instrument of service. All rights are reserved by McMahon. The client agrees to indemnify and hold McMahon harmless from and against all claims, damages, costs and expenses, including reasonable attorney's fees, arising from or due to McMahon's negligence or the negligence of any subcontractor or supplier of McMahon.

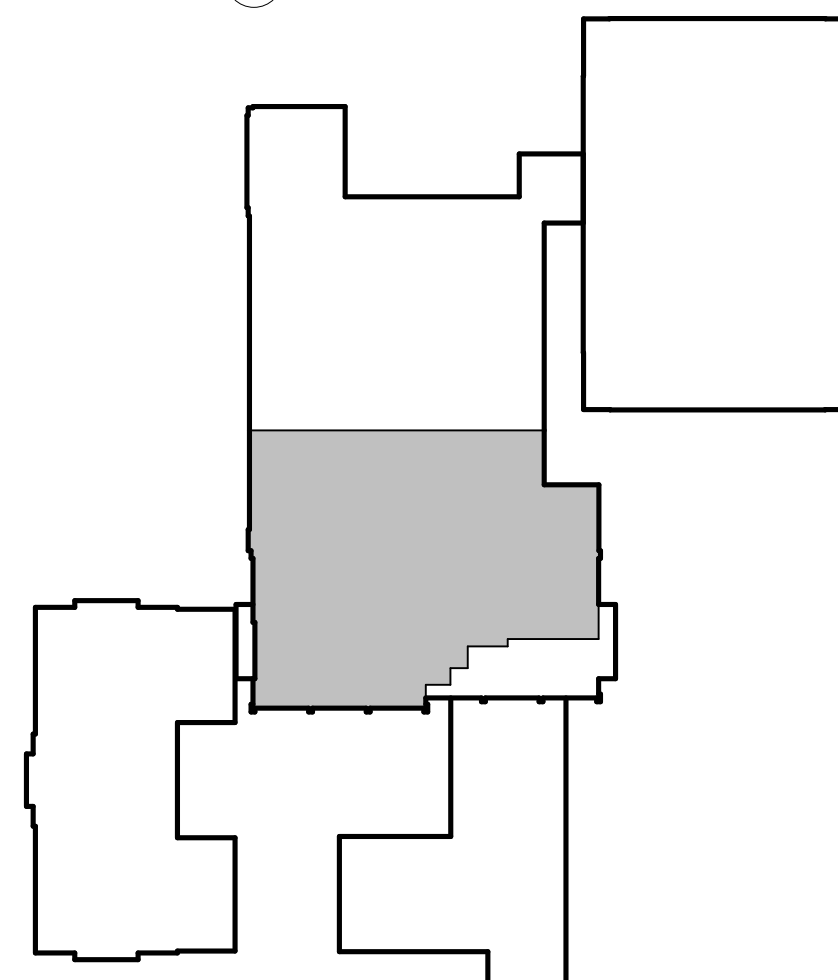

McMAHON
ENGINEERS ARCHITECTS
1445 McMAHON DRIVE NEEHAH, WI 54956
Mailing: P.O. BOX 1025 NEEHAH, WI 54957-1025
Tel: (920) 751-4200 Fax: (920) 751-4284
www.mcmgrp.com

McMahon provides this drawing and data, regardless of form, as instruments of service. All rights including copyrights are retained by McMahon. The client and/or recipient agrees to the fullest extent permitted by law to indemnify and hold McMahon harmless for any use of or changes made to the original drawing or data without prior written consent by McMahon.

--	--	--	--	--	--

[illegible]

SOUTH

ALTERATION / ADDITION
OUTAGAMIE COUNTY ADMINISTRATION CENTER
S. WALNUT & W. 8TH, APPLETON WI 54911
LEVEL 805.00 ENLARGED EQUIPMENT PLAN - HHS NORTH/OCAC

DESIGNED MAG	DRAWN BLG
PROJECT NO. O0002-61600160	
DATE MARCH 3, 2017	
CHECKED BY	

A276



EQUIPMENT SCHEDULE - SHEET A279			
MARK	DESCRIPTION	MODEL	FURNISHED BY / INSTALLED BY
A6	SOAP DISPENSER	GOJO; MODEL ADX-7	OWNER G.C.
A7	PAPER TOWEL DISPENSER	GP ENMOTION; MODEL 59462	OWNER G.C.
A14	SPECIMAN PASS-THRU	BRADLEY; MODEL 9813	G.C. G.C.
A15	COAT HOOK	BRADLEY; MODEL 9114	G.C. G.C.
A16	SHARPS CONTAINER	MARKETLAB INC.; MODEL MKA8516	OWNER G.C.
B1	REFRIGERATOR		OWNER OWNER
B2	MICROWAVE		OWNER OWNER
G3	PRINTER (LOCAL)		OWNER OWNER
G15	PRINTER	HP OFFICEJET 6100	OWNER OWNER
G20	MULTI-FUNCTION COPIER	XEROX WORKCENTRE 5135	OWNER OWNER
G21	PRINTER	HP LJ P4014N	OWNER OWNER
G22	PRINTER	HP LJ PRO 400 COLOR	OWNER OWNER
G23	PRINTER	HP LJ M402DN	OWNER OWNER
G34	MULTI-FUNCTION COPIER	XEROX WORKCENTRE 5875	OWNER OWNER
G37	PRINTER/COPPER	HP LJ PRO MFP M426FDN	OWNER OWNER
G38	LAPTOP CHARGING STATION		OWNER OWNER
G39	PRINTER/COPPER	HP LJ 4250 TN	OWNER OWNER
G40	PRINTER	HP LJ 4350 TN	OWNER OWNER
G41	MULTI-FUNCTION COPIER	XEROX WORKCENTRE 5945	OWNER OWNER
G43	OVERHEAD PROJECTOR		OWNER OWNER
G46	PROJECTOR SCREEN		OWNER OWNER
M1	MEDICAL REFRIGERATOR	ABS TEMP - TECH 200	OWNER OWNER
M2	MEDICAL FREEZER (1/2 SIZE)		OWNER OWNER
M3	INCUBATOR #1	(EXISTING)	OWNER OWNER
M4	INCUBATOR #2	(EXISTING)	OWNER OWNER
M5	AUTOCCLAVE	(EXISTING)	OWNER OWNER
M7	ANALYZER		OWNER OWNER
M8	BABY SCALE		OWNER OWNER
M9	MEASURE TABLE		OWNER OWNER
M10	HEIGHT MEASURER (WALL MOUNTED)		OWNER OWNER

McMAHON
ENGINEERS ARCHITECTS
1025 N. KENNAH AVE.
MILWAUKEE, WI 53233
Tel: (920) 751-4200 Fax: (920) 751-4284
www.mcma.com

McMahon provides this drawing as a service to the client. It is not to be used for any other purpose without the written consent of McMahon. The client is responsible for the accuracy of the information provided to McMahon. McMahon is not responsible for the accuracy of the information provided to the client.

REVISION

DATE 3/30/2017

NO. 1

ALTERATION / ADDITION
OUTAGAMIE COUNTY ADMINISTRATION CENTER
S. WALNUT & W. 8TH, APPLETON WI 54911
LEVEL 820.00 ENLARGED EQUIPMENT PLAN - HHS NORTH/OCAC SOUTH

DESIGNED MAG DRAWN BLG

PROJECT NO. 00002-61600160

DATE MARCH 3, 2017


SHEET NO.

A279

REUSE EX. CARD ACCESS

HM1 1 HM1

DOOR ELEVATIONS

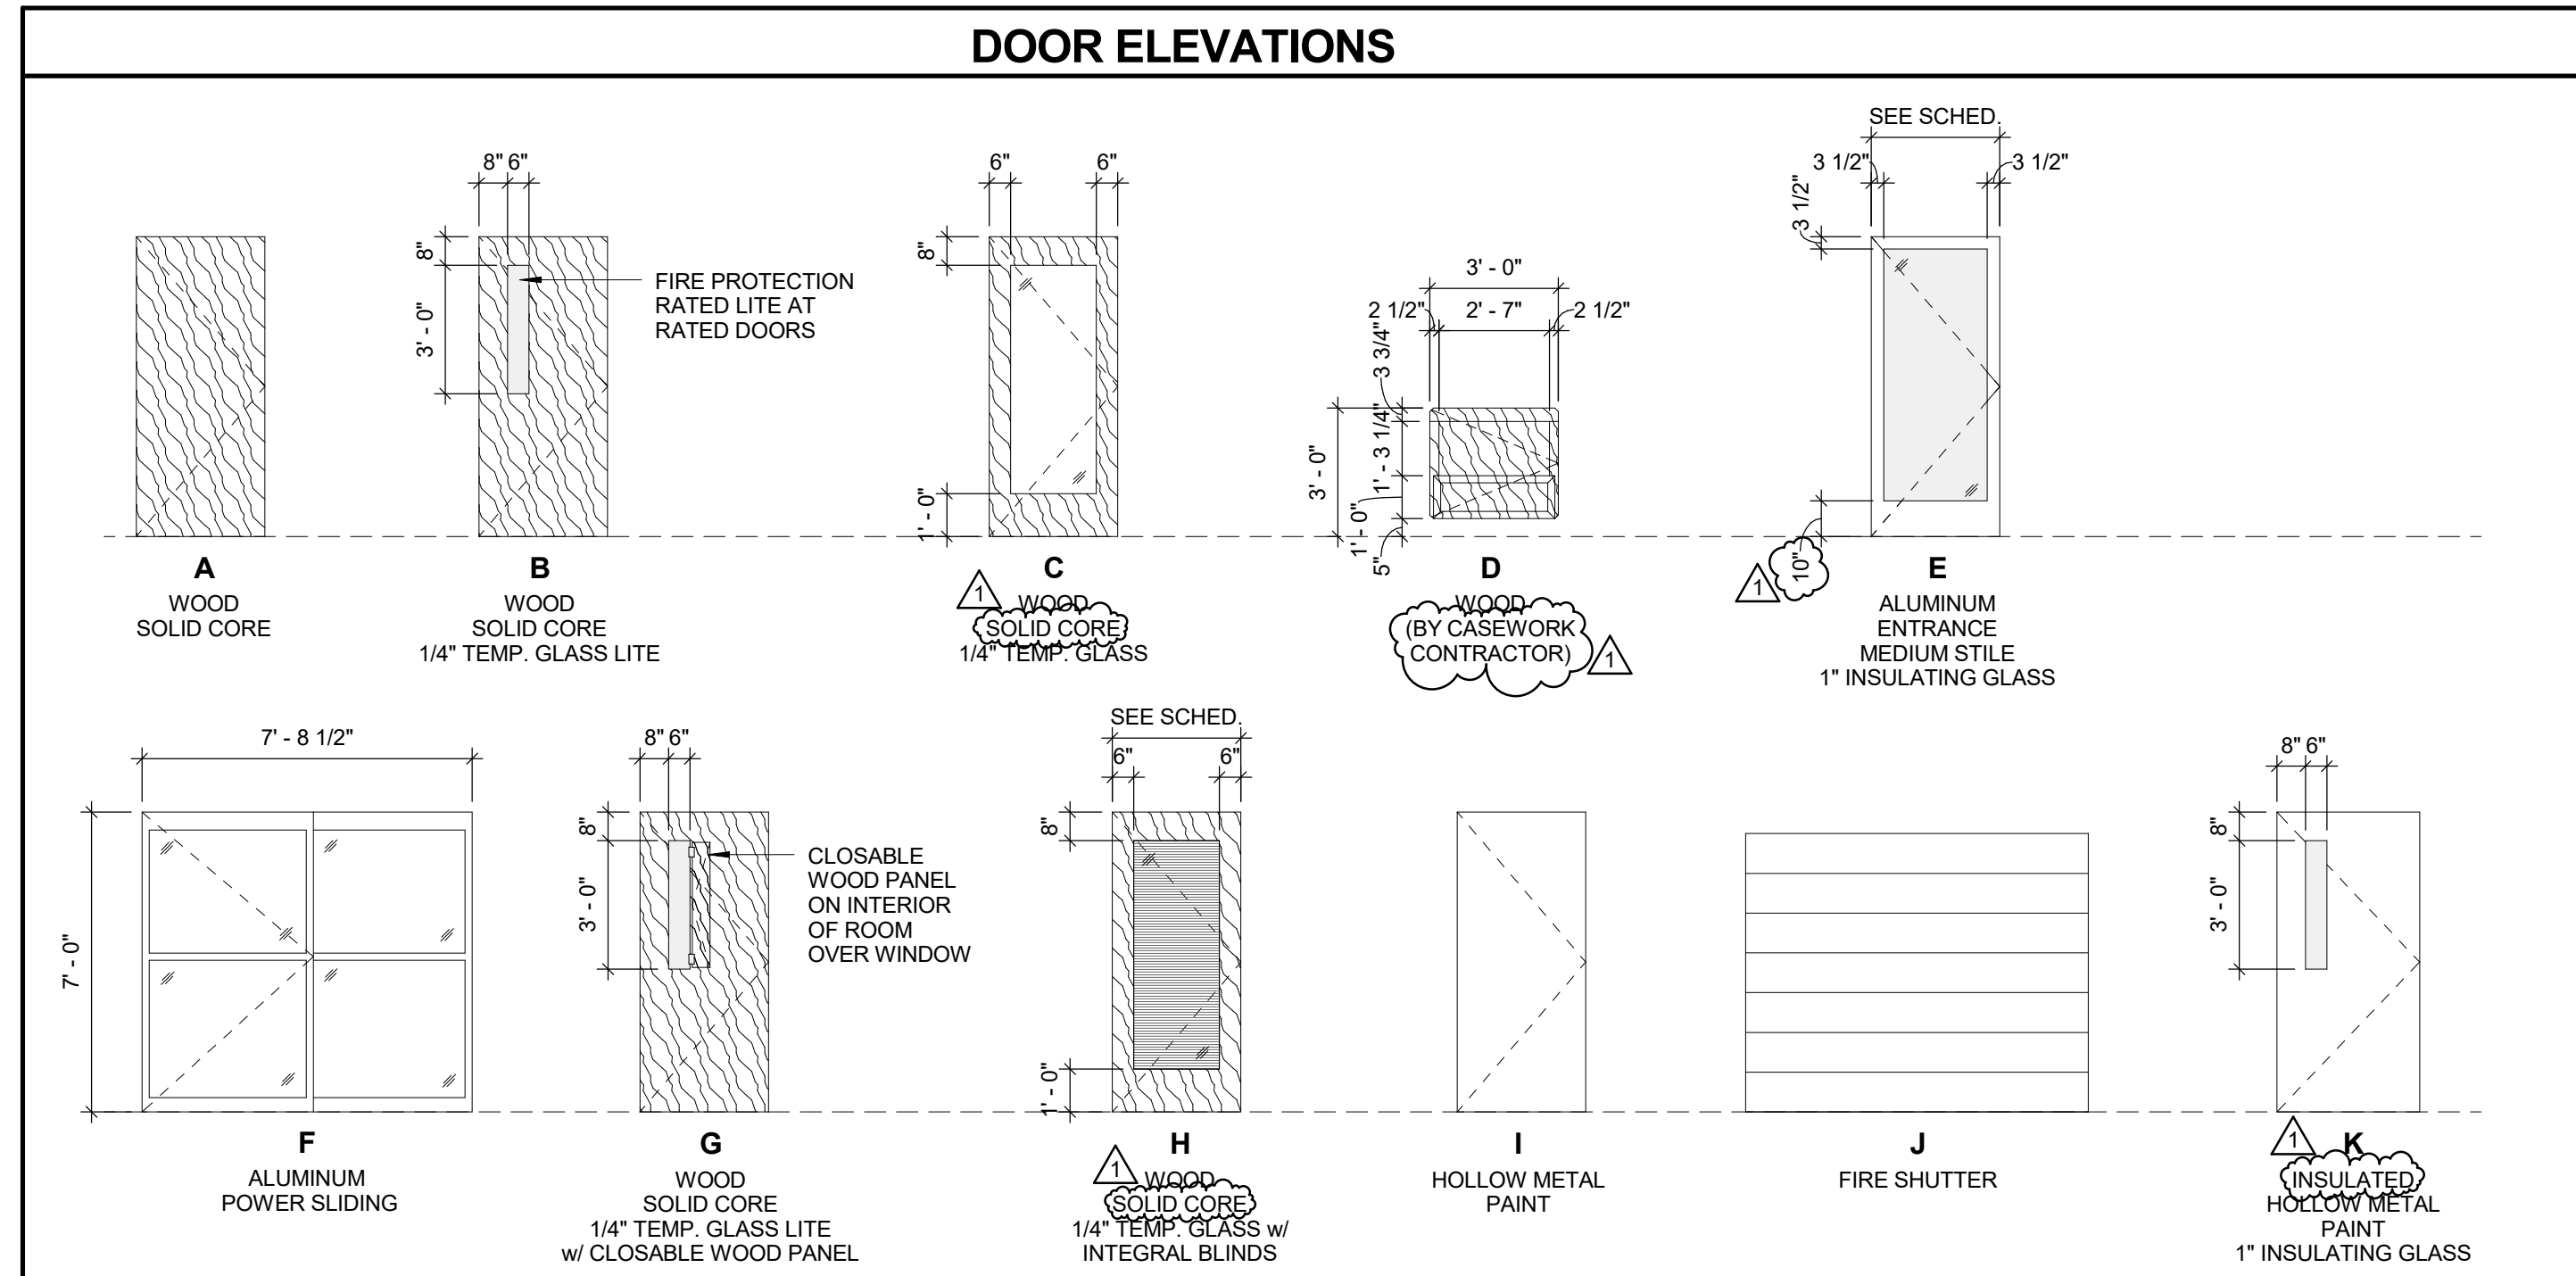

- SEE SPECIFICATIONS FOR DOOR HARDWARE DESCRIPTIONS.
- SEE STRUCTURAL FOR LINTEL SCHEDULE
- ALL BORROWED LITE AND DOOR LITE GLAZING TO BE 1/4 TEMPERED SAFETY GLASS UNLESS OTHERWISE NOTED

McMahon provides this drawing and data, regardless of form; as instruments of service. All rights including copyrights are retained by McMahon. The client and/or recipient agrees to the fullest extent permitted by law to indemnify and hold McMahon harmless for any reuse of or changes made to the original drawing or data without prior written consent by McMahon.

OPERATION / ADDITION
COUNTY ADMINISTRATION
100 W. 8TH, APPLETON
DOOR SCHEDULE


A290

DOOR SCHEDULE 2

CC	OPENING SIZE				DOOR TYPE	FRAME TYPE	FIRE RATING	DETAILS (A291)	COMMENTS
	WIDTH	HEIGHT	THICKNESS						
10.1.001A	3'-4"	7'-0"	1 3/4"		E	AL5		8.14/A296	CARD ACCESS
10.1.001B	3'-4"	7'-0"	1 3/4"		E	AL5		8.14/A296	CARD ACCESS / ADA ASSIST / POST-MOUNTED
10.1.001C	3'-4"	7'-0"	1 3/4"		E	AL5		8.14/A296	ADA ASSIST / POST-MOUNTED
10.1.001D	3'-4"	7'-0"	1 3/4"		E	AL5		8.14/A296	ADA ASSIST / POST-MOUNTED
10.1.002A	3'-4"	7'-0"	1 3/4"		E	AL5		8.14/A296	ADA ASSIST
10.1.002B	3'-4"	7'-0"	1 3/4"		E	AL5		8.14/A296	ADA ASSIST
10.1.002C	3'-4"	7'-0"	1 3/4"		E	AL5		8.14/A296	ADA ASSIST
10.1.002D	3'-4"	7'-0"	1 3/4"		E	AL5		8.14/A296	ADA ASSIST
10.1.002E	3'-4"	7'-0"	1 3/4"		E	AL5		8.14/A296	ADA ASSIST
10.1.002F	3'-4"	7'-0"	1 3/4"		E	AL5		8.14/A296	ADA ASSIST
10.1.003A	4'-0"	7'-0"	1 3/4"		F	AL4		7.8/A294	ADA ASSIST / NO HARDWARE EXIT ONLY
10.1.003B	4'-0"	7'-0"	1 3/4"		F	AL4		7.8/A294	ADA ASSIST / NO HARDWARE EXIT ONLY
10.1.004A	3'-0"	7'-0"	1 3/4"		A	HM1		7.8.32/A294	CARD ACCESS
10.1.004B	3'-0"	7'-0"	1 3/4"		A	HM1		1/A294	CARD ACCESS
10.1.005A	3'-0"	7'-0"	1 3/4"		A	HM1		7.8.32/A294	CARD ACCESS
10.1.005B	3'-0"	7'-0"	1 3/4"		A	AL1		9/A294	CARD ACCESS
10.1.006	8'-0"	8'-0"	1 3/4"		A	HM1	1 1/2 HR	10/A294	HOLD OPEN TIED TO FIRE ALARM
10.1.007	3'-4"	7'-0"	1 3/4"		A	HM1		4/A294	LOCK
10.1.008A	3'-4"	7'-0"	1 3/4"		A	HM1		1/A294	LOCK
10.1.008B	3'-4"	7'-0"	1 3/4"		A	HM1		1/A294	CARD ACCESS
10.1.009	3'-4"	7'-0"	1 3/4"		A	HM1		1/A294	
10.1.010	3'-0"	7'-0"	1 3/4"		A	HM1		1/A294	
10.1.011	3'-0"	7'-0"	1 3/4"		A	HM1		1/A294	
10.1.012	3'-0"	7'-0"	1 3/4"		A	HM1		1/A294	
10.1.013	3'-0"	7'-0"	1 3/4"		A	HM1		1/A294	
10.1.014	3'-0"	7'-0"	1 3/4"		A	HM1		1/A294	
10.1.015	3'-0"	7'-0"	1 3/4"		A	HM1		1/A294	
10.1.016	3'-0"	7'-0"	1 3/4"		A	HM1		1/A294	
10.1.017	3'-0"	7'-0"	1 3/4"		A	HM1		1/A294	LOCK
10.1.018	3'-0"	7'-0"	1 3/4"		A	HM1		1/A294	
10.1.019	3'-0"	7'-0"	1 3/4"		A	HM1		1/A294	
10.1.020	3'-0"	7'-0"	1 3/4"		A	HM1		1/A294	
10.1.021	3'-0"	7'-0"	1 3/4"		A	HM1		1/A294	
10.1.022	3'-4"	7'-0"	1 3/4"		A	HM1		1/A294	CARD ACCESS / RELEASE
10.1.023	3'-0"	7'-0"	1 3/4"		A	HM1		4/A294	CARD ACCESS
10.1.024	7'-4"	7'-0"	1 3/4"		K	HM9		12/A296	INT. CARD ACCESS / EXT. CARD ACCESS / ALARM
10.1.025	3'-0"	7'-0"	1 3/4"		A	HM1	34 HR	1/A294	LOCK
10.1.026	3'-4"	7'-0"	1 3/4"		A	HM1		1/A294	ADA ASSIST
10.1.027	3'-4"	7'-0"	1 3/4"		A	HM1		1/A294	ADA ASSIST
10.1.028A	3'-0"	7'-0"	1 3/4"		E	AL6		6.7/A296	EGRESS ONLY / ALARM IF OPENED / NO EXTERIOR HARDWARE
10.1.028B	3'-0"	7'-0"	1 3/4"		E	AL6		6.7/A296	EGRESS ONLY / ALARM IF OPENED / NO EXTERIOR HARDWARE
10.1.029	3'-4"	7'-0"	1 3/4"		A	HM1		1/A294	CLOSER / PRIVACY LOCK
10.1.030	3'-4"	7'-0"	1 3/4"		A	HM1		1/A294	LOCK
10.1.031A	3'-4"	7'-0"	1 3/4"		C	HM1		1/A294	ADA ASSIST / ADA ASSIST / FULL LITE
10.1.031B	3'-4"	7'-0"	1 3/4"		B	HM3		1/A294	CARD ACCESS / ADA ASSIST / 1/4 LITE / RELEASE
10.1.032	3'-4"	7'-0"	1 3/4"		B	HM1		1/A294	1/4 LITE
10.1.033A	3'-4"	7'-0"	1 3/4"		B	HM1		1/A294	1/4 LITE
10.1.033B	3'-4"	7'-0"	1 3/4"		B	HM1		1/A294	CARD ACCESS
10.1.034	3'-0"	7'-0"	1 3/4"		A	HM1	34 HR	1/A294	LOCK
10.1.036	3'-0"	7'-0"	1 3/4"		A	HM1		1/A294	CARD ACCESS / ACCESS TO ALTS/ADRC
10.1.039	3'-0"	7'-0"	1 3/4"		B	HM1		1/A294	1/4 LITE
10.1.040	3'-0"	7'-0"	1 3/4"		B	HM1		1/A294	1/4 LITE
10.1.041	3'-0"	7'-0"	1 3/4"		B	HM1		1/A294	
10.1.042	3'-0"	7'-0"	1 3/4"		A	HM1		1/A294	
10.1.043	3'-0"	7'-0"	1 3/4"		A	HM1		1/A294	
10.1.044	3'-0"	7'-0"	1 3/4"		A	HM1		1/A294	
10.1.045	3'-0"	7'-0"	1 3/4"		A	HM1		1/A294	
10.1.046	3'-0"	7'-0"	1 3/4"		A	HM1		1/A294	
10.1.047	3'-0"	7'-0"	1 3/4"		A	HM1		1/A294	
10.1.048	3'-0"	7'-0"	1 3/4"		A	HM1		1/A294	
10.1.049	3'-0"	7'-0"	1 3/4"		A	HM1		1/A294	
10.1.050	3'-0"	7'-0"	1 3/4"		A	HM1		1/A294	
10.1.051	3'-0"	7'-0"	1 3/4"		B	HM1		1/A294	1/4 LITE
10.1.052	3'-0"	7'-0"	1 3/4"		B	HM1		1/A294	1/4 LITE
10.1.053	3'-4"	7'-0"	1 3/4"		B	HM1		1/A294	1/4 LITE
10.1.054	3'-0"	7'-0"	1 3/4"		A	HM1		1/A294	CARD ACCESS
10.1.055	3'-4"	7'-0"	1 3/4"		A	HM1		1/A294	
10.1.056	3'-4"	7'-0"	1 3/4"		B	HM1		1/A294	1/4 LITE
10.1.058	3'-0"	7'-0"	1 3/4"		A	HM1		1/A294	
10.1.059	3'-0"	7'-0"	1 3/4"		B	HM1		1/A294	1/4 LITE
10.1.062	3'-0"	7'-0"	1 3/4"		A	HM1		1/A294	LOCK
10.1.063	3'-0"	7'-0"	1 3/4"		A	HM1		1/A294	
10.1.064	3'-0"	7'-0"	1 3/4"		A	HM1		1/A294	
10.1.065	3'-0"	7'-0"	1 3/4"		A	HM1		1/A294	
10.1.066	3'-0"	7'-0"	1 3/4"		A	HM1		1/A294	
10.1.067	3'-0"	7'-0"	1 3/4"		A	HM1		1/A294	
10.1.068	3'-0"	7'-0"	1 3/4"		A	HM1		1/A294	
10.1.069	3'-0"	7'-0"	1 3/4"		A	HM1		1/A294	
10.1.070	3'-0"	7'-0"	1 3/4"		A	HM1		1/A294	
10.1.071	3'-0"	7'-0"	1 3/4"		A	HM1		1/A294	
10.1.072	3'-0"	7'-0"	1 3/4"		A	HM1		1/A294	
10.1.073	3'-0"	7'-0"	1 3/4"		A	HM1		1/A294	LOCK
10.1.074	3'-4"	7'-0"	1 3/4"		B	HM1		1/A294	1/4 LITE
10.1.076	3'-0"	7'-0"	1 3/4"		A	HM1		1/A294	LOCK
10.1.077	3'-0"	7'-0"	1 3/4"		A	HM1		1/A294	LOCK
10.1.078A	3'-4"	7'-0"	1 3/4"		C	HM3		1/A294	ADA ASSIST / CARD ACCESS / FULL LITE
10.1.078B	3'-0"	7'-0"	1 3/4"		A	HM1		1/A294	CARD ACCESS / RELEASE
10.1.078C	3'-4"	7'-0"	1 3/4"		A	HM1		1/A294	CARD ACCESS / RELEASE
10.1.078D	3'-4"	7'-0"	1 3/4"		A	HM1		1/A294	CARD ACCESS / RELEASE
10.1.079	3'-4"	7'-0"	1 3/4"		C	HM5		1/A294	FULL LITE / KEY
10.1.080	3'-4"	7'-0"	1 3/4"		C	HM5		1/A294	FULL LITE / KEY
10.1.082	3'-4"	7'-0"	1 3/4"		C	HM5		1/A294	FULL LITE / KEY
10.1.083	3'-4"	7'-0"	1 3/4"		C	HM5		1/A294	FULL LITE / KEY
10.1.084	3'-4"	7'-0"	1 3/4"		C	HM1		1/A294	FULL LITE / KEY
10.1.087	3'-0"	7'-0"	1 3/4"		A	HM1		1/A294	
10.1.088	3'-0"	7'-0"	1 3/4"		A	HM1		1/A294	
10.1.089	3'-0"	7'-0"	1 3/4"		A	HM1		1/A294	
10.1.090	3'-0"	7'-0"	1 3/4"		A	HM1		1/A294	
10.1.091	3'-0"	7'-0"	1 3/4"		A	HM1		1/A294	
10.1.092	3'-0"	7'-0"	1 3/4"		A	HM1		1/A294	
10.1.093	3'-0"	7'-0"	1 3/4"		A	HM1		1/A294	
10.1.094	3'-0"	7'-0"	1 3/4"		A	HM1		1/A294	
10.1.095	3'-0"	7'-0"	1 3/4"		A	HM1		1/A294	
10.1.096	3'-0"	7'-0"	1 3/4"		A	HM1		1/A294	
10.1.097	3'-0"	7'-0"	1 3/4"		A	HM1		1/A294	
10.1.099	3'-0"	7'-0"	1 3/4"		A	HM1		1/A294	
10.1.100	3'-0"	7'-0"	1 3/4"		A	HM1		1/A294	
10.1.101	3'-0"	7'-0"	1 3/4"		A	HM1		1/A294	
10.1.102	3'-0"	7'-0"	1 3/4"		A	HM1		1/A294	
10.1.103	3'-0"	7'-0"	1 3/4"		A	HM1		1/A294	
10.1.104	3'-0"	7'-0"	1 3/4"		A	HM1		1/A294	
10.1.106	3'-0"	7'-0"	1 3/4"		A	HM1		1/A294	
10.1.107	3'-0"	7'-0"	1 3/4"		A	HM1		1/A294	
10.1.108	3'-0"	7'-0"	1 3/4"		A	HM1		1/A294	
10.1.109	3'-0"	7'-0"	1 3/4"		A	HM1		1/A294	
10.1.112	3'-0"	7'-0"	1 3/4"		A	HM1		1/A294	
10.1.113	3'-0"	7'-0"	1 3/4"		A	HM1		1/A294	
10.1.114	3'-0"	7'-0"	1 3/4"		A	HM1		1/A294	
10.1.115	3'-0"	7'-0"	1 3/4"		A	HM1		1/A294	
10.1.116	3'-0"	7'-0"	1 3/4"		A	HM1		1/A294	
10.1.117	3'-0"	7'-0"	1 3/4"		A	HM1		1/A294	
10.1.118	3'-0"	7'-0"	1 3/4"		A	HM1		1/A294	
10.1.119	3'-0"	7'-0"	1 3/4"		A	HM1		1/A294	
10.1.120	3'-0"	7'-0"	1 3/4"		A	HM1		1/A294	
10.1.121	3'-0"	7'-0"	1 3/4"		A	HM1		1/A294	
10.1.122	3'-0"	7'-0"	1 3/4"		A	HM1		1/A294	
10.1.123	3'-0"	7'-0"	1 3/4"		A	HM1		1/A294	
10.1.124	3'-0"	7'-0"	1 3/4"		A	HM1		1/A294	
10.1.125	3'-0"	7'-0"	1 3/4"		A	HM1		1/A294	
10.1.126	3'-0"	7'-0"	1 3/4"		A	HM1		1/A294	
10.1.128	3'-0"	7'-0"	1 3/4"		A	HM1		1/A294	
10.1.131	3'-0"	7'-0"	1 3/4"		A	HM1		1/A294	
10.1.132	3'-0"	7'-0"	1 3/4"		A	HM1		1/A294	
10.1.133	3'-0"	7'-0"	1 3/4"		A	HM1		1/A294	
10.1.134	3'-0"	7'-0"	1 3/4"		A	HM1		1/A294	
10.1.135	3'-0"	7'-0"	1 3/4"		A	HM1		1/A294	
10.1.136	3'-0"	7'-0"	1 3/4"		A	HM1		1/A294	
10.1.137	3'-0"	7'-0"	1 3/4"		A	HM1		1/A294	
10.1.138	3'-0"	7'-0"	1 3/4"		A	HM1		1/A294	
10.1.140	4'-0"	7'-0"	1 3/4"		A	HM1		1/A294	LOCK
10.1.141	3'-0"	7'-0"	1 3/4"		A	HM1		1/A294	
10.1.143	3'-0"	7'-0"	1 3/4"		A	HM1		1/A294	
10.1.144	3'-0"	7'-0"	1 3/4"		A	HM1		1/A294	

DOOR SCHEDULE 2

OPENING SIZE										DOOR TYPE	FRAME TYPE	FIRE RATING	DETAILS	LOCK	COMMENTS
CC	WIDTH	DOOR HEIGHT	THICKNESS												
10.1.145A	3'-8"	8'-0"	1 3/4"	A	HM1		1/A294	LOCK							
10.1.145B	3'-8"	7'-0"	1 3/4"	A	HM1		1/A294	PANIC HARDWARE							
10.1.160	3'-4"	7'-0"	1 3/4"	C	HM1		1/A294	FULL LITE / KEY							
10.1.164	3'-4"	7'-0"	1 3/4"	C	HM1		1/A294	FULL LITE / KEY							
10.1.166	3'-4"	7'-0"	1 3/4"	A	HM1		1/A294	LOCK							
10.1.52A	3'-4"	7'-0"	1 3/4"	B	HM1	1 1/2 HR	3/A294	1/4 LITE							
10.1.52B	3'-4"	7'-0"	1 3/4"	K	HM1		13 A296	NO HARDWARE EXIT ONLY / ALARM							
10.2.001	3'-8"	8'-0"	1 3/4"	A	HM1		4/A294	HOLD OPEN TIED TO FIRE ALARM							
10.2.002	3'-4"	7'-0"	1 3/4"	C	HM1		16.17/A294	CARD ACCESS							
10.2.003	3'-4"	7'-0"	1 3/4"	A	HM1	1 1/2 HR	1/A294	LOCK							
10.2.004A	3'-4"	7'-0"	1 3/4"	A	HM1		1/A294	LOCK / BOTTOM DROP							
10.2.004B	3'-4"	7'-0"	1 3/4"	A	HM1		1/A294	LOCK / BOTTOM DROP							
10.2.004D	3'-4"	7'-0"	1 3/4"	A	HM1		1/A294	BOTTOM DROP							
10.2.004E	3'-4"	7'-0"	1 3/4"	A	HM1		1/A294	BOTTOM DROP							
10.2.004F	33'-6"	9'-0"					1/A294	FOLDING PARTITION; MIN. 50 STC							
10.2.004G	23'-9 3/4"	9'-0"					5/A294	FOLDING PARTITION; MIN. 50 STC							
10.2.004H	33'-6"	9'-0"					5/A294	FOLDING PARTITION; MIN. 50 STC							
10.2.004I	23'-11 3/8"	9'-0"					5/A294	FOLDING PARTITION; MIN. 50 STC							
10.2.005A	3'-0"	7'-0"	1 3/4"	A	HM1		1/A294	LOCK							
10.2.005B	3'-4"	7'-0"	1 3/4"	A	HM1		1/A294	LOCK							
10.2.005C	3'-4"	7'-0"	1 3/4"	A	HM1		1/A294	LOCK / NO CLOSER							
10.2.005D	3'-4"	7'-0"	1 3/4"	A	HM1		1/A294	LOCK / NO CLOSER							
10.2.007A	3'-4"	7'-0"	1 3/4"	B	HM1		1/A294	CARD ACCESS / 1/4 LITE							
10.2.007B	3'-0"	7'-0"	1 3/4"	A	HM1		1/A294	LOCK							
10.2.008	3'-4"	7'-0"	1 3/4"	B	HM1		1/A294	1/4 LITE							
10.2.009	3'-4"	7'-0"	1 3/4"	B	HM1		1/A294	1/4 LITE							
10.2.010A	3'-4"	7'-0"	1 3/4"	G	HM1		1,26.27/A29	ADA ASSIST / 1/4 LITE w/ SHUTTER / LOCK							
10.2.010B	3'-0"	7'-0"	1 3/4"	A	HM1		1/A294	CARD ACCESS							
10.2.010C	3'-0"	7'-0"	1 3/4"	A	HM1		1/A294	CARD ACCESS							
10.2.011	3'-0"	7'-0"	1 3/4"	A	HM1		1/A294	LOCK							
10.2.012	3'-0"	7'-0"	1 3/4"	A	HM1	3/4 HR	1/A294	LOCK							
10.2.013	3'-0"	7'-0"	1 3/4"	A	HM1	34 HR	1/A294	KEY							
10.2.014	3'-0"	7'-0"	1 3/4"	A	HM1		1/A294	ADA ASSIST							
10.2.015	3'-0"	7'-0"	1 3/4"	A	HM1		1/A294	ADA ASSIST							
10.2.016	3'-4"	7'-0"	1 3/4"	A	HM1		1/A294	CLOSER / PRIVACY LOCK							
10.2.017	3'-4"	7'-0"	1 3/4"	A	HM1		1/A294	LOCK							
10.2.018A	3'-4"	7'-0"	1 3/4"	C	HM6		1/A294	FULL LITE / LOCK / ADA ASSIST							
							1/A395								
10.2.018B	3'-0"	7'-0"	1 3/4"	A	HM1		1/A294	CARD ACCESS							
10.2.019	3'-4"	7'-0"	1 3/4"	B	HM1		1/A294	1/4 LITE							
10.2.020	3'-4"	7'-0"	1 3/4"	B	HM1		1/A294	1/4 LITE							
10.2.021	3'-4"	7'-0"	1 3/4"	G	HM1		1,26.27/A29	ADA ASSIST / 1/4 LITE w/ SHUTTER / LOCK							
10.2.022	3'-0"	7'-0"	1 3/4"	A	HM1		1/A294	CARD ACCESS							
10.2.023A	3'-4"	7'-0"	1 3/4"	G	HM1		1,26.27/A29	ADA ASSIST / 1/4 LITE w/ SHUTTER / LOCK							
							4								
10.2.023B	3'-0"	7'-0"	1 3/4"	A	HM1		1/A294	CARD ACCESS							
10.2.024A	3'-0"	7'-0"	1 3/4"	A	HM1		1/A294	LOCK							
10.2.024B	3'-0"	7'-0"	1 3/4"	A	HM1		1/A294	CARD ACCESS							
10.2.026A	3'-0"	7'-0"	1 3/4"	A	HM1		1/A294	CARD ACCESS							
10.2.026B	3'-0"	7'-0"	1 3/4"	A	HM1		1/A294	LOCK							
10.2.028	3'-0"	7'-0"	1 3/4"	A	HM1		1/A294	LOCK							
10.2.029	3'-0"	7'-0"	1 3/4"	B	HM1		1/A294	CARD ACCESS / 1/4 LITE							
10.2.030	3'-0"	7'-0"	1 3/4"	A	HM1		22/A294	PUSH/PULL / HOLD OPEN							
10.2.031A	3'-4"	7'-0"	1 3/4"	C	HM1		1/A294	FULL LITE / LOCK / ADA ASSIST							
10.2.031B	3'-4"	7'-0"	1 3/4"	A	HM1		1/A294	CARD ACCESS							
10.2.033A	3'-4"	7'-0"	1 3/4"	B	HM1		1/A294	ADA ASSIST / 1/4 LITE / LOCK							
10.2.033B	3'-4"	7'-0"	1 3/4"	A	HM1		1/A294	CARD ACCESS							
10.2.034	3'-0"	7'-0"	1 3/4"	A	HM1		1/A294	CARD ACCESS							
10.2.035	3'-4"	7'-0"	1 3/4"	A	HM1		1/A294	LOCK							
10.2.036	3'-0"	7'-0"	1 3/4"	A	HM1		23/A294	PUSH/PULL / HOLD OPEN							
10.2.037	3'-0"	7'-0"	1 3/4"	A	HM1		1/A294								
10.2.038	3'-4"	7'-0"	1 3/4"	B	HM1		1/A294	ADA ASSIST / KEY LOCK / 1/4 LITE							
10.2.040A	3'-4"	7'-0"	1 3/4"	A	HM1		1/A294	LOCK FROM WAITING & ALWAYS OPEN FROM INSIDE							
10.2.040B	3'-0"	7'-0"	1 3/4"	A	HM1		1/A294	LOCK FROM WAITING & ALWAYS OPEN FROM INSIDE							
10.2.041A	3'-4"	7'-0"	1 3/4"	B	HM1		1/A294	KEY LOCK - ALWAYS OPEN FROM FILE SIDE							
10.2.041B	3'-0"	7'-0"	1 3/4"	B	HM1		1/A294	LOCK							
10.2.042A	3'-4"	7'-0"	1 3/4"	A	HM1		1/A294	LOCK FROM WAITING & ALWAYS OPEN FROM INSIDE							
10.2.042B	3'-0"	7'-0"	1 3/4"	A	HM1		1/A294	CARD ACCESS							
10.2.044A	3'-4"	7'-0"	1 3/4"	A	HM1		1/A294	LOCK FROM WAITING & ALWAYS OPEN FROM INSIDE							
10.2.044B	3'-4"	7'-0"	1 3/4"	A	HM1		1/A294	CARD ACCESS							
10.2.045	3'-4"	7'-0"	1 3/4"	B	HM1		1/A294	CARD ACCESS / 1/4 LITE							
10.2.046	3'-4"	7'-0"	1 3/4"	A	HM1		1/A294	CARD ACCESS							
10.2.047	3'-0"	7'-0"	1 3/4"	A	HM1		1/A294								
10.2.048	3'-0"	7'-0"	1 3/4"	A	HM1		1/A294								
10.2.049	3'-0"	7'-0"	1 3/4"	A	HM1		1/A294								
10.2.050	3'-0"	7'-0"	1 3/4"	A	HM1		1/A294								
10.2.051	3'-0"	7'-0"	1 3/4"	A	HM1		1/A294								
10.2.052	3'-0"	7'-0"	1 3/4"	A	HM1		1/A294								
10.2.054	3'-4"	7'-0"	1 3/4"	A	HM1		1/A294								
10.2.057A	3'-4"	7'-0"	1 3/4"	A	HM1		1/A294								
10.2.057B	3'-4"	7'-0"	1 3/4"	A	HM1		1/A294	LOCK / NO HARDWARE / DROP BOTTOM							
10.2.058	3'-4"	7'-0"	1 3/4"	A	HM1		1/A294								
10.2.059	3'-4"	7'-0"	1 3/4"	A	HM1		1/A294								
10.2.060	3'-4"	7'-0"	1 3/4"	A	HM1		1/A294								
10.2.061	3'-4"	7'-0"	1 3/4"	A	HM1		1/A294								
10.2.062	3'-4"	7'-0"	1 3/4"	A	HM1		1/A294								
10.2.063	3'-0"	7'-0"	1 3/4"	A	HM1		1/A294								
10.2.064A	3'-4"	7'-0"	1 3/4"	A	HM1		1/A294								
10.2.064B	3'-4"	7'-0"	1 3/4"	A	HM1		1/A294	CARD ACCESS							
10.2.065	3'-4"	7'-0"	1 3/4"	A	HM1		1/A294								
10.2.066	3'-4"	7'-0"	1 3/4"	A	HM1		1/A294								
10.2.067	3'-0"	7'-0"	1 3/4"	A	HM1		1/A294								
10.2.068	3'-4"	7'-0"	1 3/4"	B	HM1		1/A294	CARD ACCESS / 1/4 LITE / DELAYED EGRESS							
10.2.069	3'-0"	7'-0"	1 3/4"	A	HM1		1/A294								
10.2.071	3'-0"	7'-0"	1 3/4"	A	HM1		1/A294	CARD ACCESS							
10.2.072	3'-0"	7'-0"	1 3/4"	A	HM1		1/A294								
10.2.073	3'-0"	7'-0"	1 3/4"	A	HM1		1/A294								
10.2.074	3'-0"	7'-0"	1 3/4"	A	HM1		1/A294								
10.2.075	3'-0"	7'-0"	1 3/4"	A	HM1		1/A294								
10.2.076	3'-0"	7'-0"	1 3/4"	A	HM1		1/A294								
10.2.077	3'-0"	7'-0"	1 3/4"	A	HM1		1/A294								
10.2.078	3'-0"	7'-0"	1 3/4"	A	HM1		1/A294								
10.2.079	3'-0"	7'-0"	1 3/4"	A	HM1		1/A294								
10.2.080	3'-0"	7'-0"	1 3/4"	A	HM1		1/A294								
10.2.081	3'-0"	7'-0"	1 3/4"	A	HM1		1/A294								
10.2.082	3'-4"	7'-0"	1 3/4"	A	HM1		1/A294								
10.2.083	3'-0"	7'-0"	1 3/4"	A	HM1		1/A294								
10.2.084	3'-8"	8'-0"	1 3/4"	A	HM1	1 HR	1/A294	LOCK							
10.2.085	3'-0"	7'-0"	1 3/4"	A	HM1		1/A294								
10.2.52	3'-4"	7'-0"	1 3/4"	A	HM1	1 HR	2/A294								
10.3.002A	7'-0"	7'-0"	1 3/4"	A	HM1		1/A294	CARD ACCESS							
10.3.002B	3'-4"	7'-0"	1 3/4"	A	HM1		1/A294	CARD ACCESS							
10.3.003	3'-0"	7'-0"	1 3/4"	A	HM1	3/4 HR	1/A294	LOCK							
10.3.004	3'-0"	7'-0"	1 3/4"	A	HM1	3/4 HR	1/A294	LOCK							
10.3.005	3'-0"	7'-0"	1 3/4"	A	HM1		1/A294	CARD ACCESS							
10.3.006	3'-0"	7'-0"	1 3/4"	A	HM1		1/A294	ADA ASSIST							
10.3.007	3'-4"	7'-0"	1 3/4"	A	HM1		1/A294	CLOSER / PRIVACY LOCK							
10.3.008	3'-4"	7'-0"	1 3/4"	A	HM1		1/A294	LOCK							
10.3.010A	3'-4"	7'-0"	1 3/4"	A	HM1		1/A294	ADA ASSIST / LOCK							
10.3.010B	3'-4"	7'-0"	1 3/4"	A	HM1		1/A294	CARD ACCESS / RELEASE							
10.3.010C	3'-4"	7'-0"	1 3/4"	A	HM1		1/A294	CARD ACCESS / RELEASE							
10.3.013	3'-0"	7'-0"	1 3/4"	A	HM1		1/A294								
10.3.014	3'-0"	7'-0"	1 3/4"	A	HM1		1/A294								
10.3.015	3'-0"	7'-0"	1 3/4"	A	HM1		1/A294								
10.3.016	3'-0"	7'-0"	1 3/4"	A	HM1		1/A294								
10.3.017	3'-0"	7'-0"	1 3/4"	A	HM1		1/A294								
10.3.019	3'-0"	7'-0"	1 3/4"	A	HM1		1/A294								
10.3.020	3'-0"	7'-0"	1 3/4"	A	HM1		1/A294								
10.3.021	3'-0"	7'-0"	1 3/4"	A	HM1		1/A294								
10.3.023	3'-0"	7'-0"	1 3/4"	A	HM1		1/A294								
10.3.024	3'-0"	7'-0"	1 3/4"	A	HM1		1/A294	PRIVACY LOCK							
10.3.025	3'-0"	7'-0"	1 3/4"	A	HM1		1/A294								
10.3.026A	3'-0"	7'-0"	1 3/4"	A	HM1		1/A294								
10.3.026B	3'-4"	7'-0"	1 3/4"	A	HM1		1/A294								
10.3.027	3'-0"	7'-0"	1 3/4"	A	HM1		1/A294	CARD ACCESS / DELAYED EGRESS							
10.3.028	3'-0"	7'-0"	1 3/4"	A	HM1		22/A294	PUSH/PULL / HOLD OPEN							
10.3.029	3'-0"	7'-0"	1 3/4"	A	HM1		1/A294	CARD ACCESS							
10.3.030	3'-0"	7'-0"	1 3/4"	A	HM1		1/A294								
10.3.031	3'-0"	7'-0"	1 3/4"	A	HM1		1/A294								
10.3.032	3'-0"	7'-0"	1 3/4"	A	HM1		1/A294								
10.3.033A	3'-4"	7'-0"	1 3/4"	A	HM1		1/A294								
10.3.033B	3'-4"	7'-0"	1 3/4"	A	HM1		1/A294								
10.3.034	3'-0"	7'-0"	1 3/4"	A	HM1		1/A294								
10.3.035	3'-0"	7'-0"	1 3/4"	A	HM1		1/A294								
10.3.036	3'-0"	7'-0"	1 3/4"	A	HM1		1/A294								
10.3.037	3'-0"	7'-0"	1 3/4"	A	HM1		1/A294								
10.3.038	3'-0"	7'-0"	1 3/4"	A	HM1		1/A294								
10.3.039	3'-0"	7'-0"	1 3/4"	A	HM1		1/A294								
10.3.040	3'-0"	7'-0"	1 3/4"	A	HM1		1/A294								

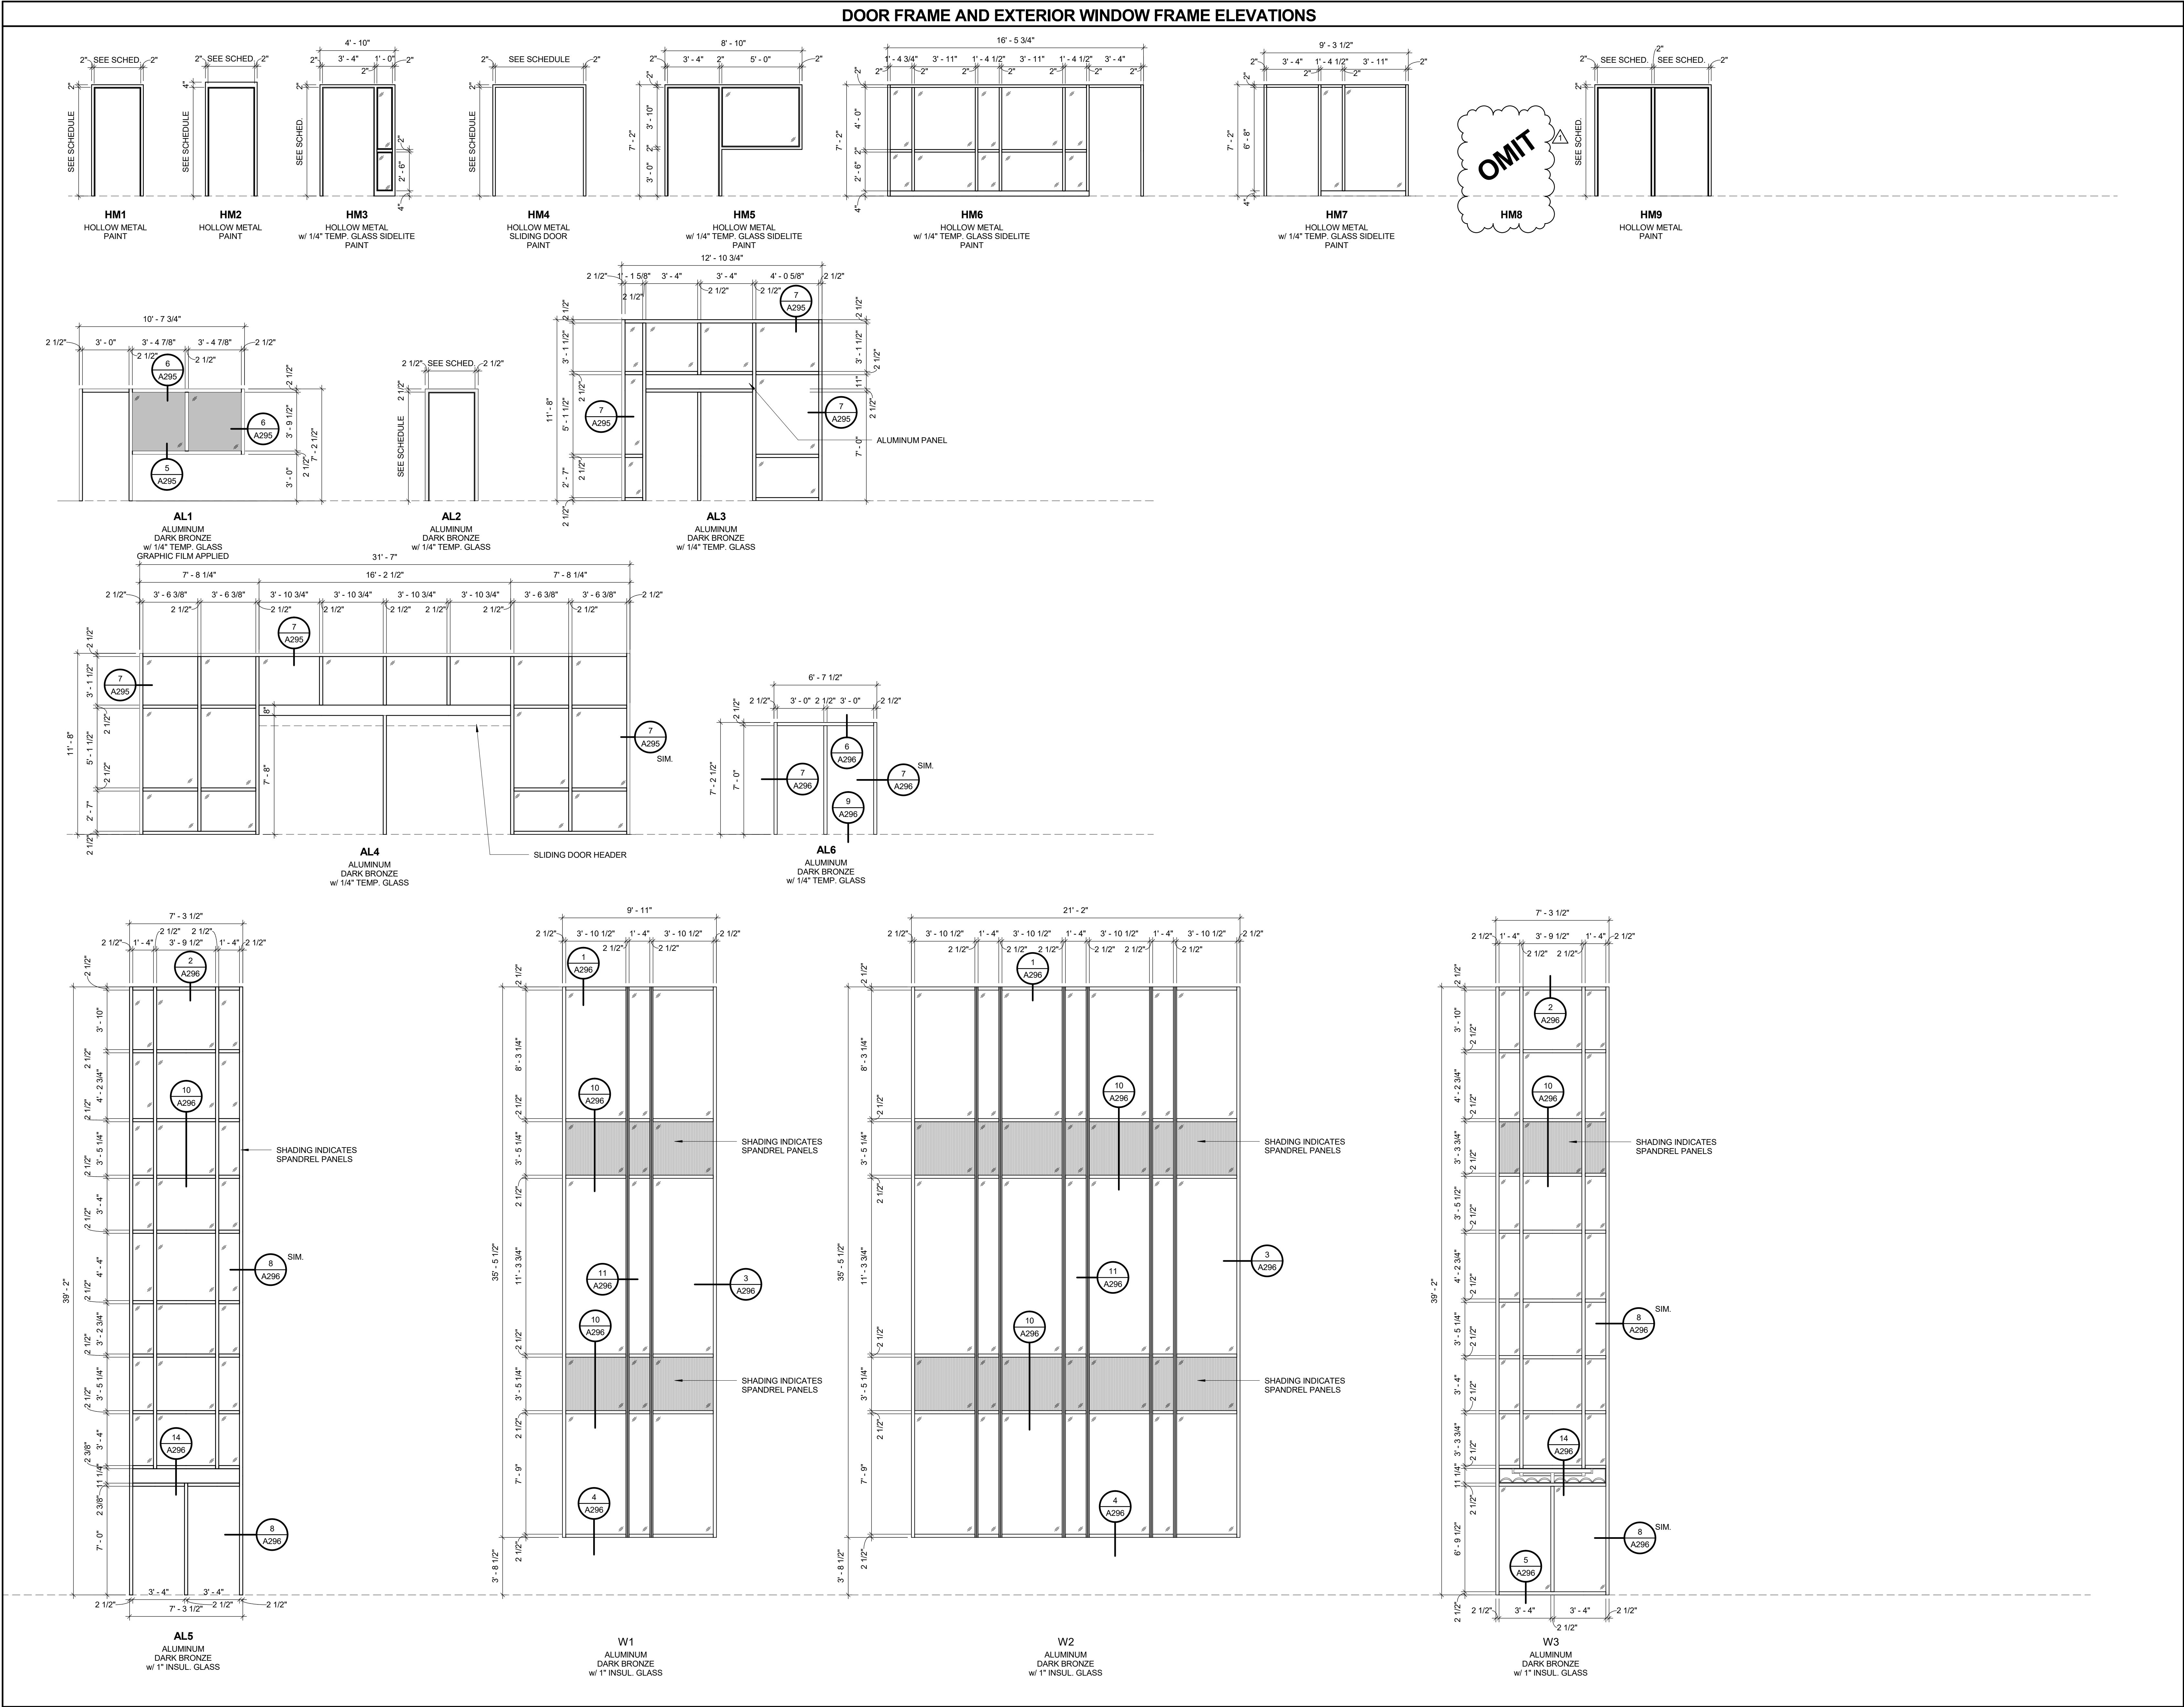

ALTERATION / ADDITION
OUTAGAME COUNTY ADMINISTRATION CENTER
S. WALNUT & W. 8TH, APPLETON WI 54911
DOOR FRAME AND EXTERIOR WINDOW ELEVATIONS


DESIGNED	DRAWN
ASF/MAG	BLG
PROJECT NO.	
00002-61600160	
DATE	
MARCH 3, 2017	
SHEET NO.	

A292

McMahon provides this drawing as an instrument of service. All rights are reserved by McMahon. The client agrees to indemnify and hold McMahon harmless from and against all claims, damages, costs and expenses, including reasonable attorneys' fees, arising out of or from the use of this drawing, whether or not caused in whole or in part by McMahon's negligence. McMahon's liability shall be limited to the original charges made to the original client for the preparation of this drawing.

McMAHON
ENGINEERS ARCHITECTS
McMahon Engineering Architects
Maine P.O. BOX 1025 NEWBATH, VT 54957-1025
Tel: (820) 751-4200 Fax: (820) 751-4284
www.mcmgr.com

NO.	DATE	REVISION
1	3/3/2017	ADDENDUM 1

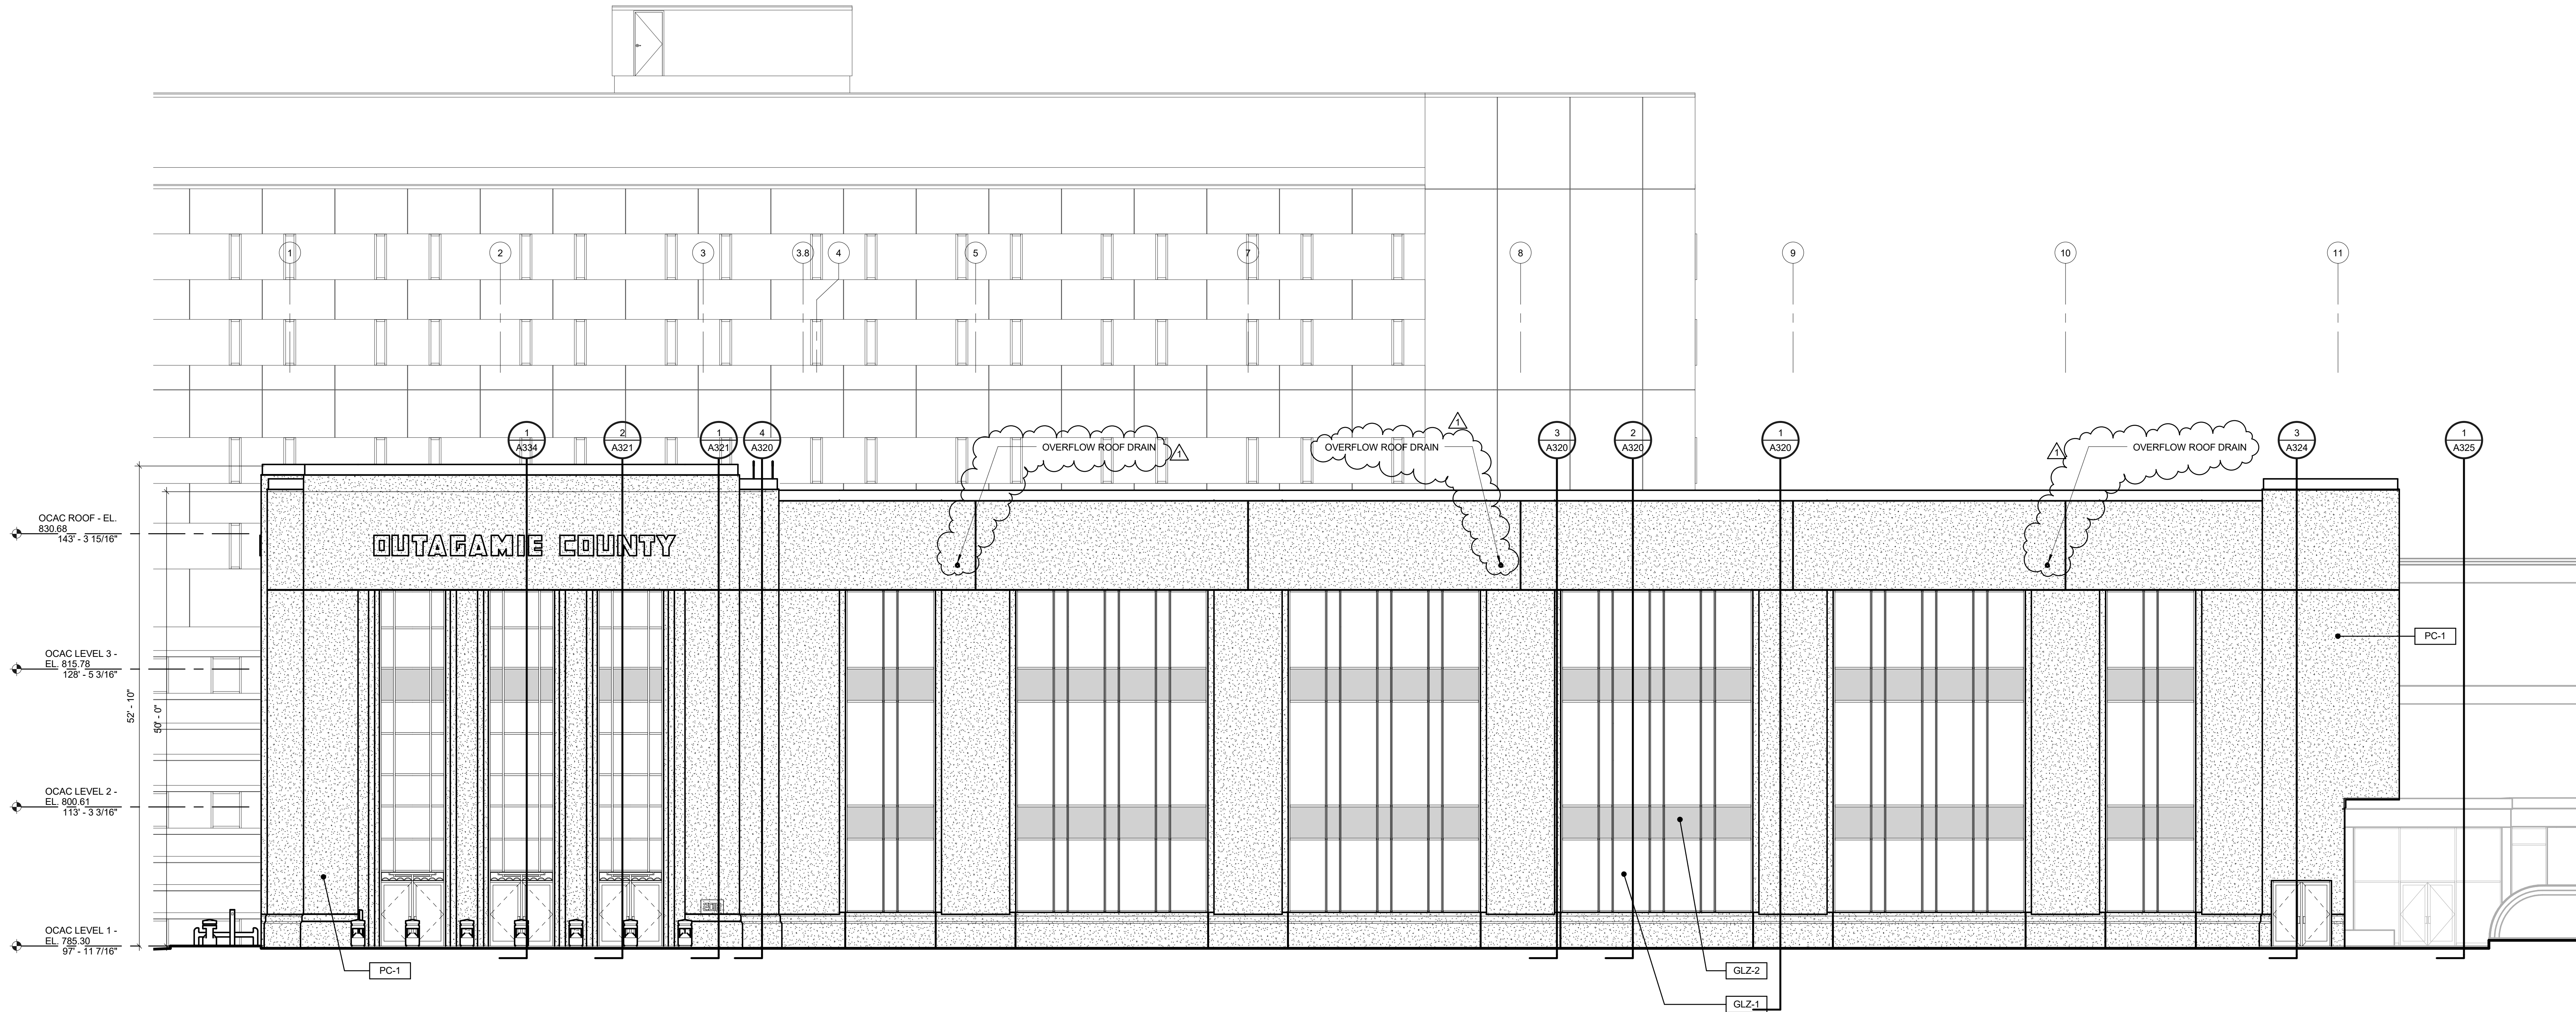

1 WEST ELEVATION
A391 1/8" = 1'-0"

EXTERIOR MATERIALS LEGEND	
GLZ-1	GLASS
GLZ-2	GLASS SPANDREL
PC-1	PRECAST CONCRETE, SAND BLAST FINISH, COLOR TO MATCH COUNTY ADMINISTRATION BLDG.

ALTERATION / ADDITION
OUTAGAMIE COUNTY ADMINISTRATION CENTER
S. WALNUT & W. 8TH, APPLETON WI 54911
EXTERIOR ELEVATIONS


DESIGNED	DRAWN
ASF	BLG
PROJECT NO. 00002-61600160	
DATE MARCH 3, 2017	
SHEET NO.	

A391

McMahon provides this drawing as an instrument of service. All rights are reserved by McMahon. The client agrees to indemnify and hold McMahon harmless from and against all claims, damages, costs and expenses, including reasonable attorney's fees, arising out of or from the use of this drawing, whether or not caused in whole or in part by McMahon's negligence. No warranty is made by McMahon for the original design or for the reproduction of the drawing.

McMAHON
ENGINEERS ARCHITECTS
McMahon P.O. BOX 1025 NEENAH, WI 54957-1025
Tel: (920) 751-4200 Fax: (920) 751-4284
www.mcngro.com




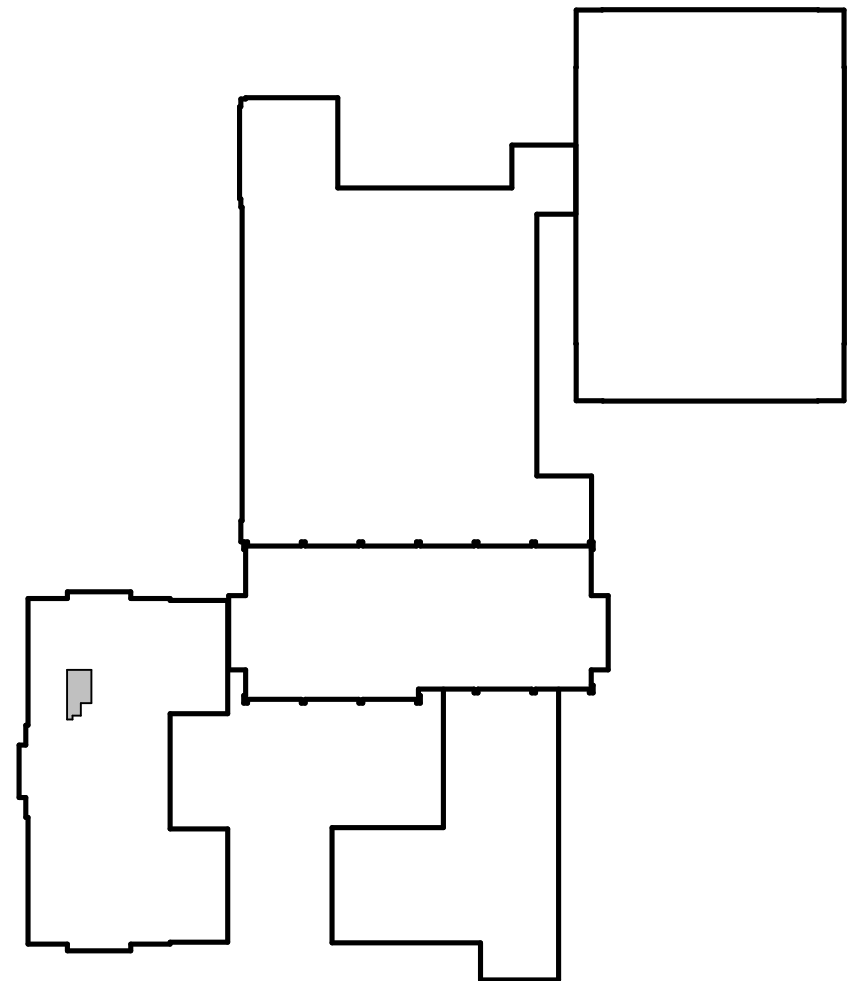


PLAN KEY
NOT TO SCALE



2
A602 1/8" = 1'-0"
ENLARGED REFLECTED CEILING PLAN - LEVEL 820.00
NORTH

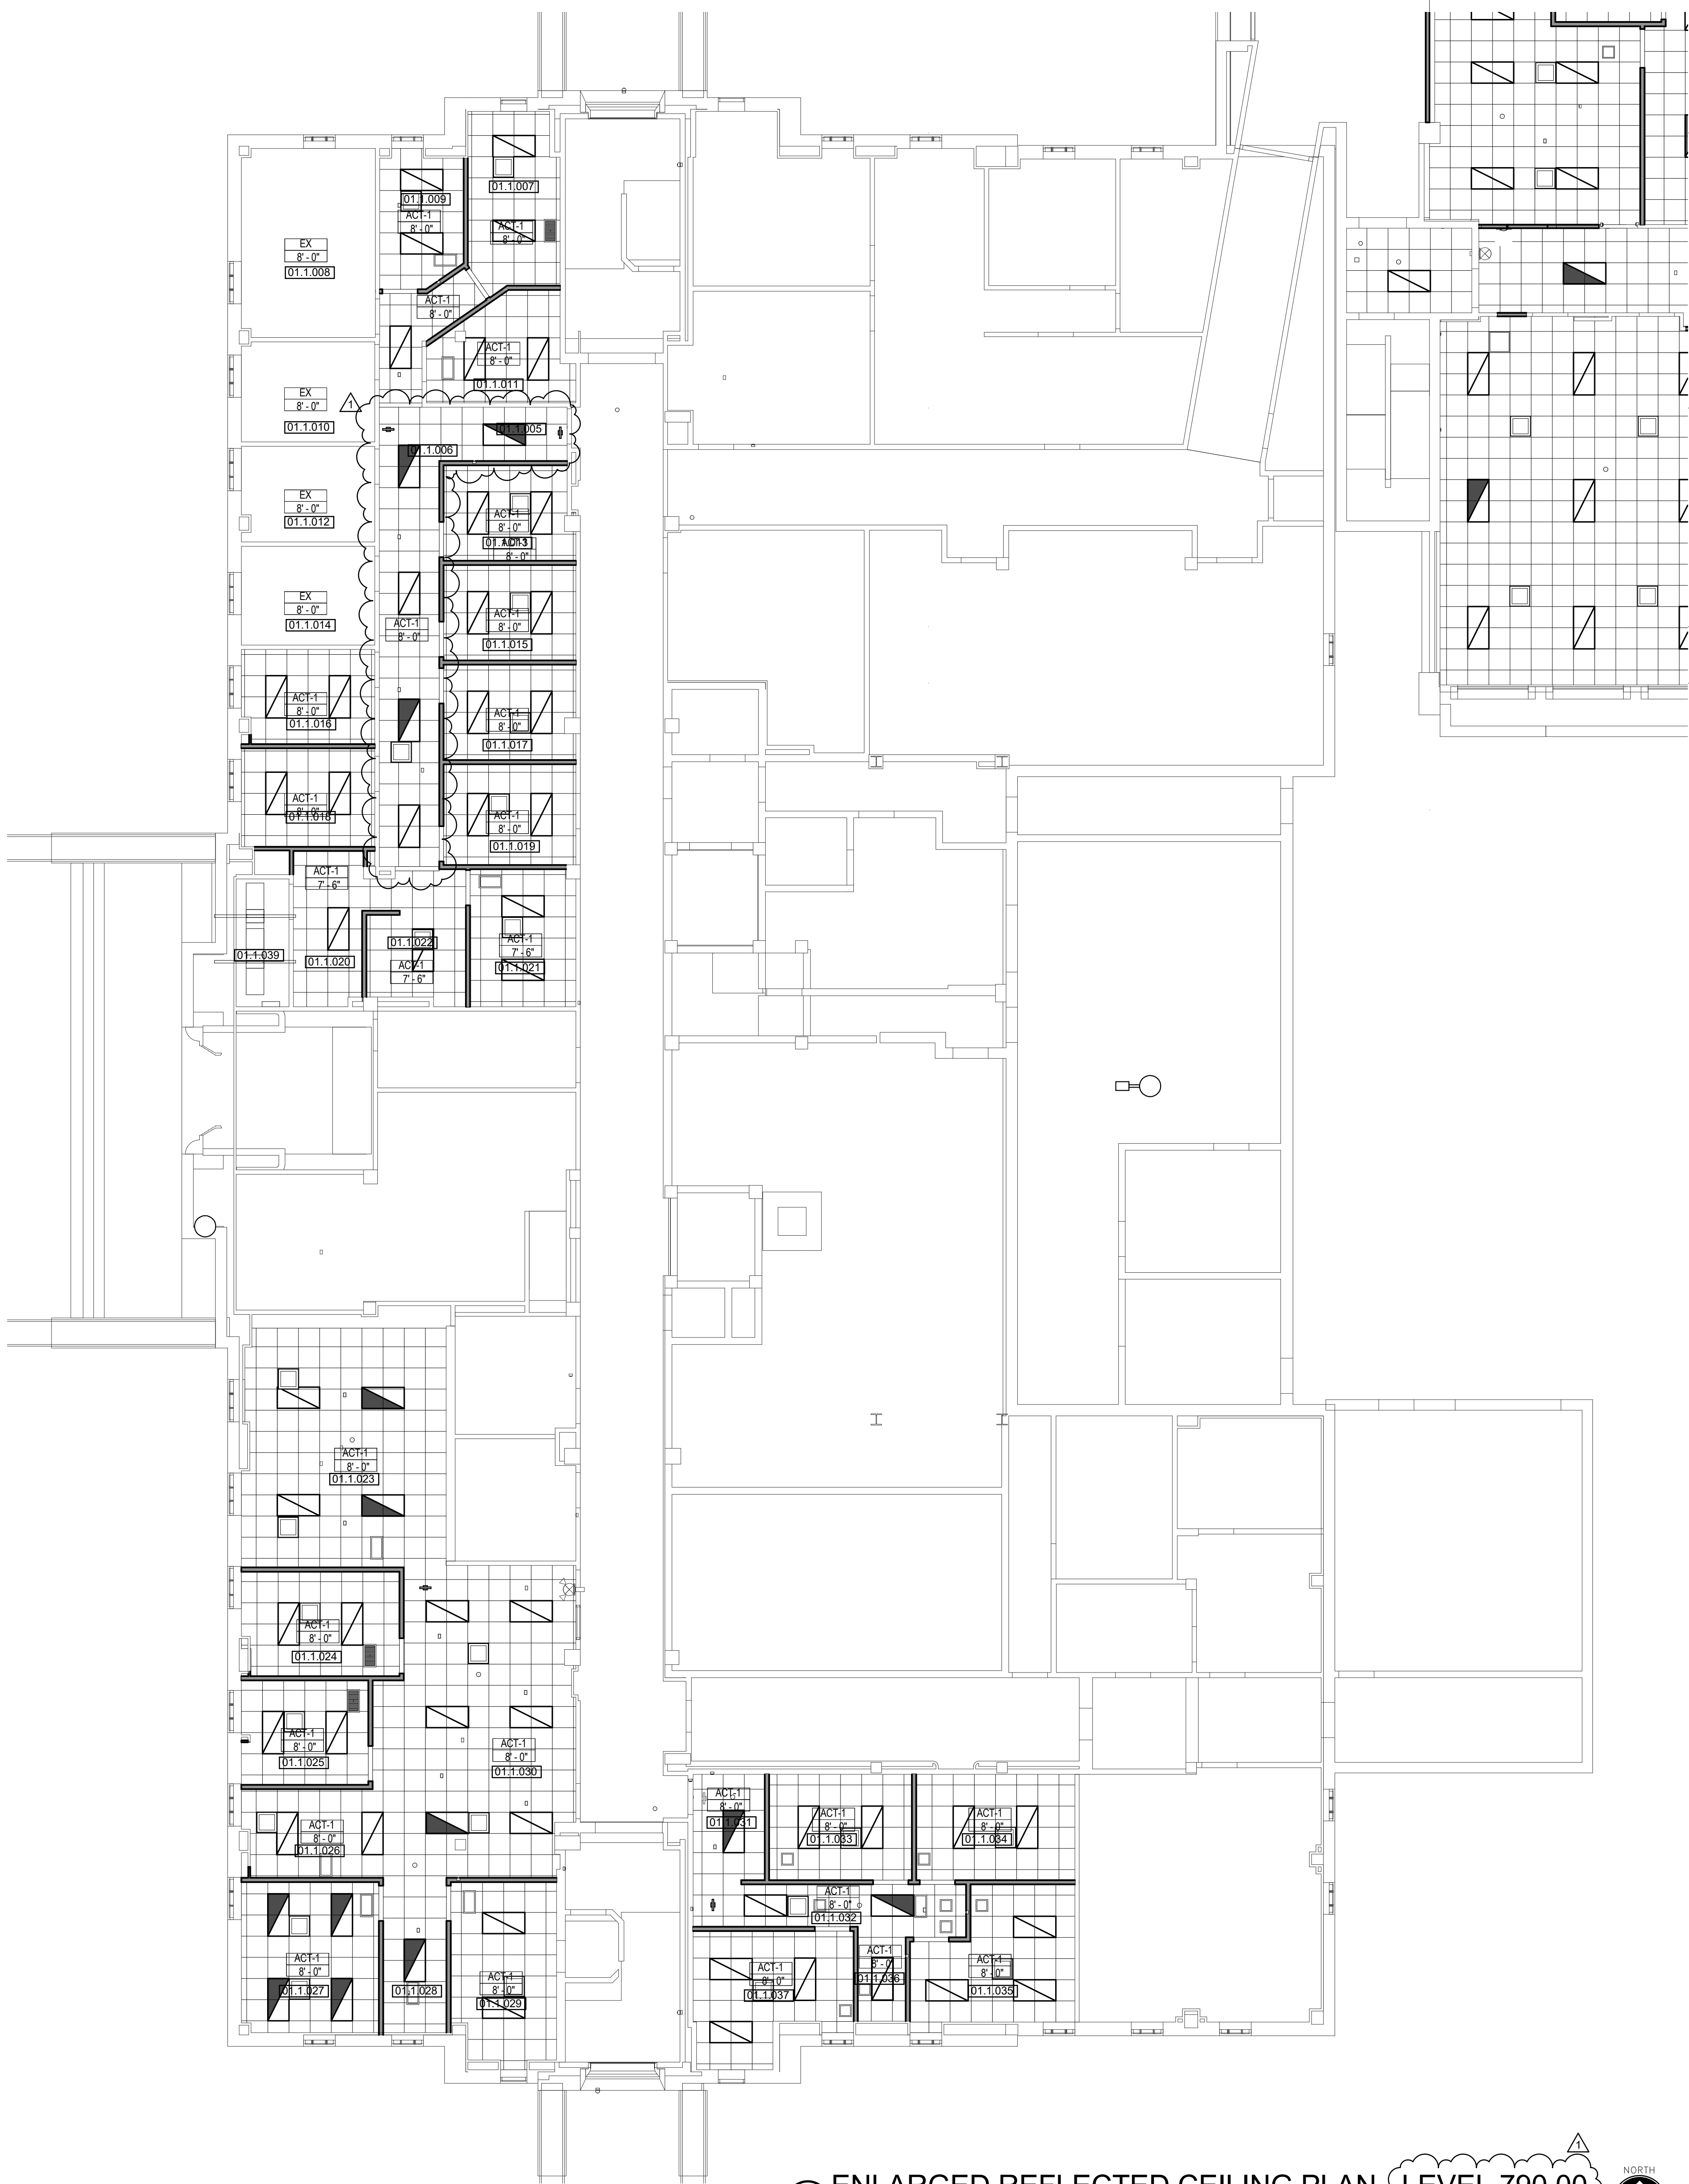

1
A602 1/8" = 1'-0"
ENLARGED REFLECTED CEILING PLAN - LEVEL 790.00
NORTH

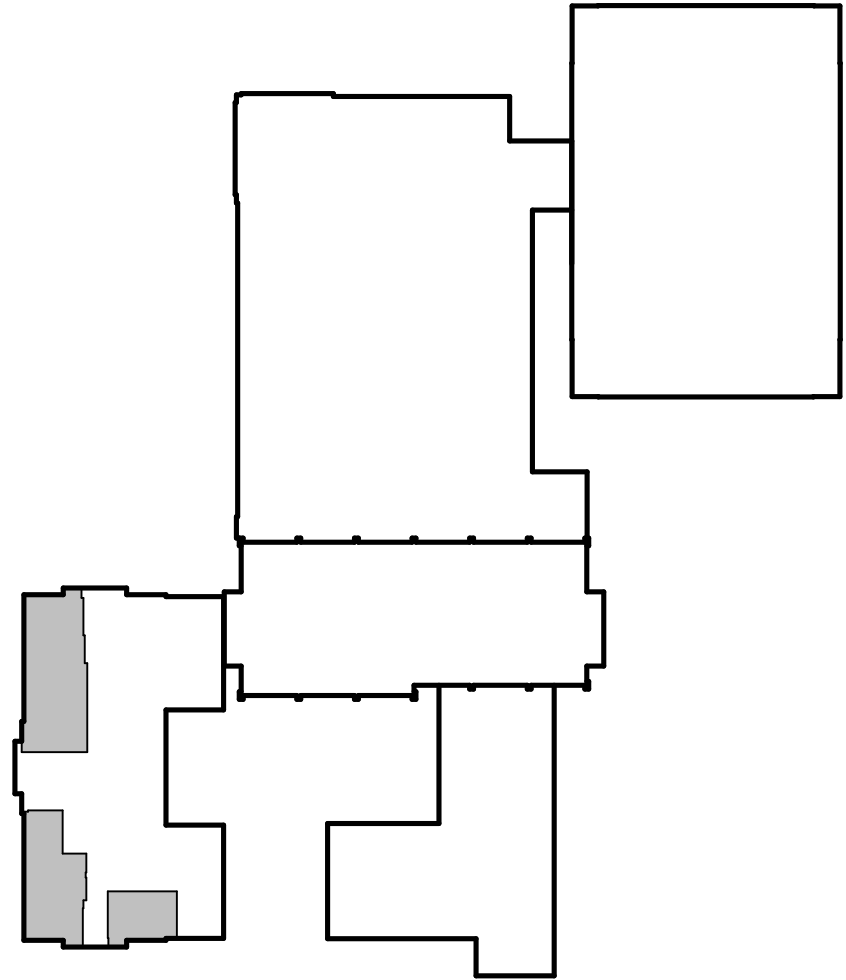

PLAN KEY
NOT TO SCALE



- ### GENERAL CEILING PLAN NOTES
- SEE MECHANICAL AND ELECTRICAL DRAWINGS FOR DEVICE/FIXTURE TYPES SIZES, INSTALLATION AND SPECIFICATIONS.
 - VERIFY ALL CONDITIONS AND DIMENSIONS PRIOR TO CEILING INSTALLATION.
 - CEILING PLAN SHOWS DESIGN INTENT ONLY. REFER TO SPECIFICATIONS AS WELL AS MECHANICAL AND ELECTRICAL DRAWINGS FOR DEVICES, TYPES AND INSTALLATION. DEVICES SHOWN ON ARCHITECTURAL PLAN AND NOT ON THE ENGINEERING DRAWINGS OR SPECIFICATIONS SHOULD BE BROUGHT TO ARCHITECTS ATTENTION FOR CLARIFICATION.
 - ACOUSTICAL CEILING GRID SHALL BE CENTERED IN ROOMS UNLESS NOTED OTHERWISE.
 - CEILING HEIGHTS ARE DIMENSIONED FROM FINISH FLOOR LINE TO DESIGN ELEVATION OF FINISHED CEILING UNLESS NOTED OTHERWISE.
 - CENTER IN BOTH DIRECTIONS RECESSED LIGHTS, ELECTRICAL AND MECHANICAL DEVICES AND SPRINKLER HEADS WHEN SHOWN IN CEILING TILE.
 - MECHANICAL, PLUMBING AND ELECTRICAL CONTRACTORS SHALL COORDINATE DEVICES REQUIRING ACCESS IN NON ACCESSIBLE CEILING. PROVIDE ACCESS PANELS AS NEEDED (EXAMPLE: MECHANICAL VAV BOXES, PLUMBING CLEANOUTS, ETC.).
 - SEE ELECTRICAL LIGHTING PLANS FOR LIGHT FIXTURE LAYOUT AND LIGHT FIXTURE NOTES. LIGHT FIXTURES SHOWN ON THE REFLECTED CEILING PLANS ARE FOR REFERENCE ONLY.
- CEILING HEIGHTS SHOWN ARE ESTIMATES OF WHAT CAN BE ACCOMPLISHED. MECHANICAL EQUIPMENT MAY NECESSITATE A CHANGE TO THESE HEIGHTS. VERIFY FEASIBLE CEILING HEIGHTS AND DISCUSS NECESSARY CHANGES WITH THE ARCHITECT PRIOR TO INSTALLATION OF SYSTEMS ABOVE CEILING.

- ### CEILING PLAN LEGEND
- CEILING FINISH
 - CEILING HEIGHT (A.F.F.)
 - ROOM NUMBER
 - EXPOSED CEILING
 - GYPSUM BOARD CEILING/SOFFIT (GYP) - SEE SPECIFICATIONS FOR ADDITIONAL INFORMATION
 - ACOUSTICAL CEILING (ACT) - SEE SPECIFICATIONS FOR ADDITIONAL INFORMATION
 - HVAC GRILLS - SEE HVAC PLANS
 - 2x4 LAY-IN LIGHT FIXTURE
 - RECESSED DOWNLIGHT FIXTURE
 - SURFACE MOUNTED LINEAR LIGHT FIXTURE
 - HANGING PENDANT FIXTURE

- ### CEILING DESCRIPTIONS
- | | |
|-------|--|
| ACT-1 | ACT - STANDARD |
| ACT-2 | VINYL COVERED GYP., ALUMINUM FRAME |
| ACT-3 | FULLY ACCESSIBLE WOOD PANEL CEILING SYSTEM (1/4" HORIZONTAL REVEALS) WITH 4" WOOD SUBSTRATE TRIM |
| GYP | GYPSUM BOARD (PAINT) |

PLAN KEYED NOTES