

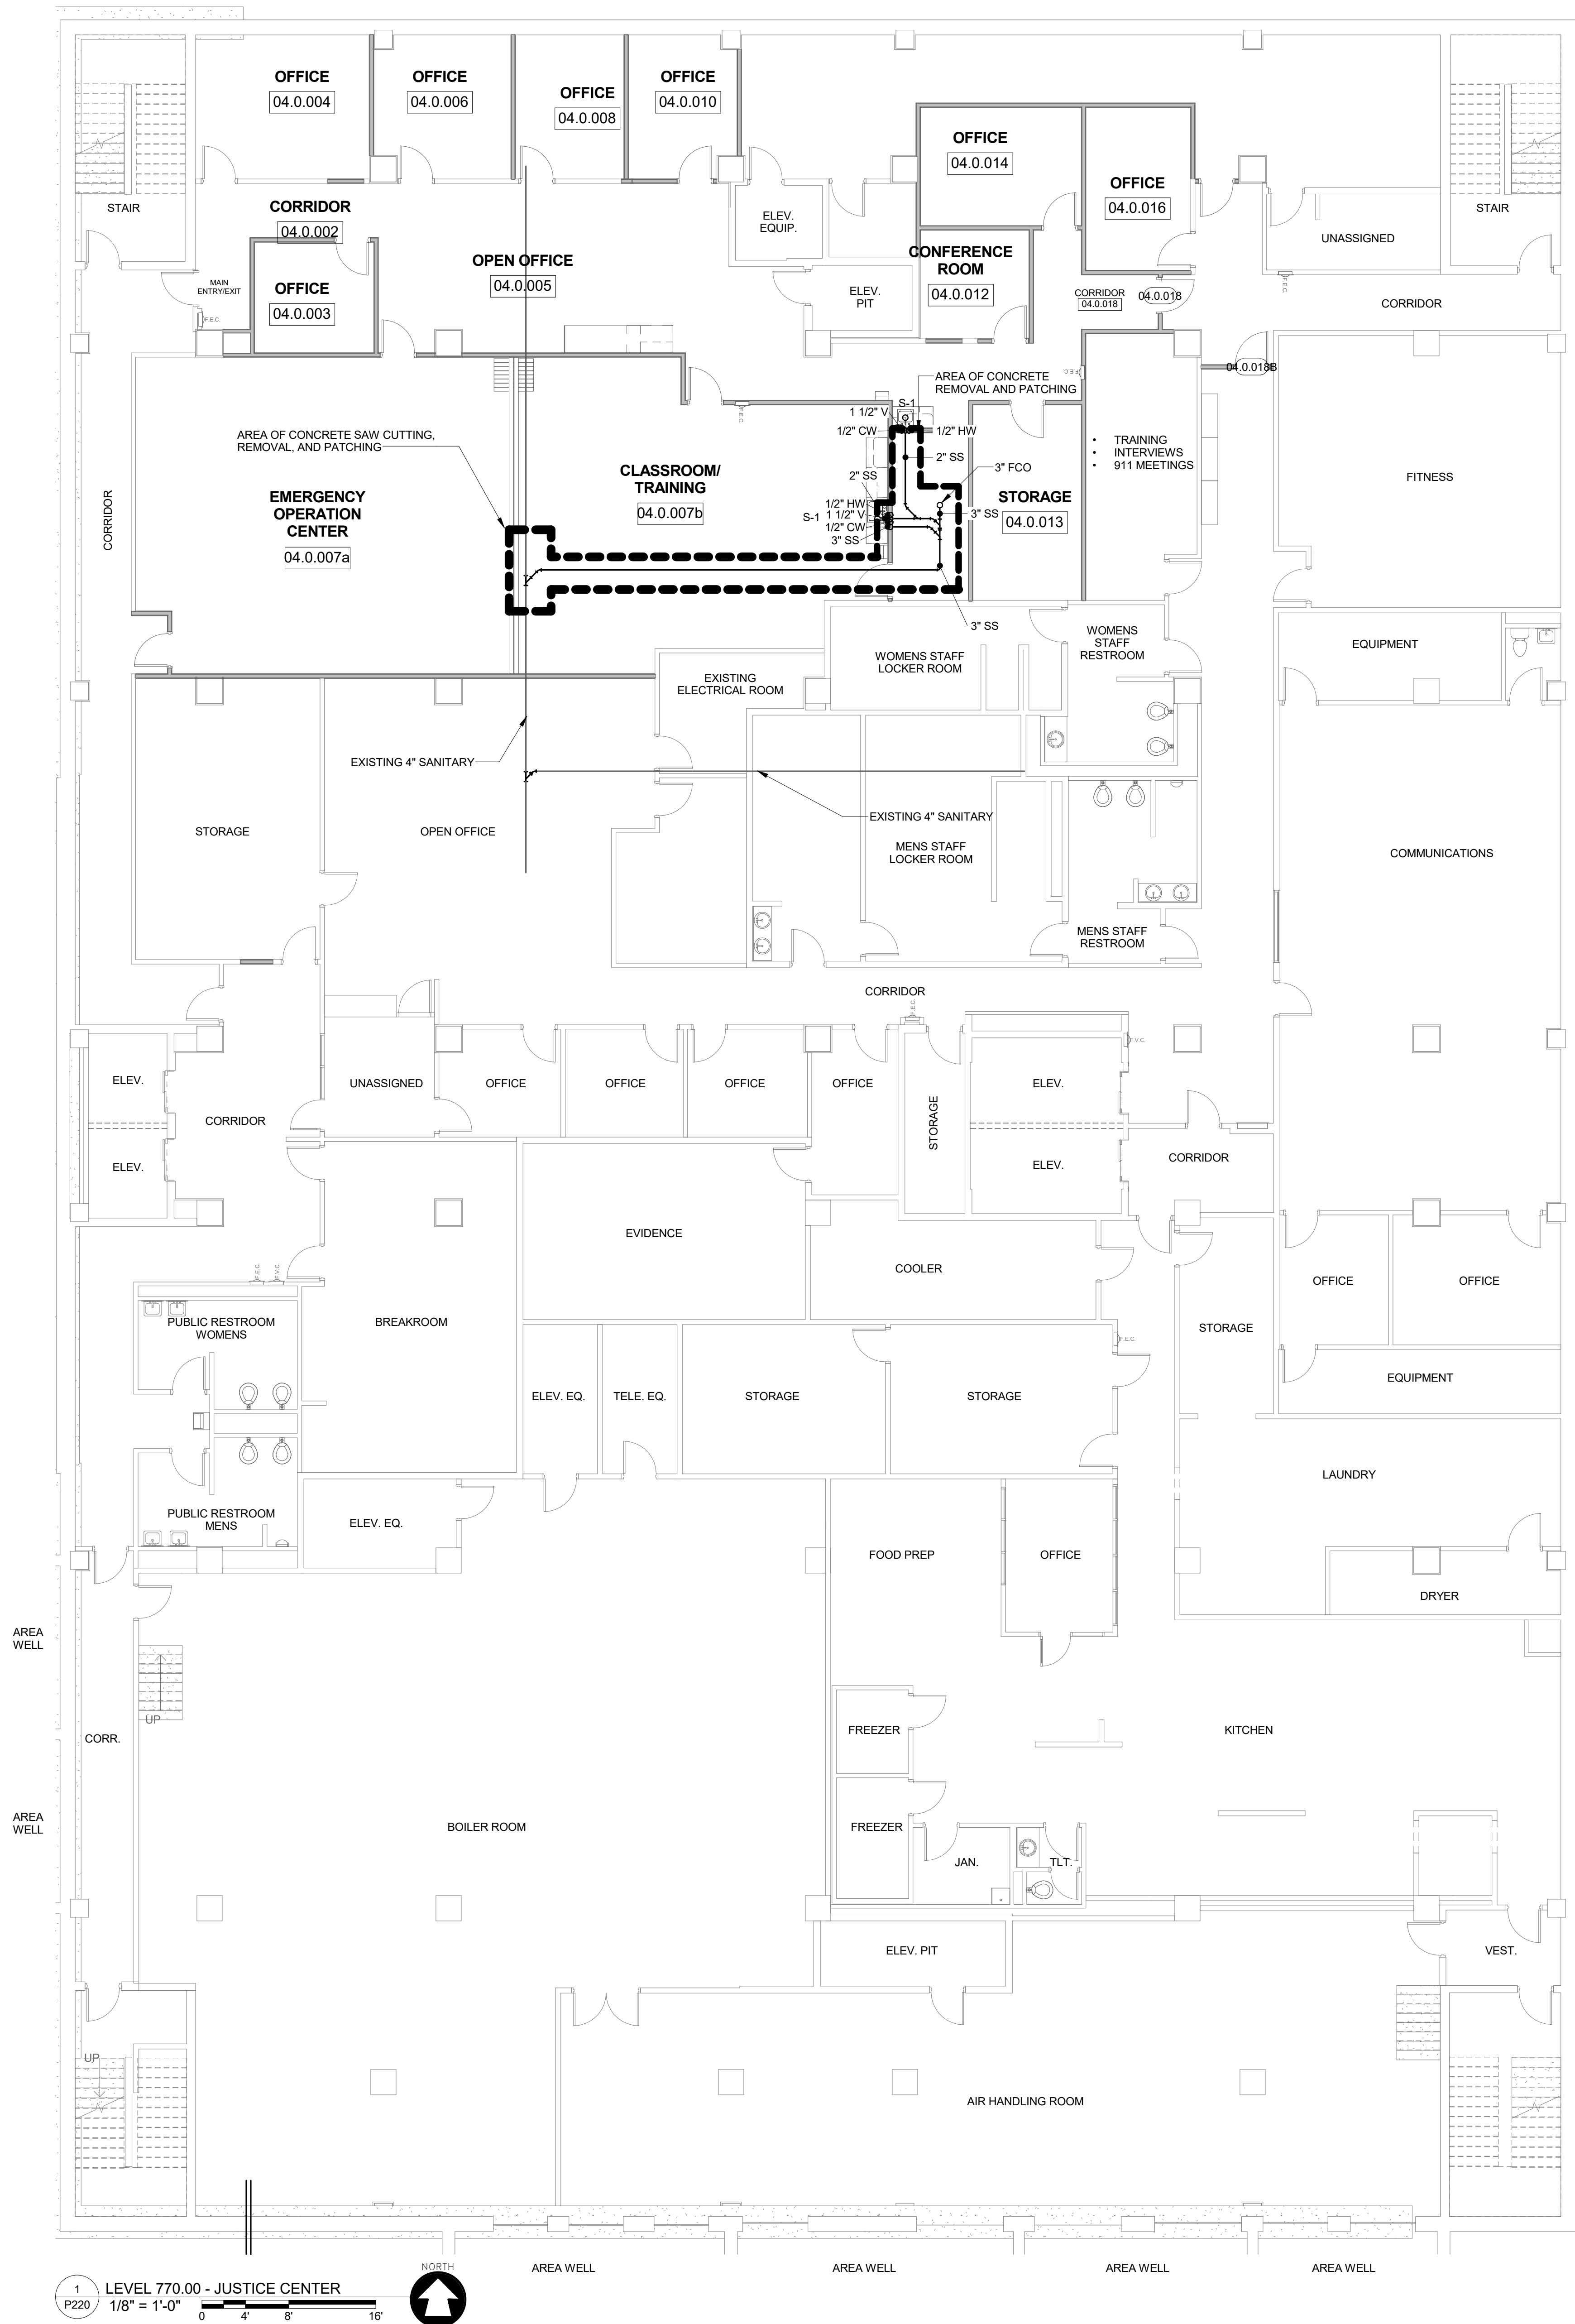


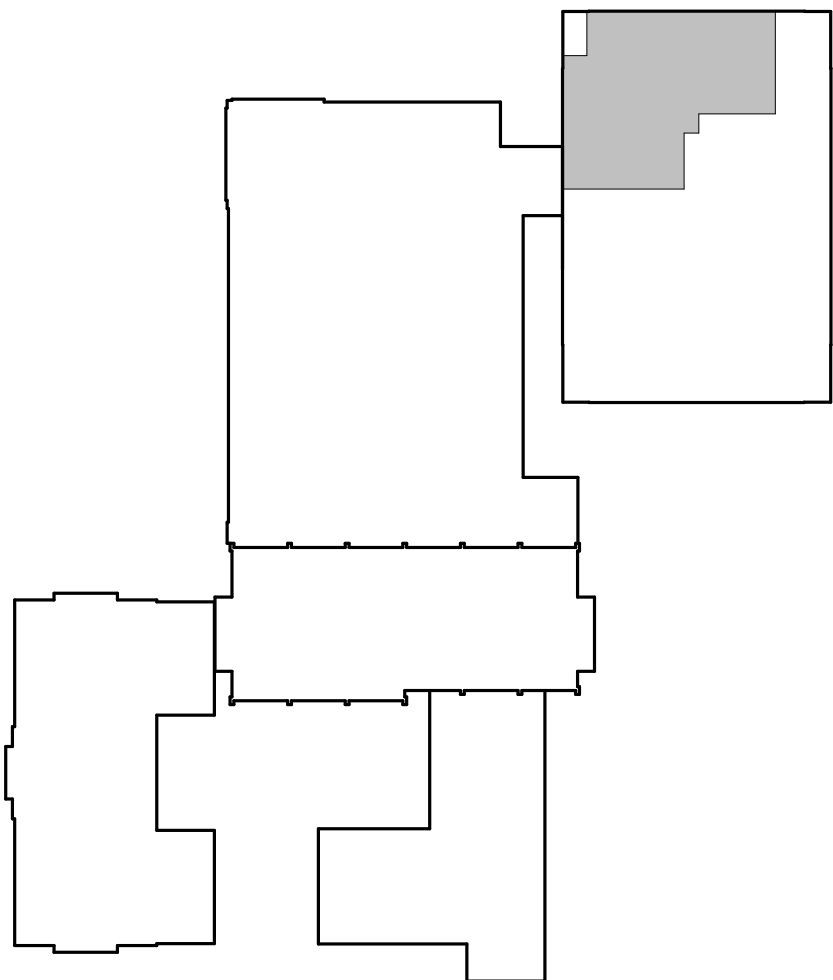

PLUMBING LEGEND

- CW = COLD WATER
- HW = HOT WATER
- HWR = HOT WATER RECIRCULATING
- SS = SANITARY DRAIN
- V = VENT
- SD = STORM DRAIN
- OSD = OVERFLOW STORM DRAIN
- CWD = CLEAR WATER DRAIN
- FD = FLOOR DRAIN
- FCO = FLOOR CLEANOUT
- CO = CLEAN OUT
- RD = ROOF DRAIN
- ORD = OVERFLOW ROOF DRAIN
- VTR = VENT THROUGH ROOF

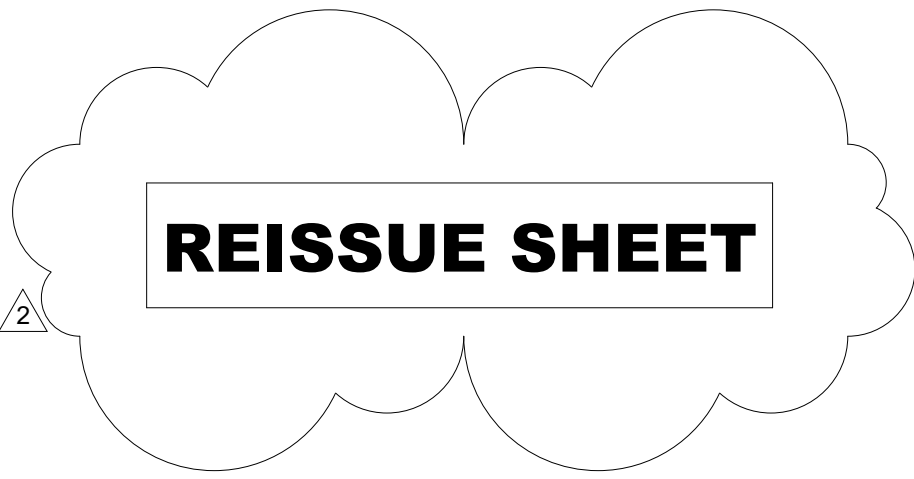

KEY PLAN
NOT TO SCALE



McMahon provides this drawing as instruments of service. All work shall be in accordance with the contract documents prepared by McMahon. The client shall be responsible for obtaining all necessary permits and for securing all required approvals from the appropriate authorities. McMahon is not responsible for any errors or omissions in this drawing or for any consequences arising therefrom. McMahon reserves the right to make changes to this drawing without notice.

NO.	DATE	REVISION
2	4/9/17	ADDENDUM 2

ALTERATION / ADDITION
OUTAGAMIE COUNTY ADMINISTRATION CENTER
S. WALNUT & W. 8TH, APPLETON, WI 54911
LEVEL 770.00 - ENLARGED PLUMBING PLAN - JUSTICE CENTER


DESIGNED NDK	DRAWN NDK
PROJECT NO. 00002-61600160	
DATE MARCH 3, 2017	
SHEET NO. P220	


1 P221 LEVEL 780.00 - JUSTICE CENTER
1/8" = 1'-0"

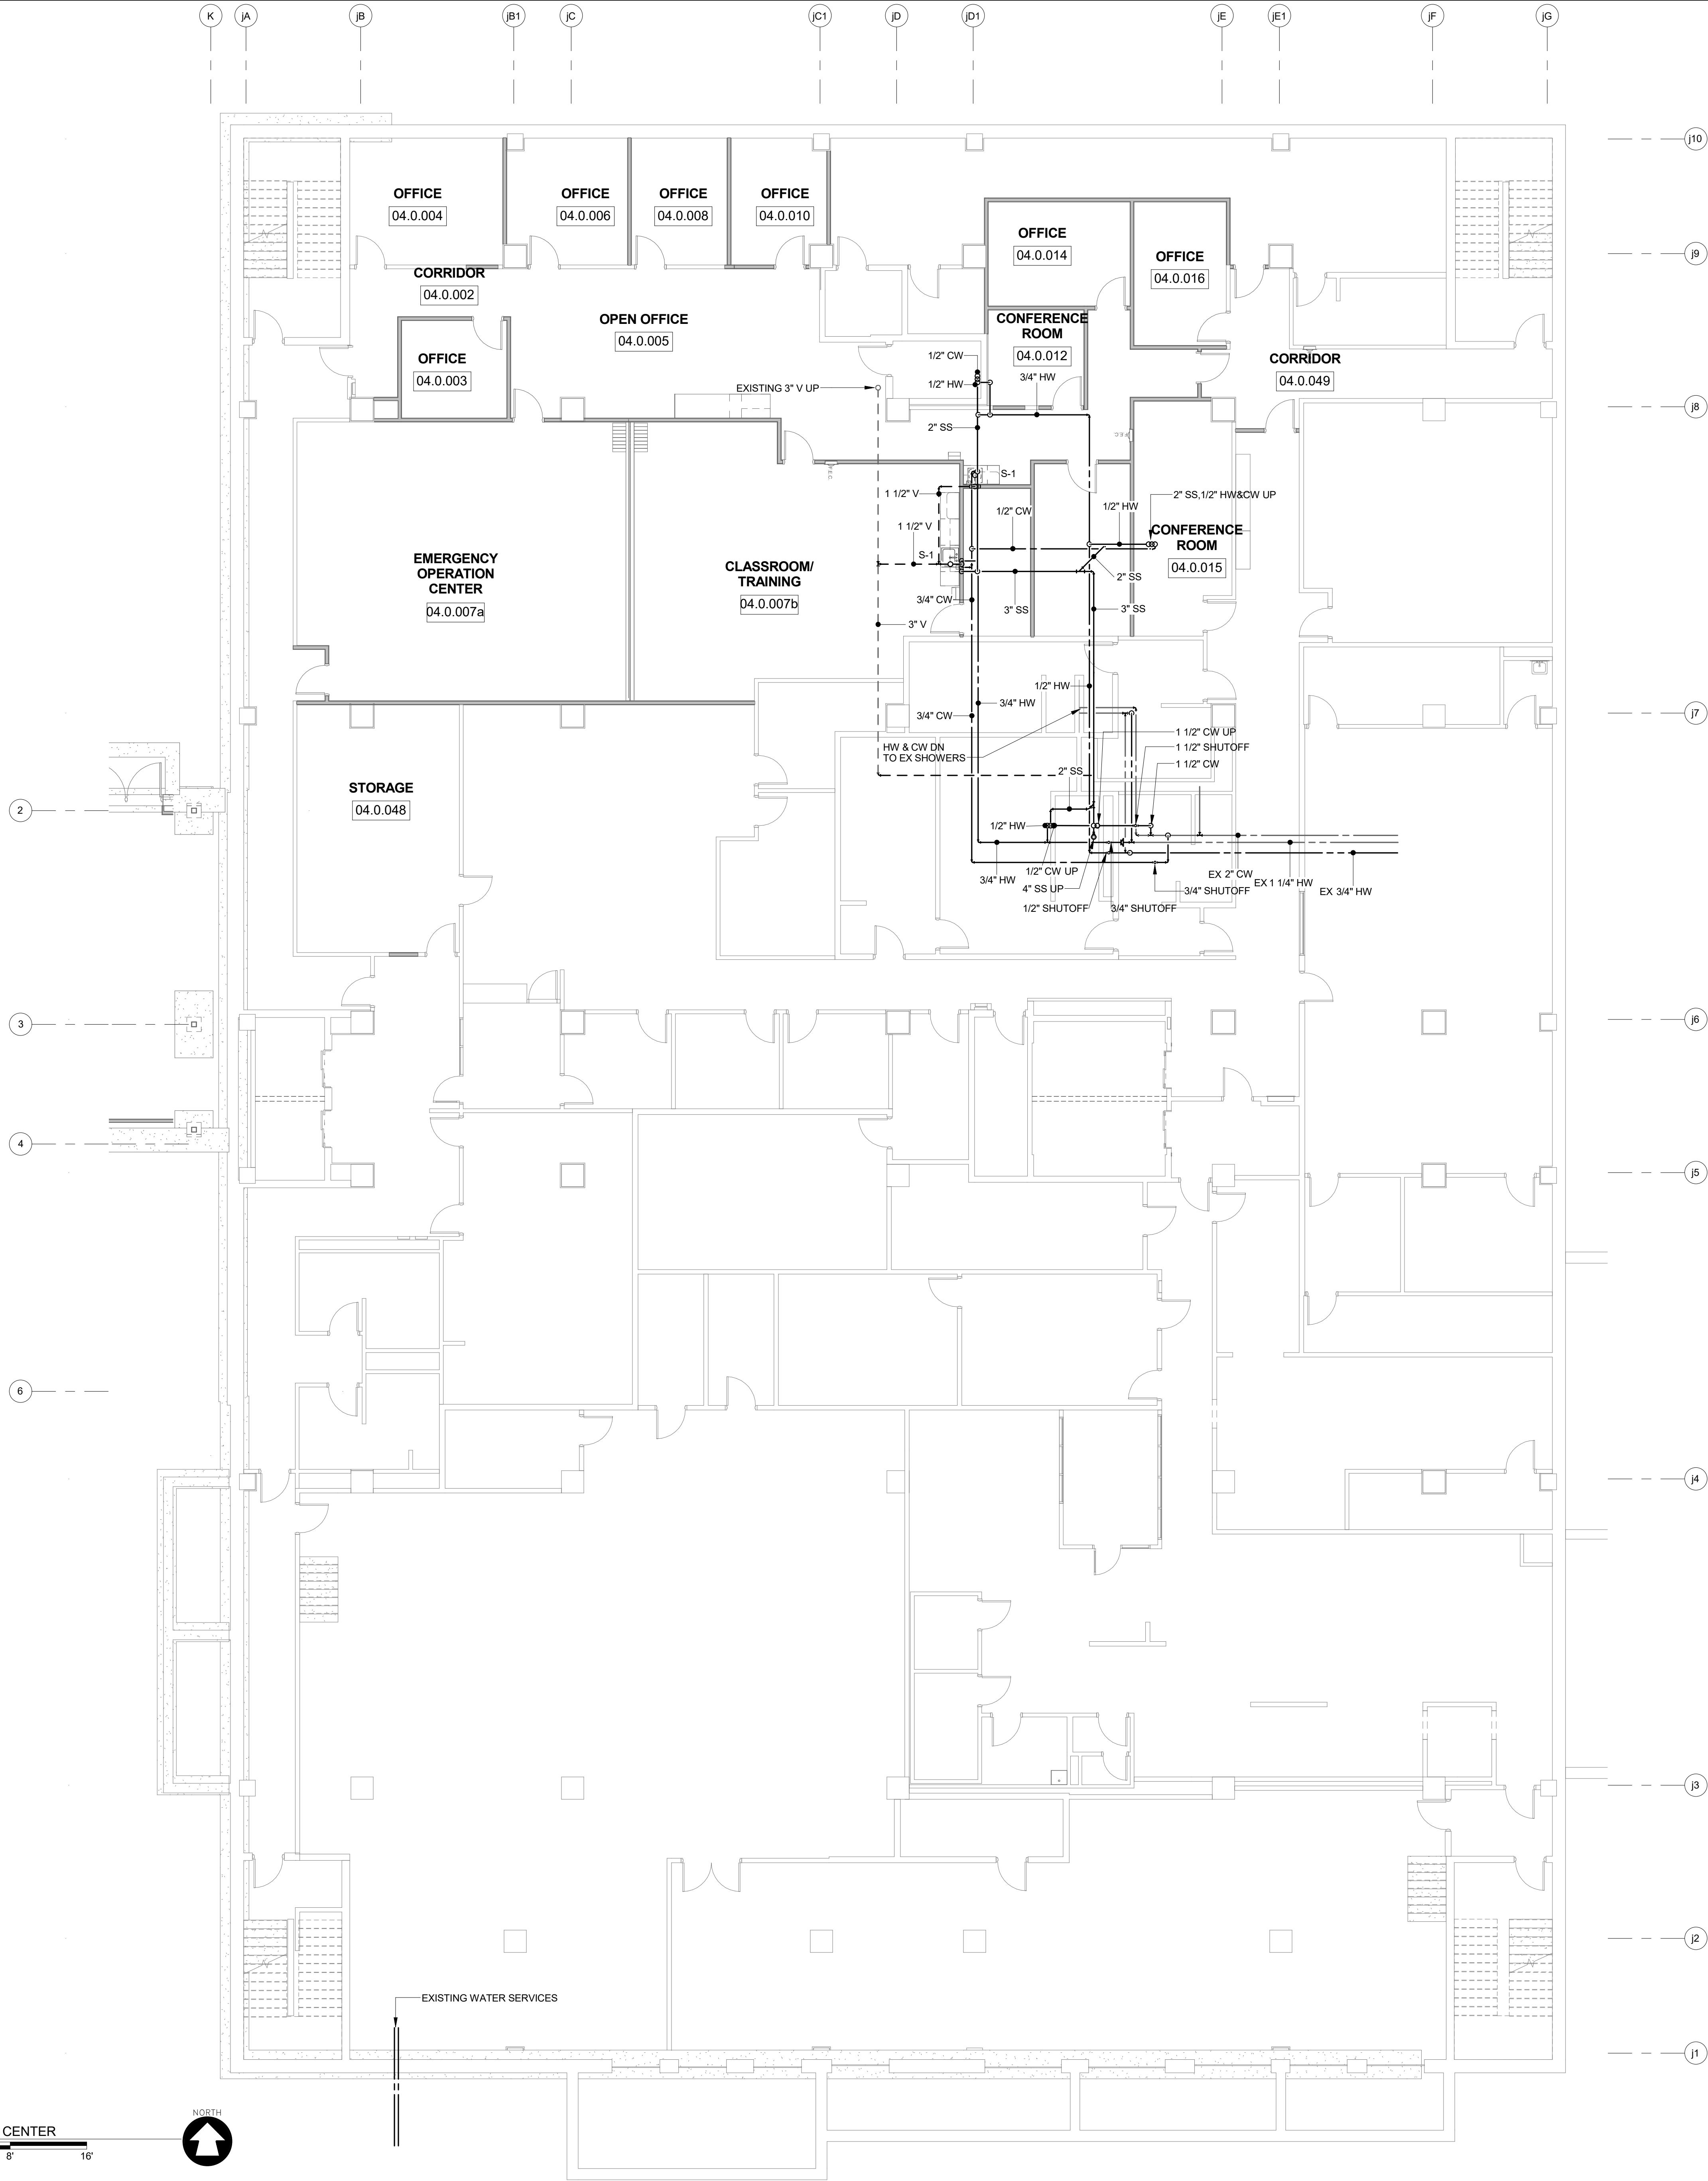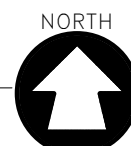

PLUMBING LEGEND

- CW = COLD WATER
- HW = HOT WATER
- HWR = HOT WATER RECIRCULATING
- SS = SANITARY DRAIN
- V = VENT
- SD = STORM DRAIN
- OSD = OVERFLOW STORM DRAIN
- CWD = CLEAR WATER DRAIN
- FD = FLOOR DRAIN
- FCO = FLOOR CLEANOUT
- CO = CLEAN OUT
- RD = ROOF DRAIN
- ORD = OVERFLOW ROOF DRAIN
- VTR = VENT THROUGH ROOF

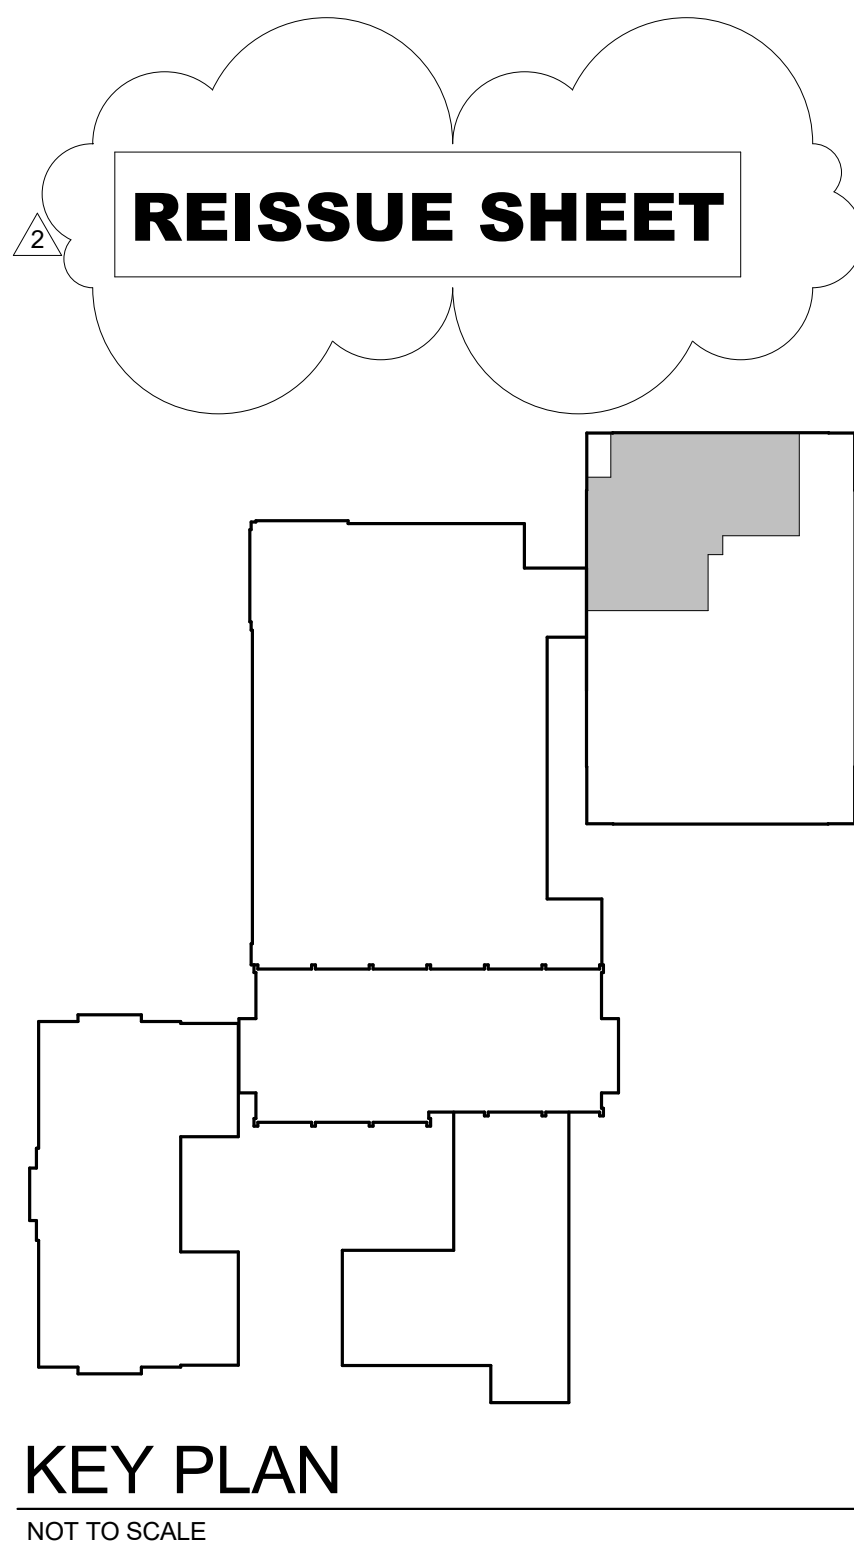

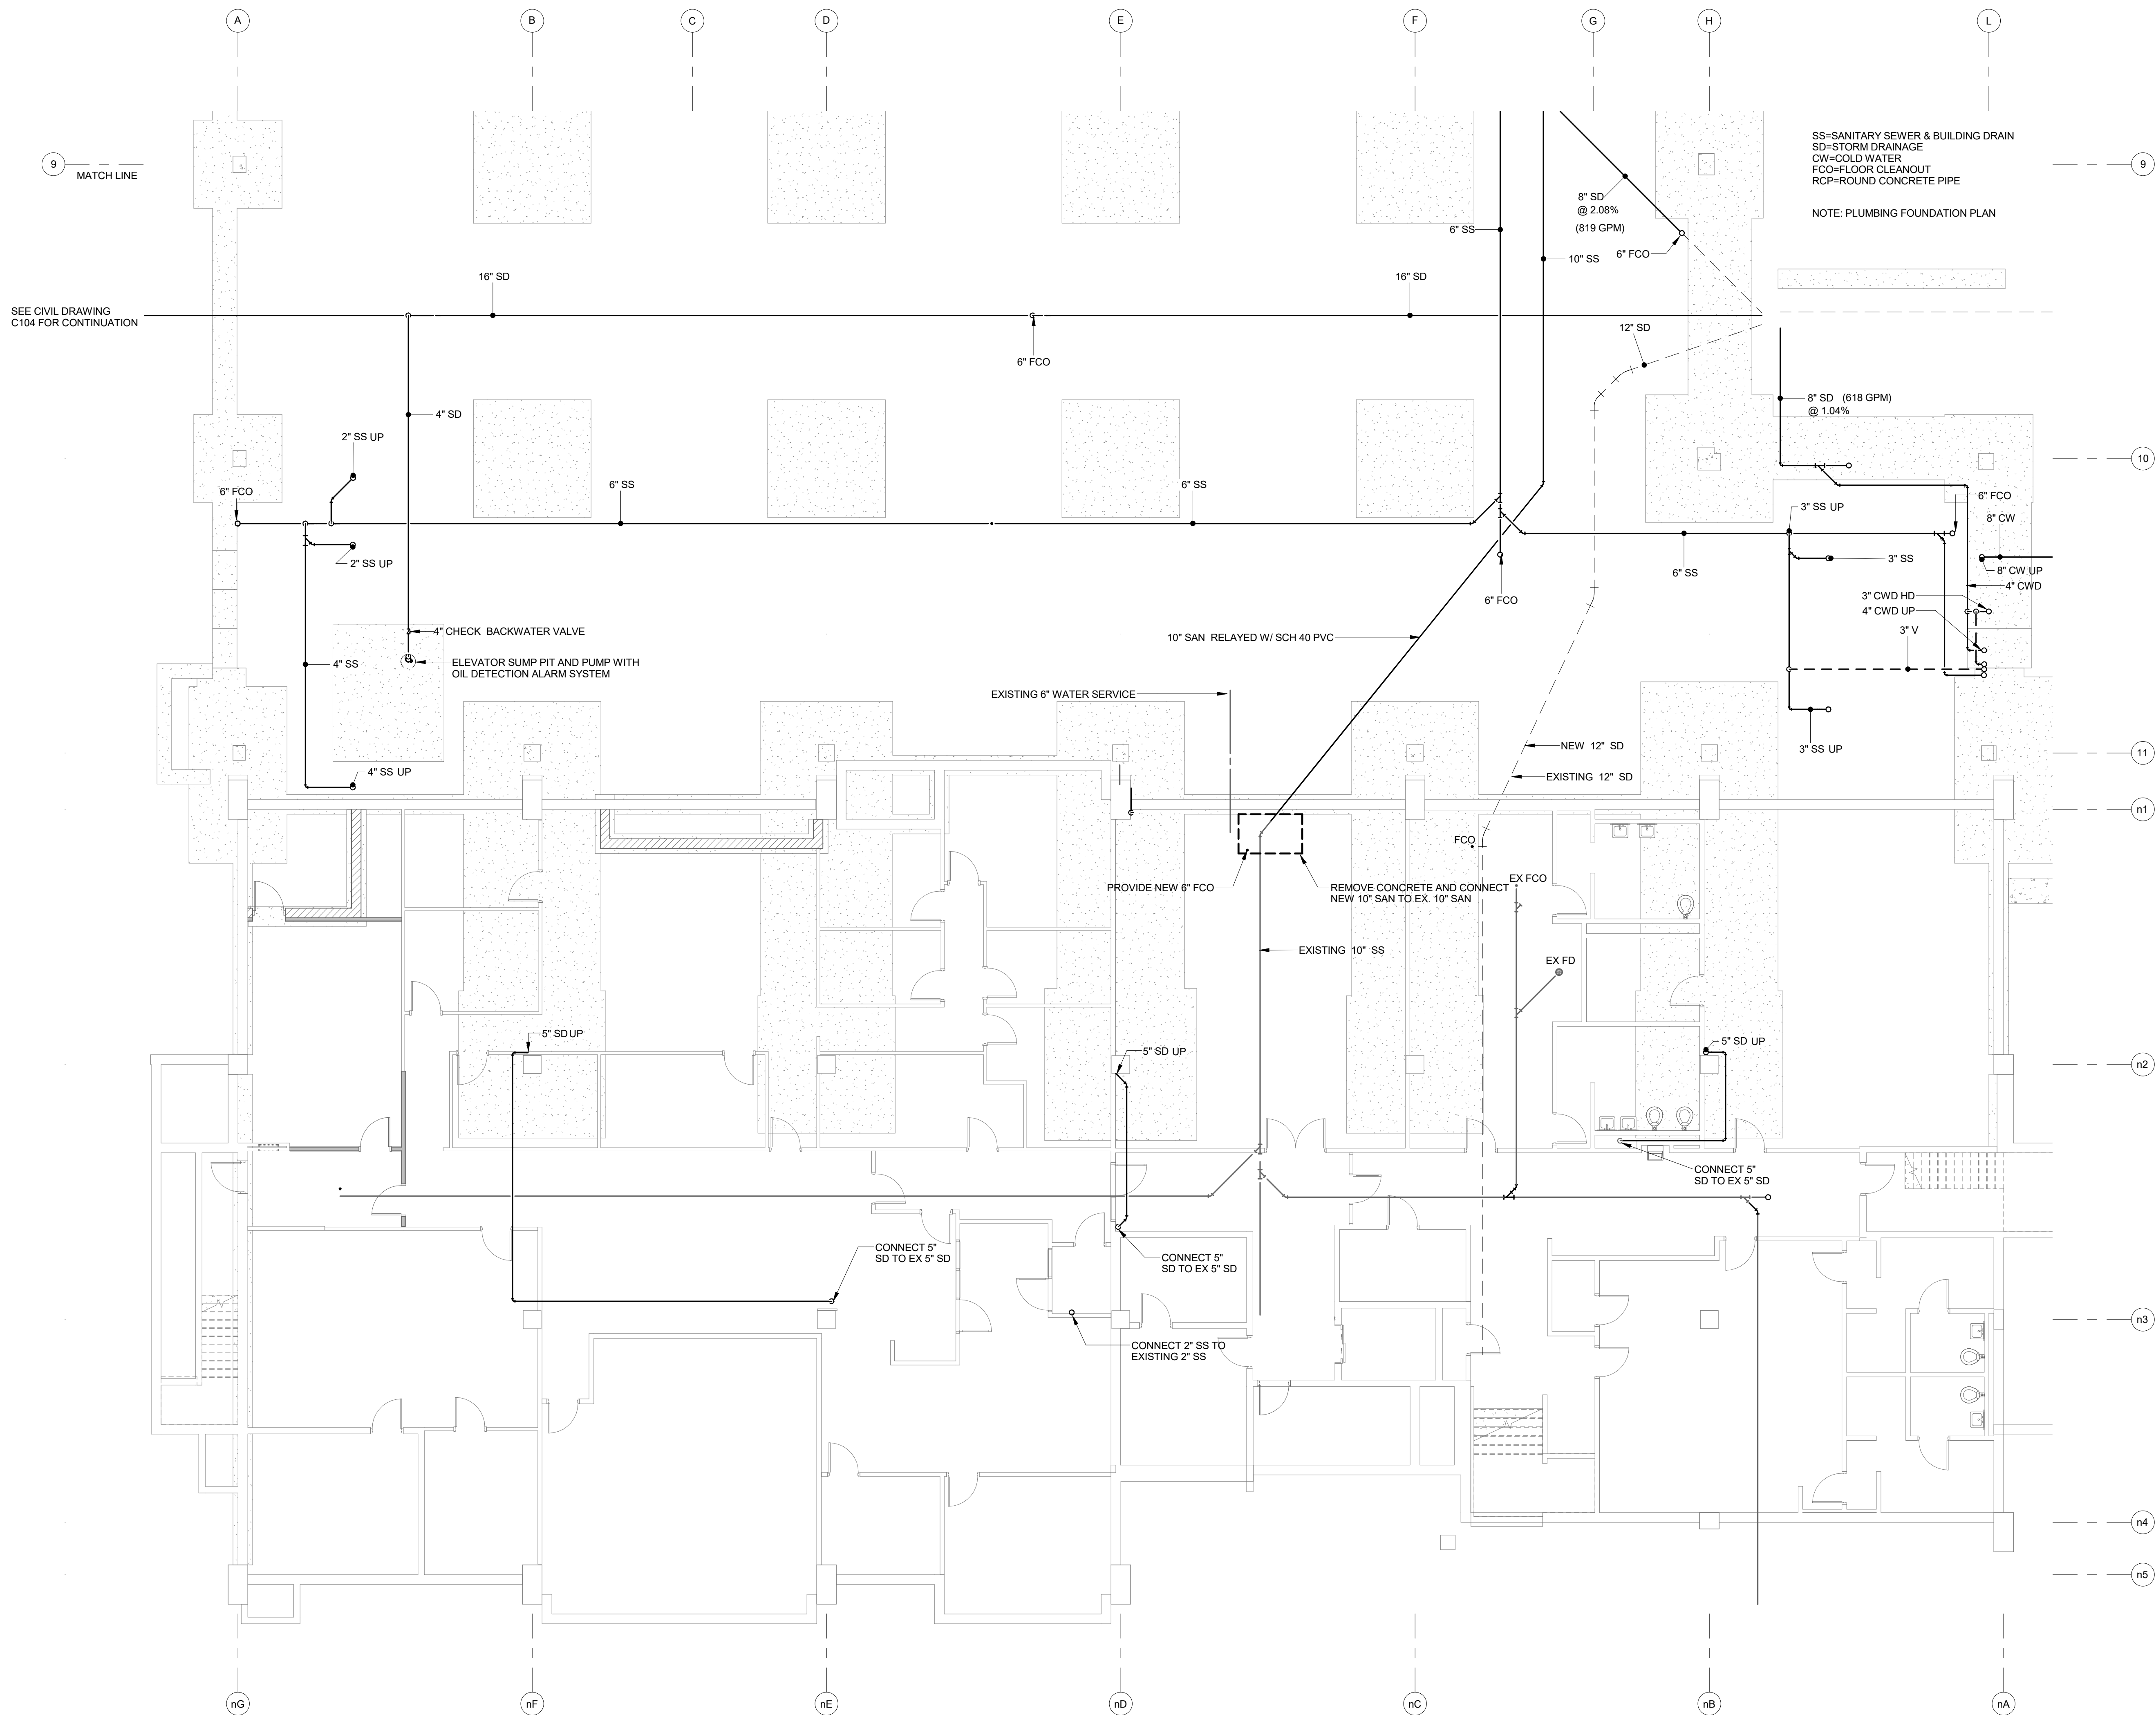


1
P222
LEVEL 770.00 - HHS NORTH / OCAC SOUTH
1/8" = 1'-0"
0 4' 8' 16'
NORTH
↑

PLUMBING LEGEND


- CW = COLD WATER
- HW = HOT WATER
- HWR = HOT WATER RECIRCULATING
- SS = SANITARY DRAIN
- V = VENT
- SD = STORM DRAIN
- OSD = OVERFLOW STORM DRAIN
- CWD = CLEAR WATER DRAIN
- FD = FLOOR DRAIN
- FCO = FLOOR CLEANOUT
- CO = CLEAN OUT
- RD = ROOF DRAIN
- ORD = OVERFLOW ROOF DRAIN
- VTR = VENT THROUGH ROOF

SS=SANITARY SEWER & BUILDING DRAIN
SD=STORM DRAINAGE
CW=COLD WATER
FCO=FLOOR CLEANOUT
RCP=ROUND CONCRETE PIPE
NOTE: PLUMBING FOUNDATION PLAN

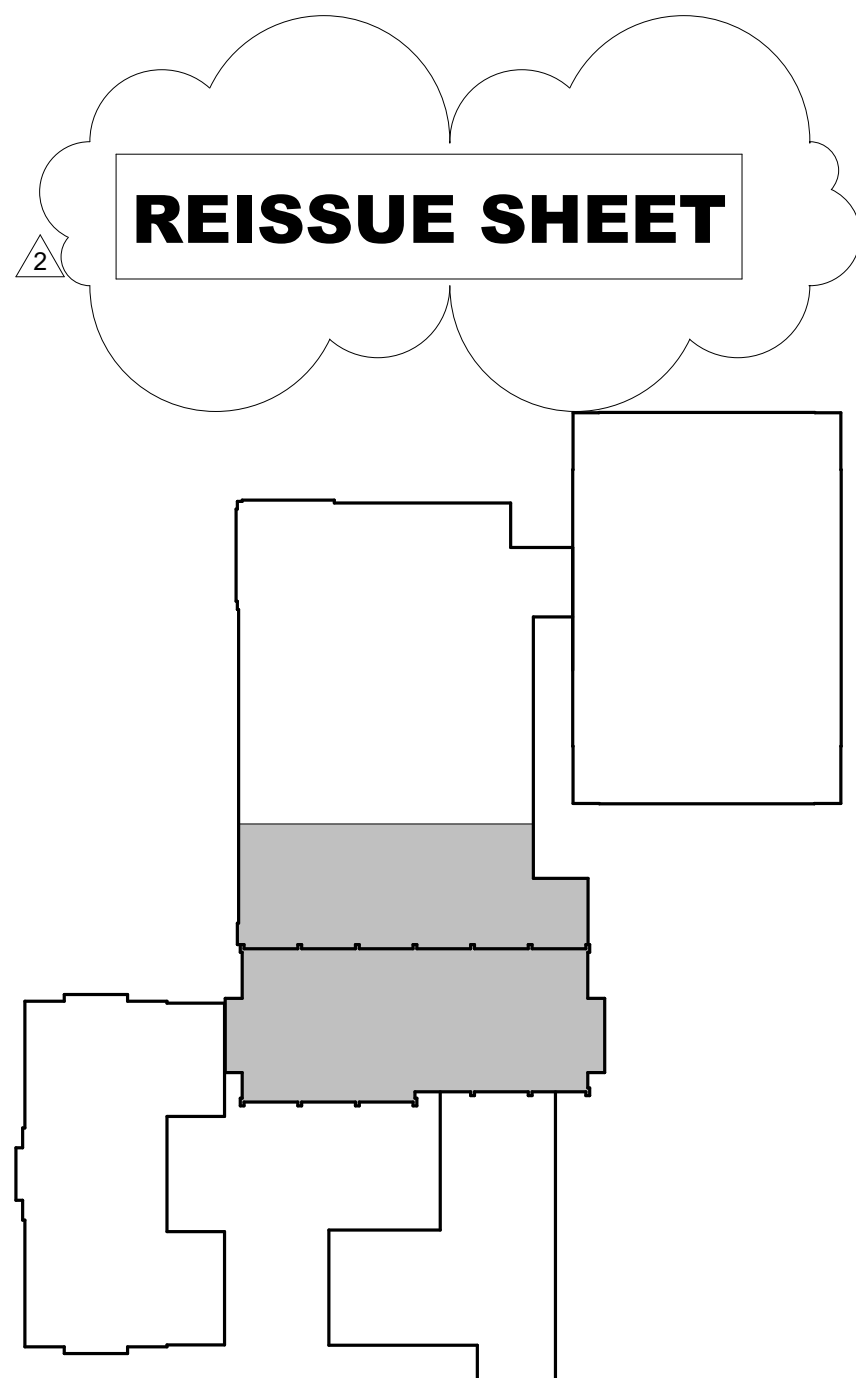

KEY PLAN
NOT TO SCALE



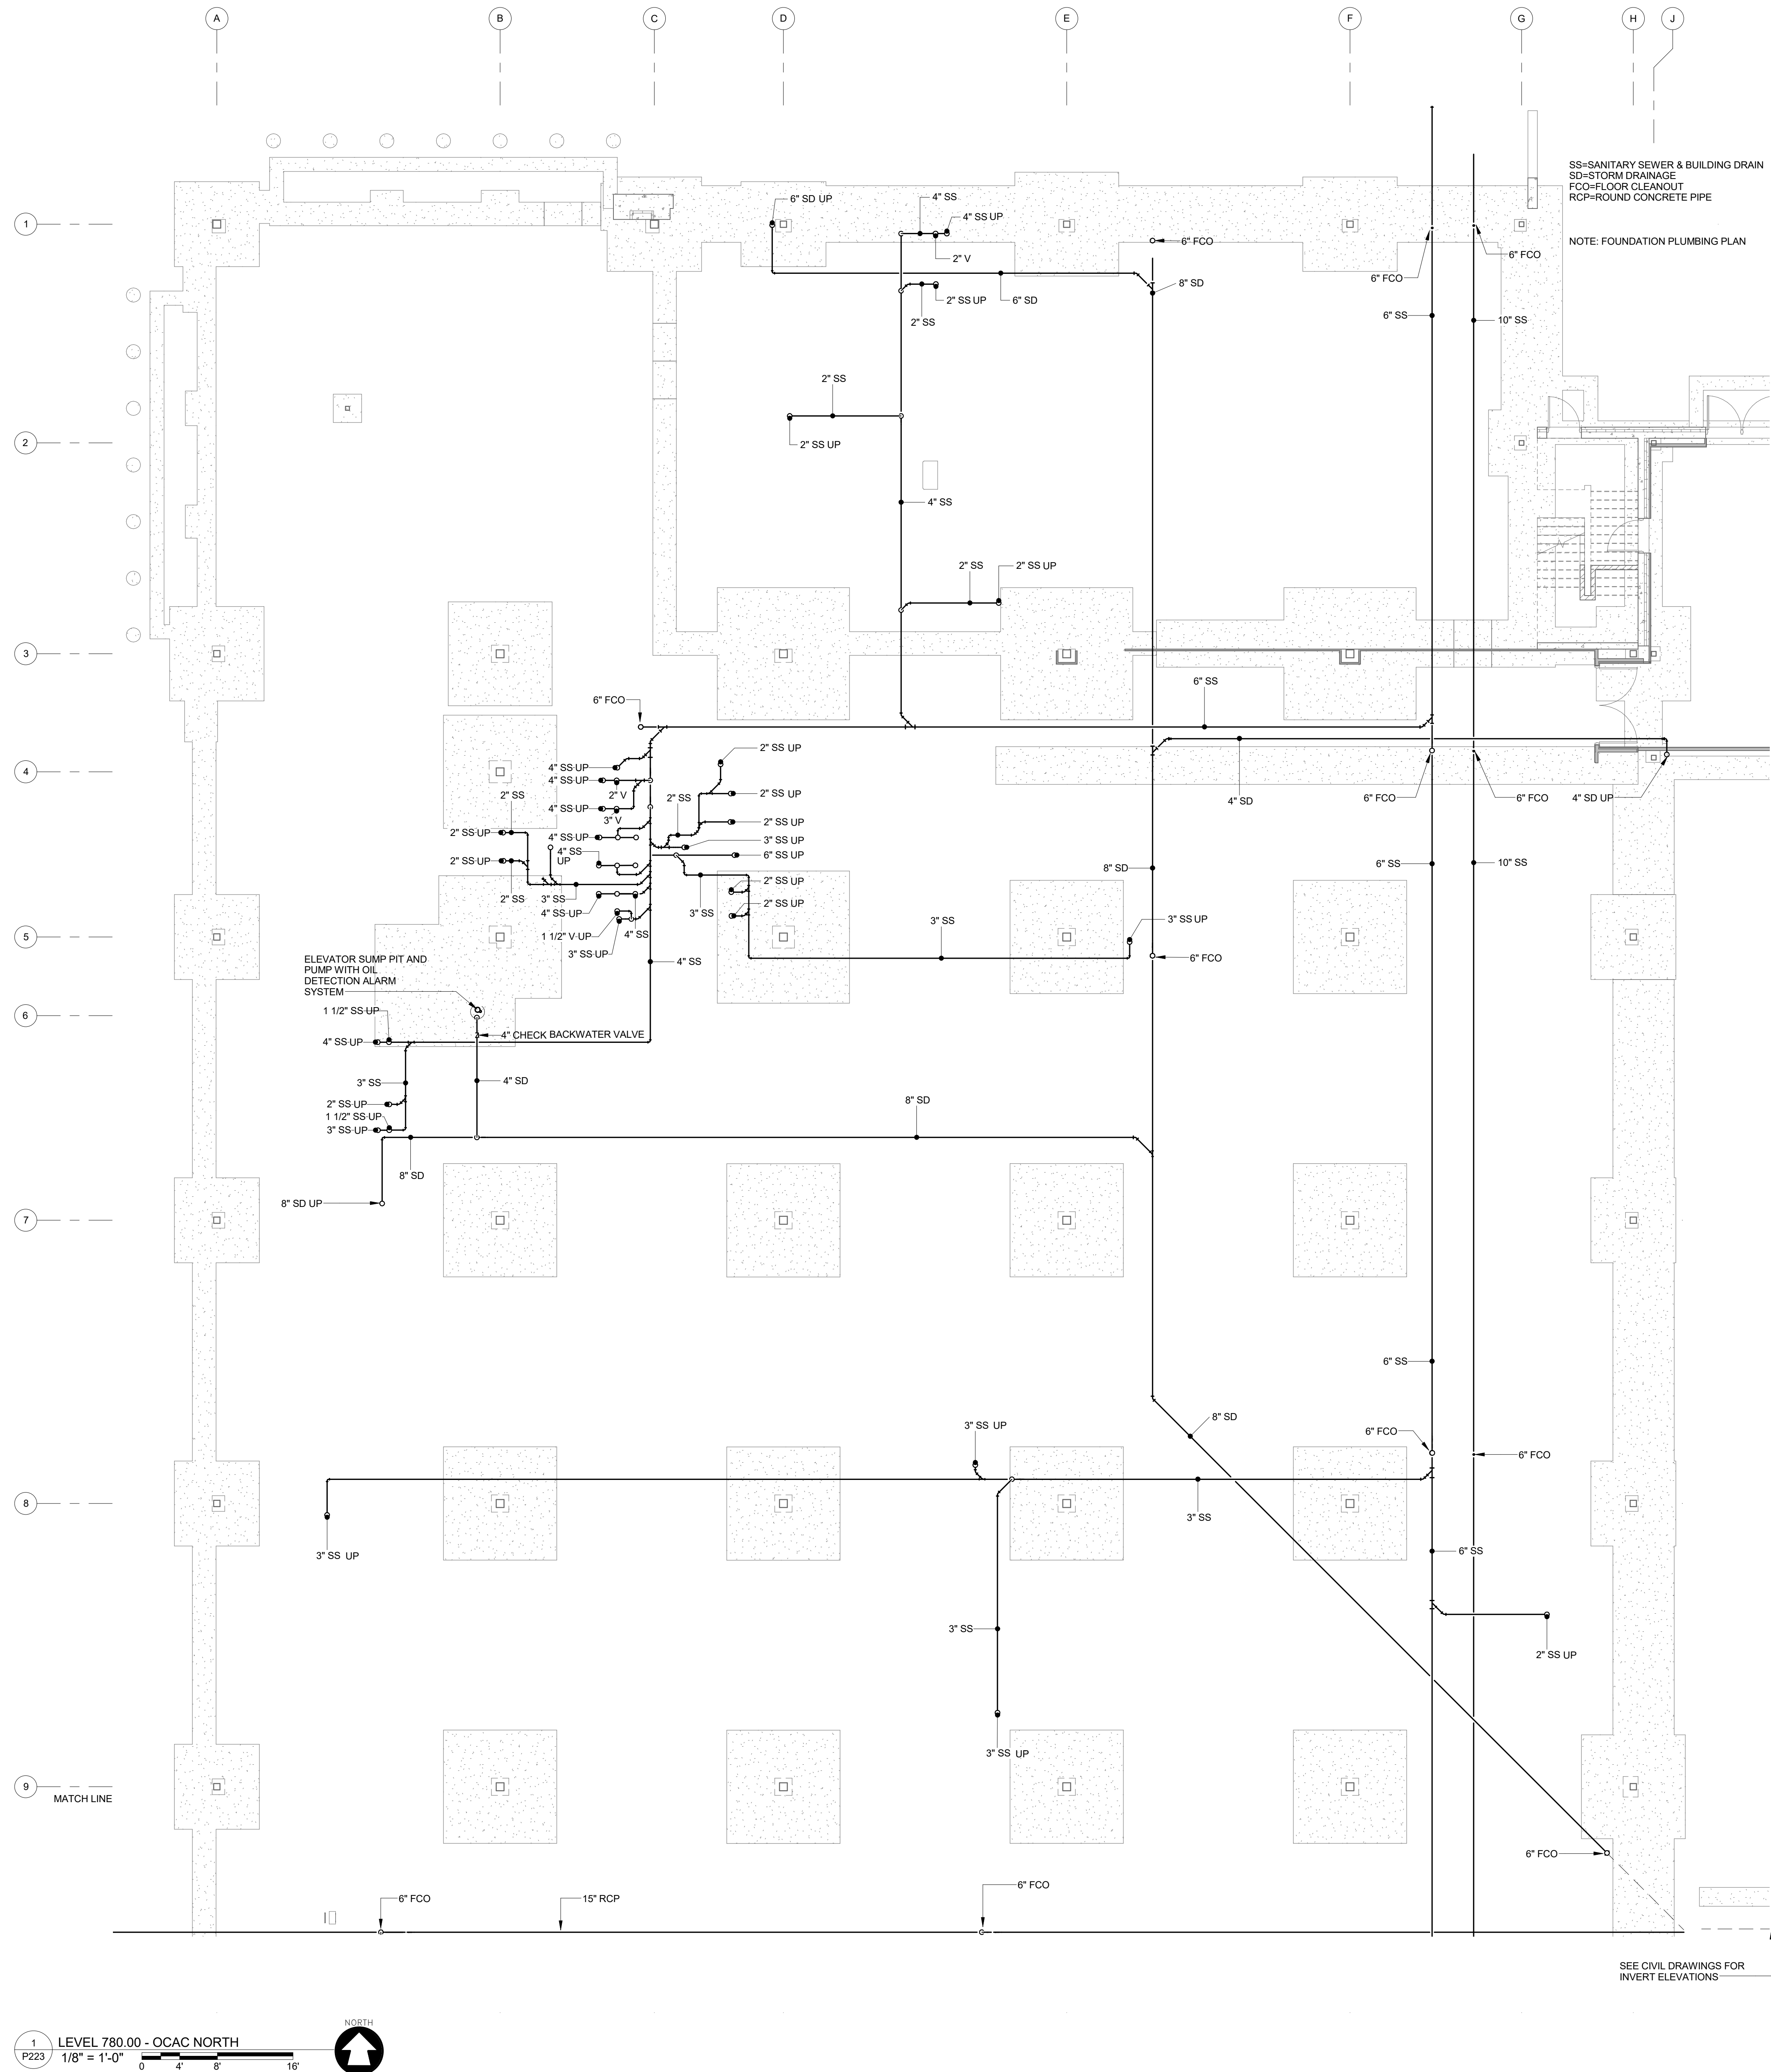


PLUMBING LEGEND

- CW = COLD WATER
- HW = HOT WATER
- HWR = HOT WATER RECIRCULATING
- SS = SANITARY DRAIN
- V = VENT
- SD = STORM DRAIN
- OSD = OVERFLOW STORM DRAIN
- CWD = CLEAR WATER DRAIN
- FD = FLOOR DRAIN
- FCO = FLOOR CLEANOUT
- CO = CLEAN OUT
- RD = ROOF DRAIN
- ORD = OVERFLOW ROOF DRAIN
- VTR = VENT THROUGH ROOF

SS=SANITARY SEWER & BUILDING DRAIN
SD=STORM DRAINAGE
FCO=FLOOR CLEANOUT
RCP=ROUND CONCRETE PIPE

NOTE: FOUNDATION PLUMBING PLAN

SEE CIVIL DRAWINGS FOR
INVERT ELEVATIONS

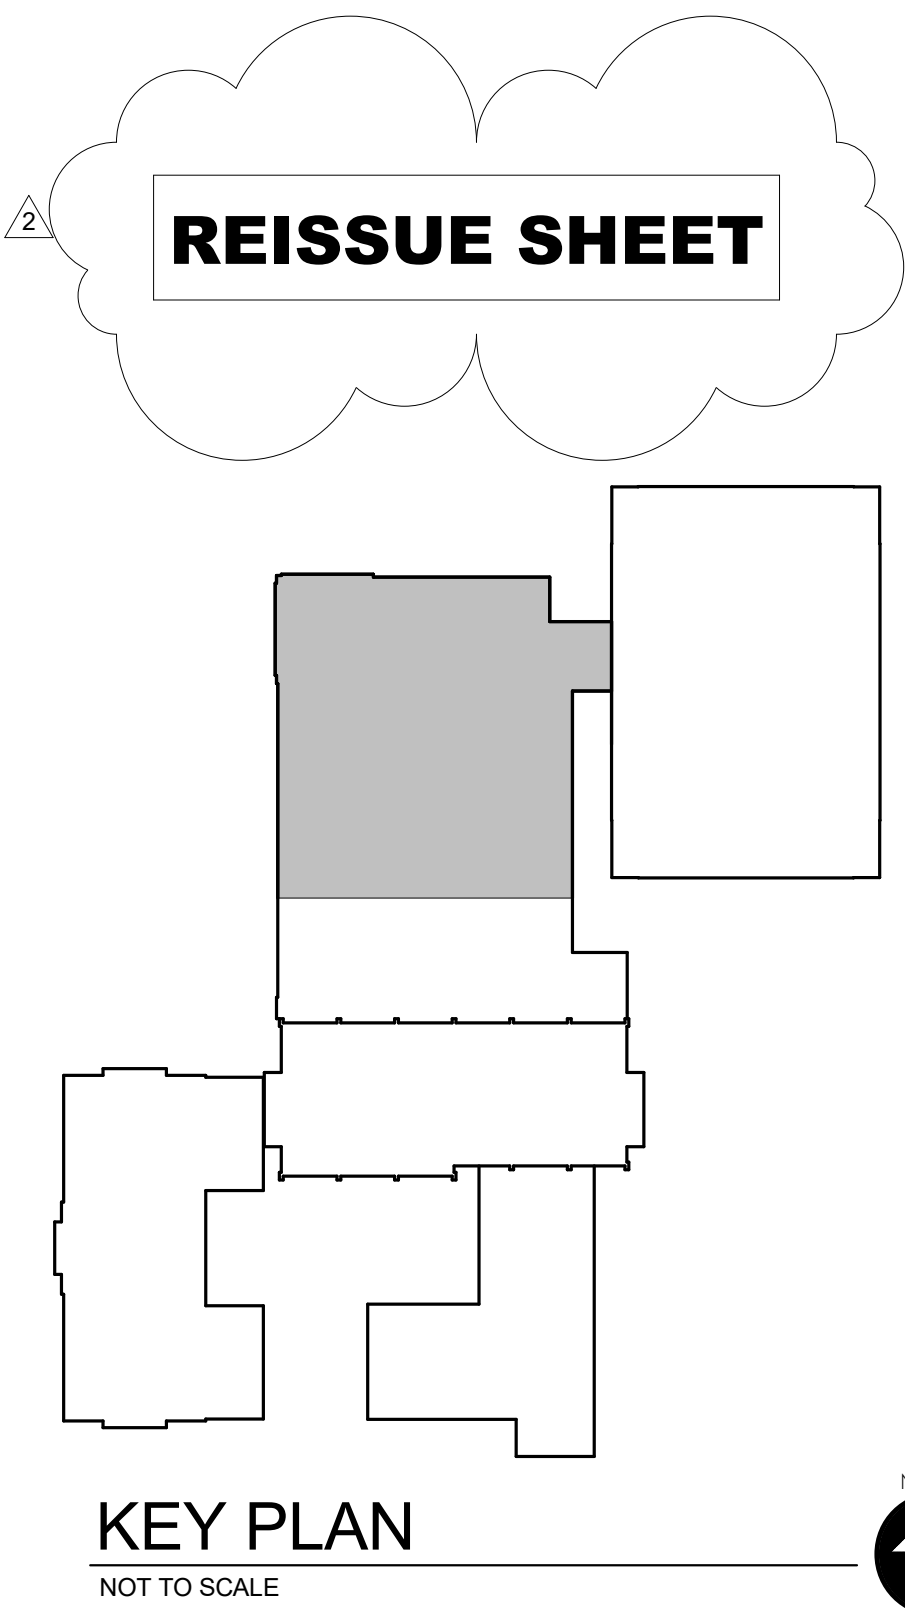

REISSUE SHEET

McMahon provides this drawing as instruments of service. All work is to be done in accordance with the contract documents. The client is responsible for obtaining all necessary permits and for the accuracy of the information provided. McMahon is not responsible for any errors or omissions in this drawing or for any consequences arising therefrom. Changes made to the original drawing must be approved by McMahon.

REVISION

ADDENDUM 2

DATE

NO

ALTERATION / ADDITION
OUTAGAMIE COUNTY ADMINISTRATION CENTER
S. WALNUT & W. 8TH, APPLETON, WI 54911
LEVEL 780.00 - ENLARGED PLUMBING PLAN - OCAC NORTH

DESIGNED

NDK

DRAWN

NDK

PROJECT NO.


00002-61600160

DATE

MARCH 3, 2017



SHEET NO.

P223

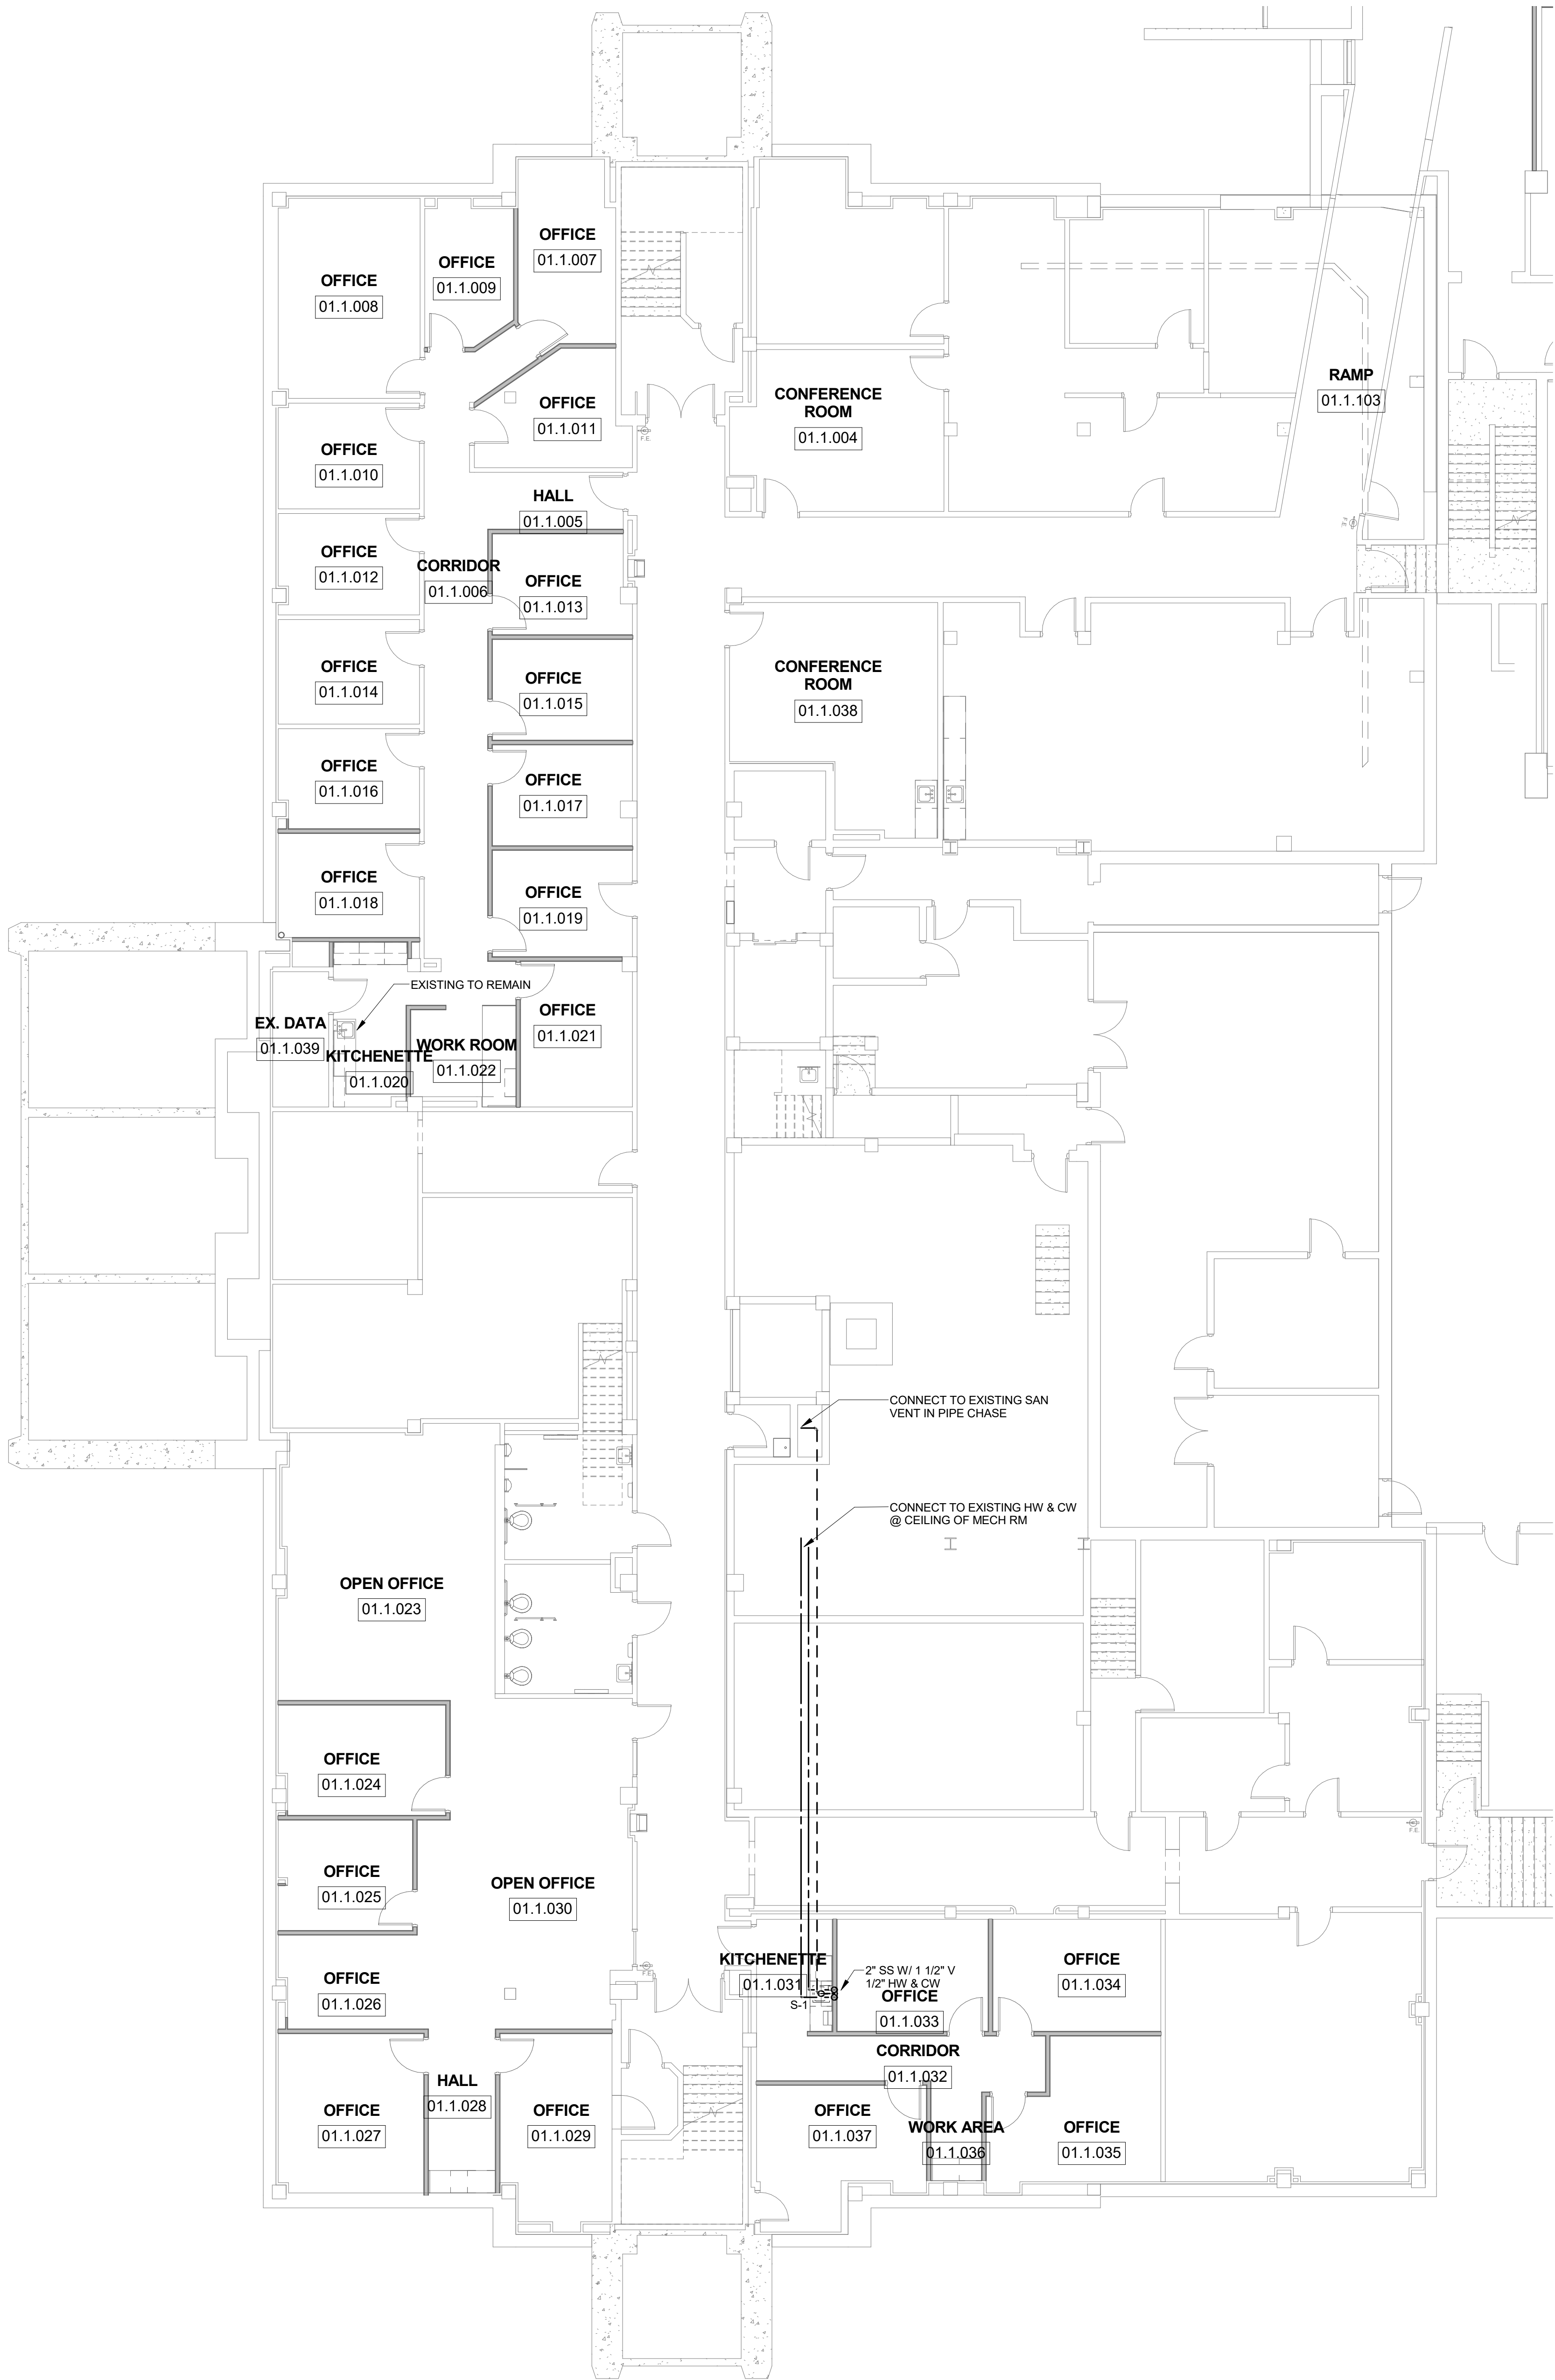

PLUMBING LEGEND

- CW = COLD WATER
- HW = HOT WATER
- HWR = HOT WATER RECIRCULATING
- SS = SANITARY DRAIN
- V = VENT
- SD = STORM DRAIN
- OSD = OVERFLOW STORM DRAIN
- CWD = CLEAR WATER DRAIN
- FD = FLOOR DRAIN
- FCO = FLOOR CLEANOUT
- CO = CLEAN OUT
- RD = ROOF DRAIN
- ORD = OVERFLOW ROOF DRAIN
- VTR = VENT THROUGH ROOF

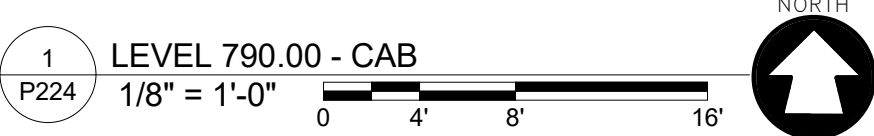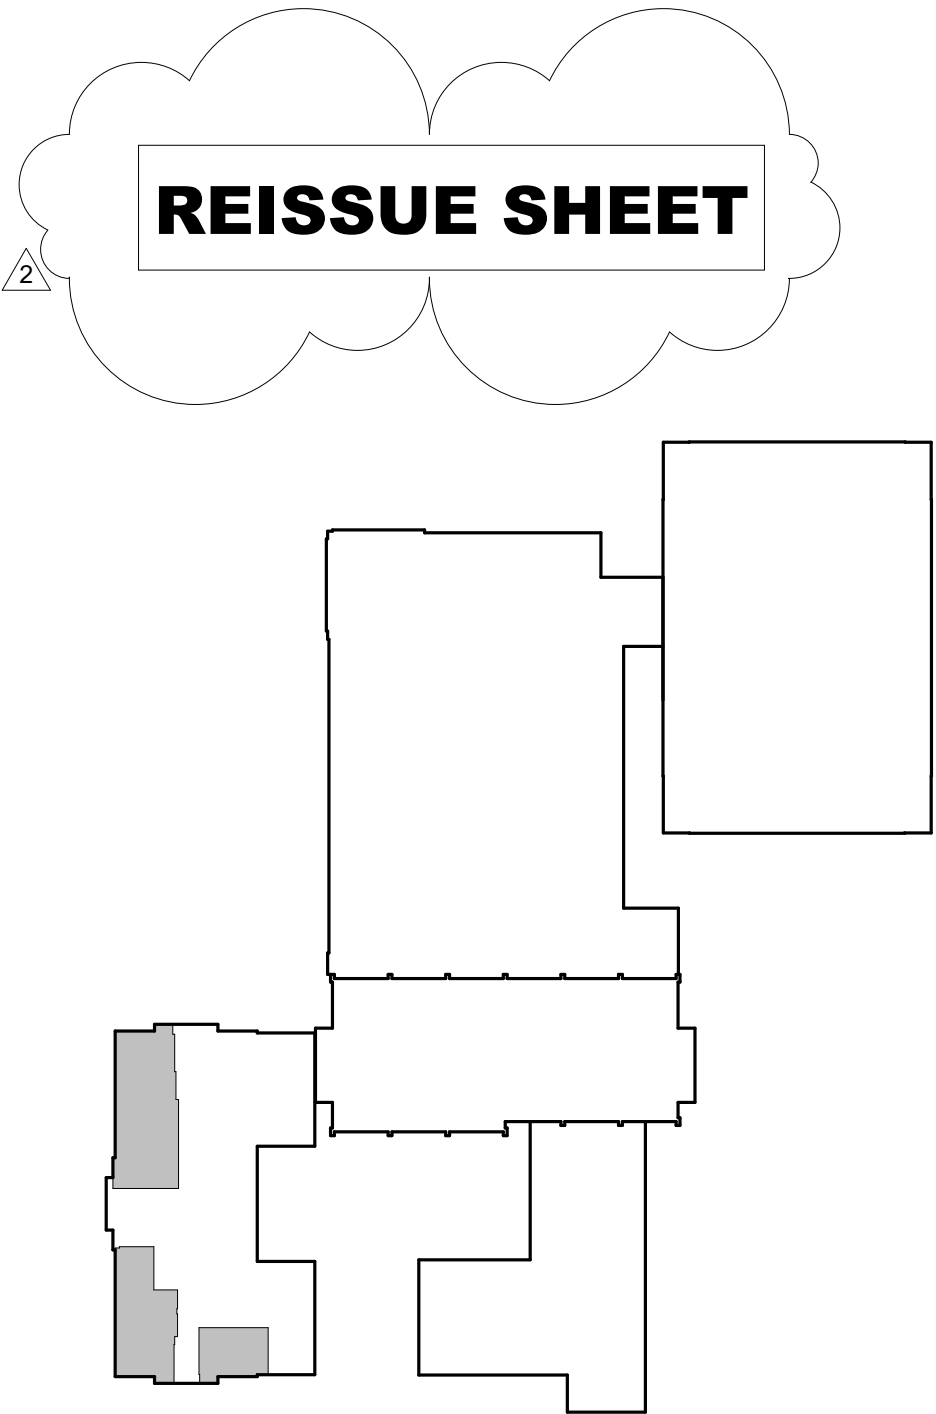


KEY PLAN
NOT TO SCALE

McMahon provides this drawing as instruments of service. All work shown herein shall be performed in accordance with the latest edition of the applicable codes and standards. The client is responsible for obtaining all necessary permits and for the accuracy of the information provided. McMahon is not responsible for any errors or omissions in this drawing or for any consequences arising therefrom.

REVISION	
NO.	DATE
2	4/6/17
ADDENDUM 2	


ALTERATION / ADDITION
OUTAGAMIE COUNTY ADMINISTRATION CENTER
S. WALNUT & W. 8TH, APPLETON, WI 54911
LEVEL 790.00 - ENLARGED PLUMBING PLAN - CAB

DESIGNED	DRAWN
NDK	NDK
PROJECT NO.	
00002-61600160	
DATE	
MARCH 3, 2017	
SHEET NO.	
P224	

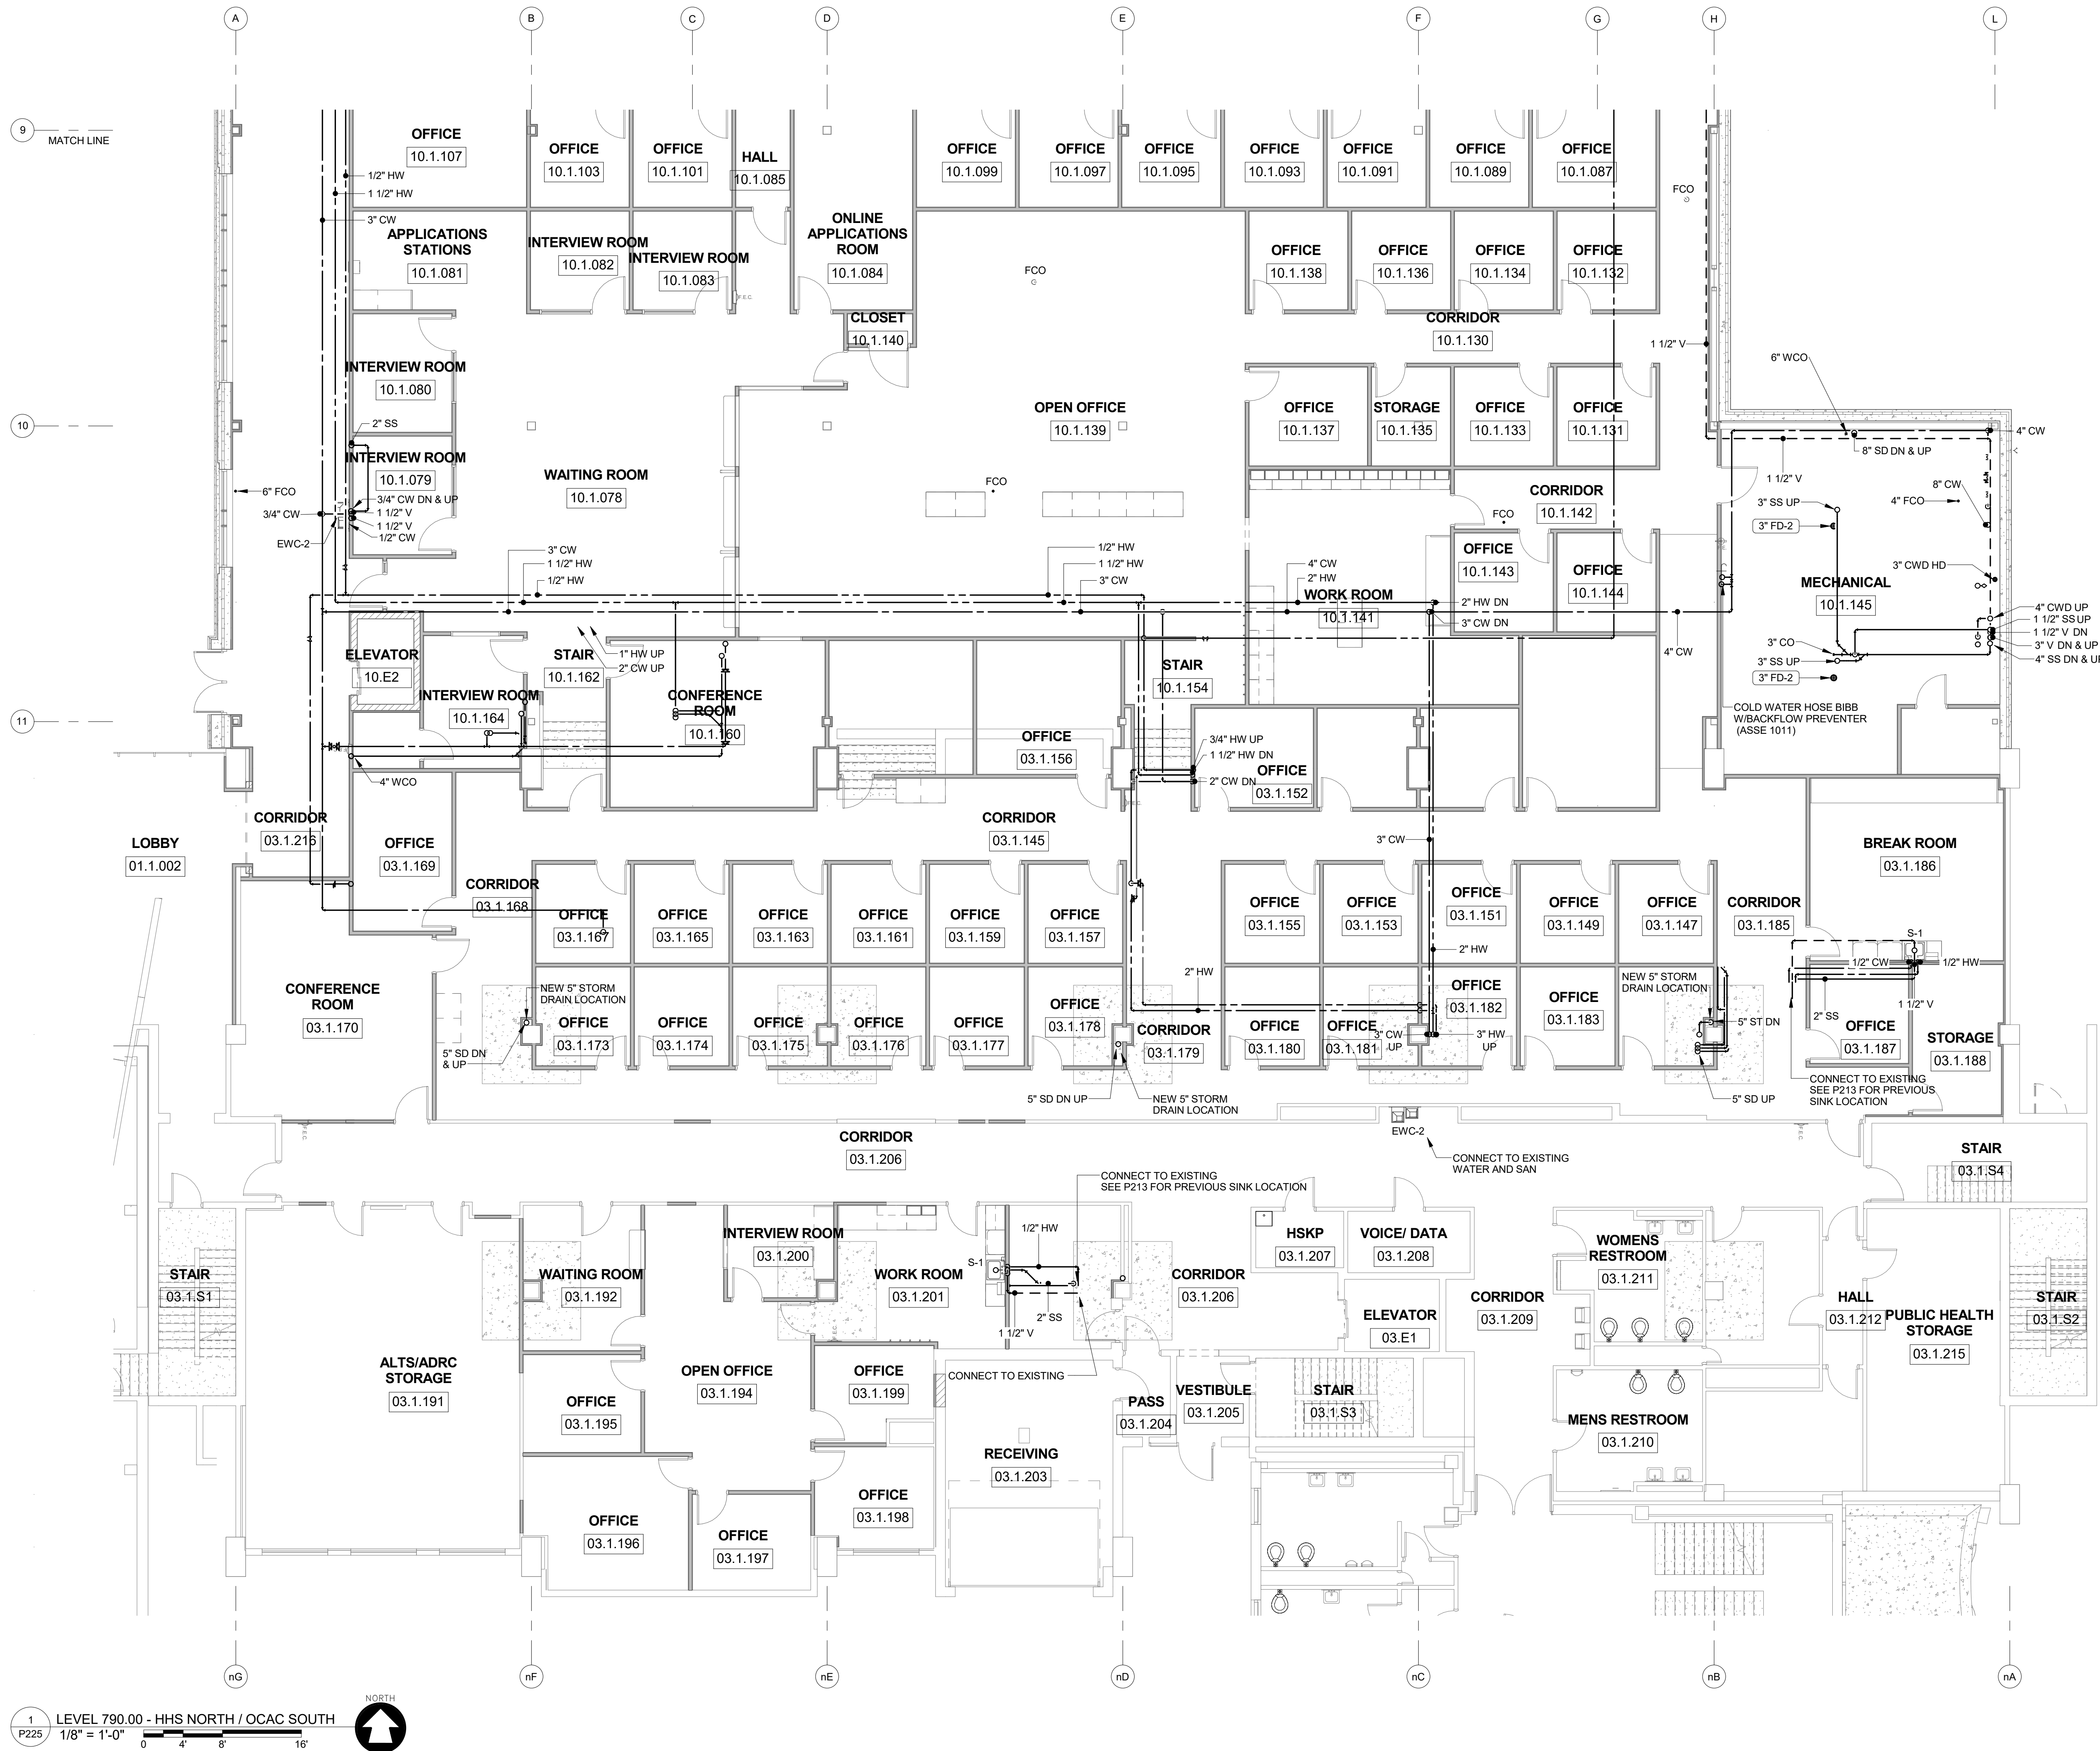

PLUMBING LEGEND

- CW = COLD WATER
- HW = HOT WATER
- HWR = HOT WATER RECIRCULATING
- SS = SANITARY DRAIN
- V = VENT
- SD = STORM DRAIN
- OSD = OVERFLOW STORM DRAIN
- CWD = CLEAR WATER DRAIN
- FD = FLOOR DRAIN
- FCO = FLOOR CLEANOUT
- CO = CLEAN OUT
- RD = ROOF DRAIN
- ORD = OVERFLOW ROOF DRAIN
- VTR = VENT THROUGH ROOF

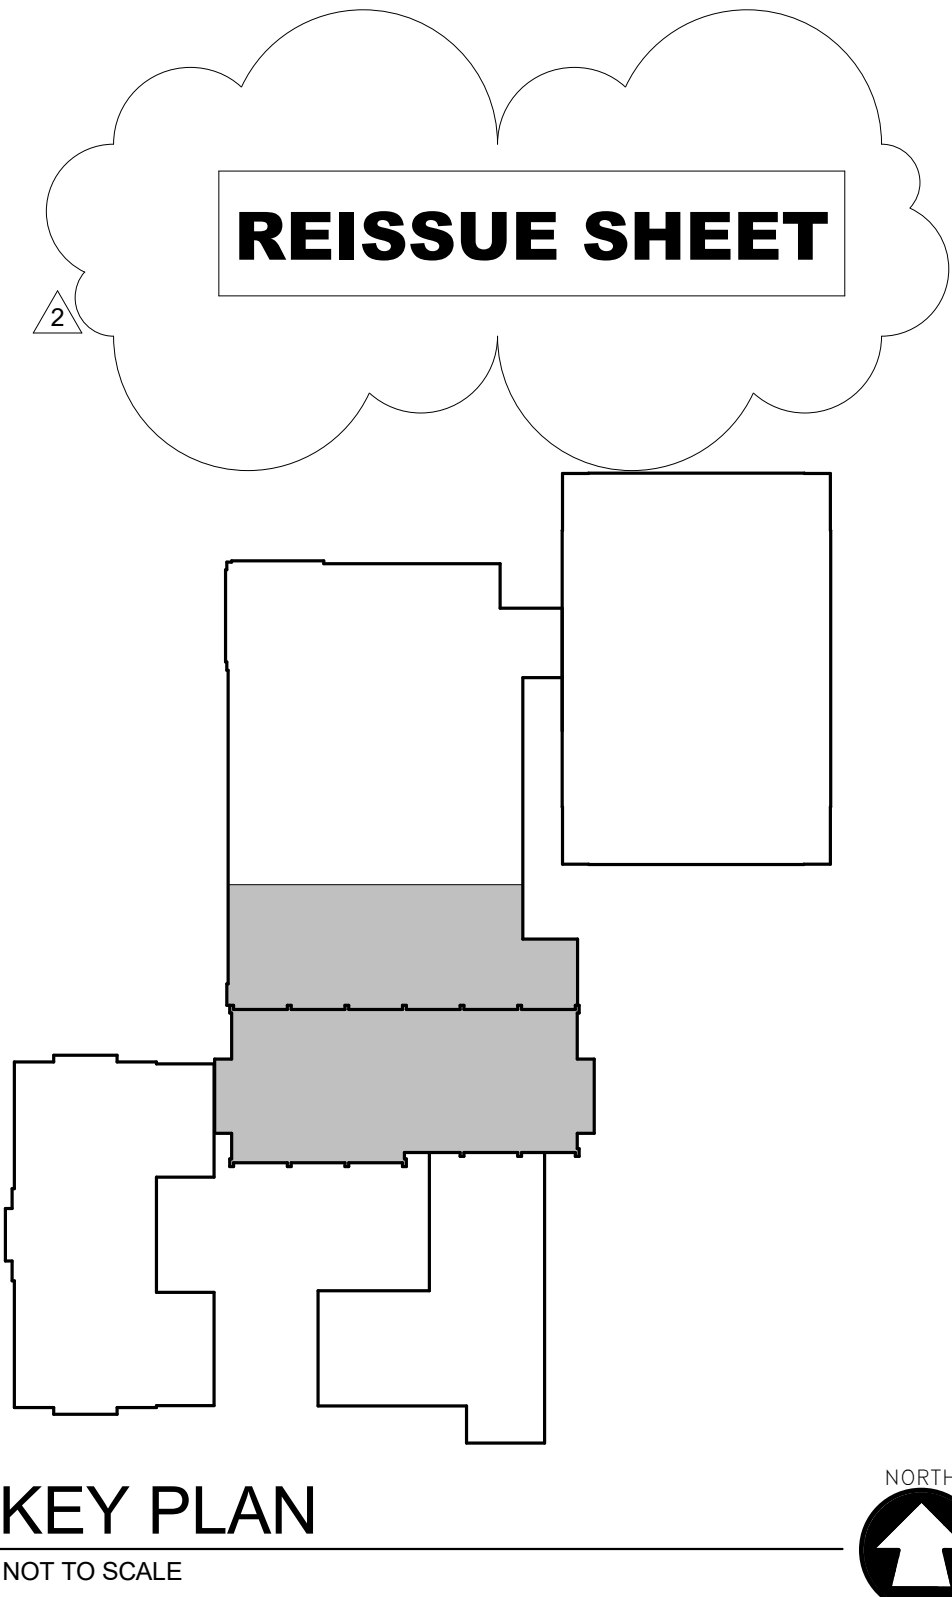


McMahon provides this drawing as instruments of service. All work shall be in accordance with the contract documents and the applicable codes and regulations. The client is responsible for obtaining all necessary permits and for the accuracy of the information provided. McMahon is not responsible for any errors or omissions in this drawing or for any consequences arising therefrom.



REVISION	DATE	BY	NO.
ADDITION 2	4/4/17		2

ALTERATION / ADDITION
OUTAGAMIE COUNTY ADMINISTRATION CENTER
S. WALNUT & W. 8TH, APPLETON, WI 54911
LEVEL 790.00 - ENLARGED PLUMBING PLAN - HHS NORTH / OCAC SOUTH

DESIGNED	DRAWN
NDK	NDK
PROJECT NO.	
00002-61600160	
DATE	
MARCH 3, 2017	
SHEET NO.	

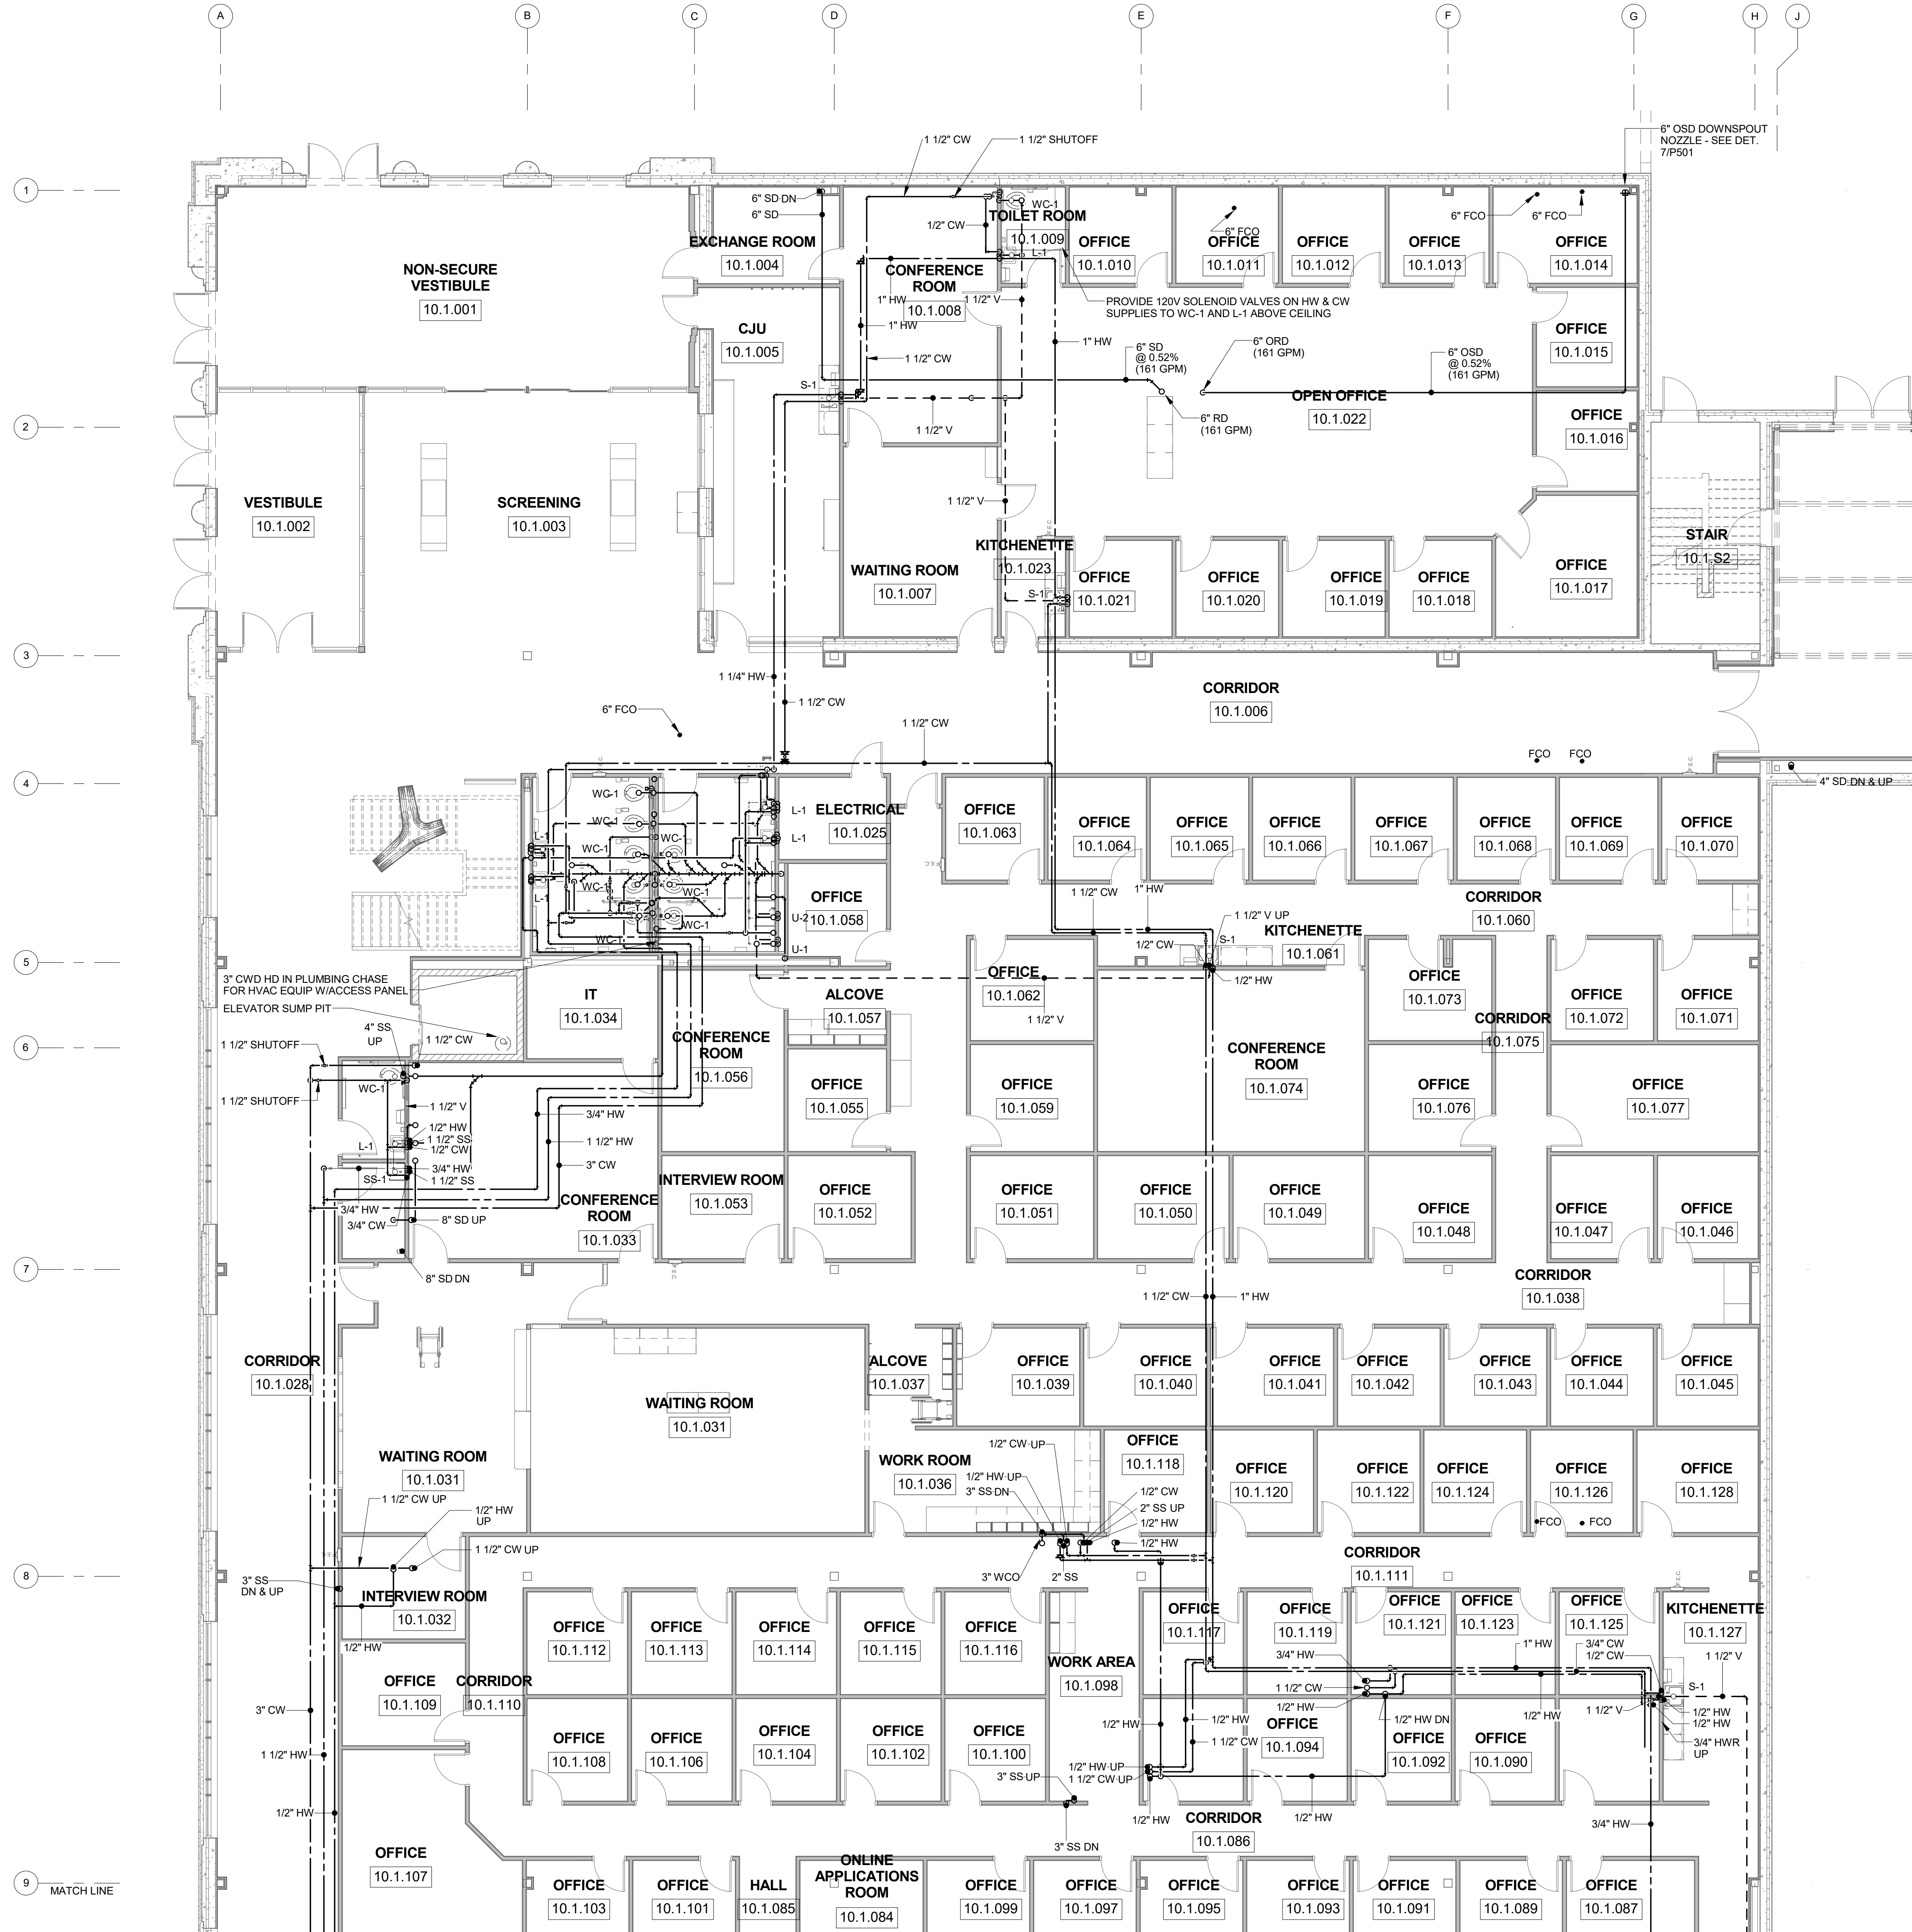

1
P226
LEVEL 790.00 - OCAC NORTH
1/8" = 1'-0"

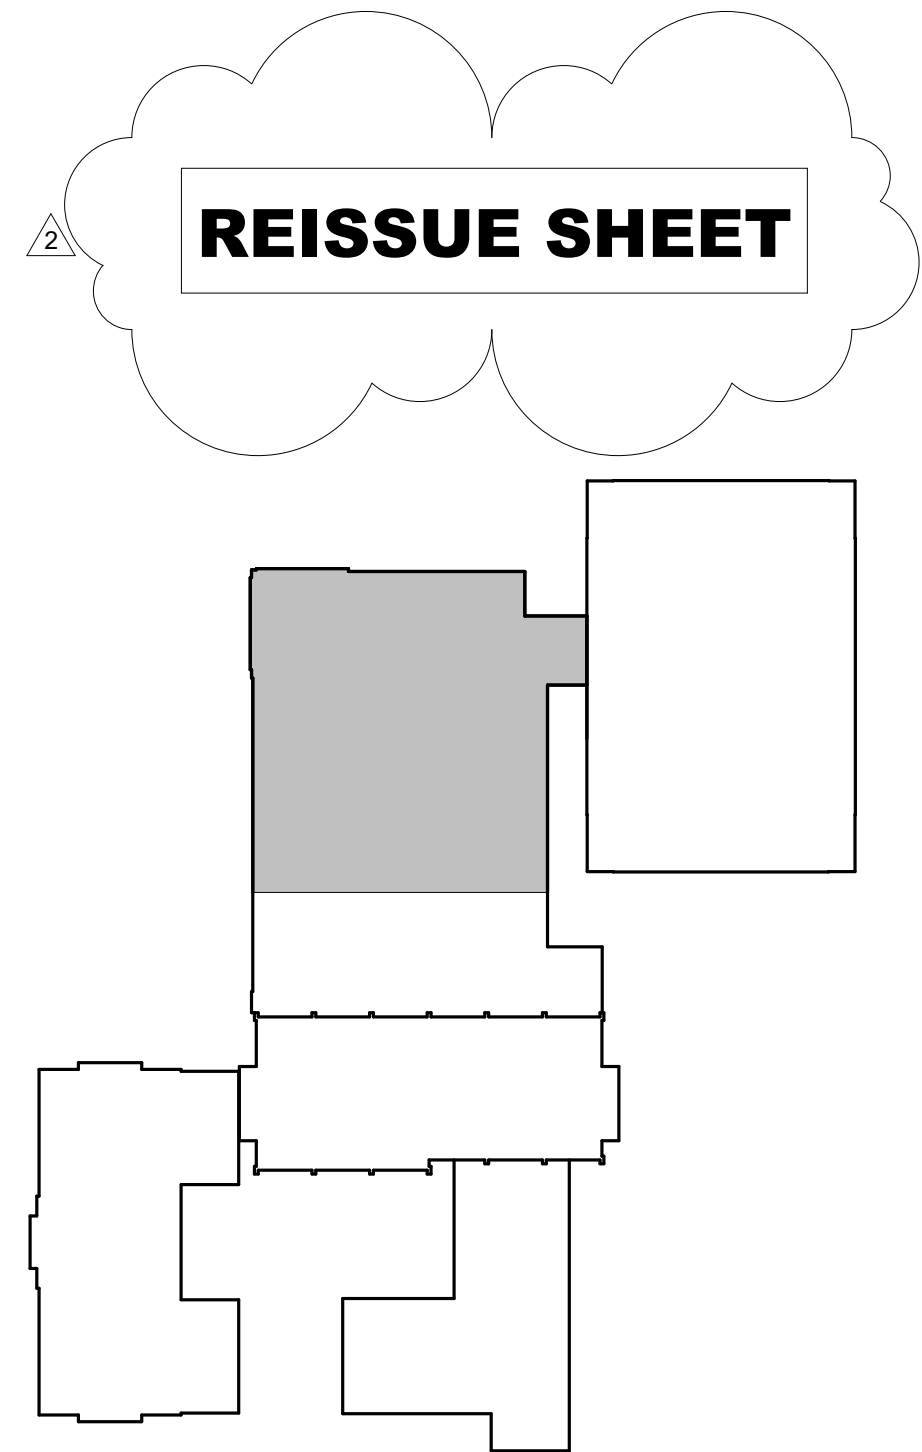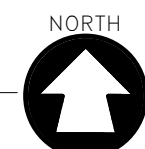

KEY PLAN
NOT TO SCALE



PLUMBING LEGEND


- CW = COLD WATER
- HW = HOT WATER
- HWR = HOT WATER RECIRCULATING
- SS = SANITARY DRAIN
- V = VENT
- SD = STORM DRAIN
- OSD = OVERFLOW STORM DRAIN
- CWD = CLEAR WATER DRAIN
- FD = FLOOR DRAIN
- FCO = FLOOR CLEANOUT
- CO = CLEAN OUT
- RD = ROOF DRAIN
- ORD = OVERFLOW ROOF DRAIN
- VTR = VENT THROUGH ROOF

McMahon provides this drawing as instruments of service. All work shall be in accordance with the contract documents and the applicable laws and regulations. The client is responsible for obtaining all necessary permits and approvals. McMahon is not responsible for any errors or omissions in this drawing or for any consequences arising therefrom.

NO.	DATE	REVISION
1	4/4/17	ADDENDUM 2
2		

ALTERATION / ADDITION
OUTAGAMIE COUNTY ADMINISTRATION CENTER
S. WALNUT & W. 8TH, APPLETON, WI 54911
LEVEL 790.00 - ENLARGED PLUMBING PLAN - OCAC NORTH

DESIGNED	DRAWN
NDK	NDK
PROJECT NO.	00002-61600160
DATE	MARCH 3, 2017
SHEET NO.	

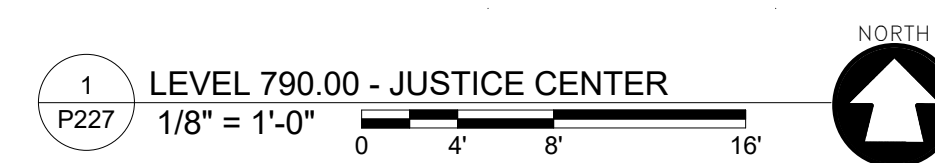


CW	=	COLD WATER
HW	=	HOT WATER
HW R	=	HOT WATER RECIRCULATING
SS	=	SANITARY DRAIN
V	=	VENT
SD	=	STORM DRAIN
OSD	=	OVERFLOW STORM DRAIN
CWD	=	CLEAR WATER DRAIN
FD	=	FLOOR DRAIN
FCO	=	FLOOR CLEANOUT
CO	=	CLEAN OUT
RD	=	ROOF DRAIN
ORD	=	OVERFLOW ROOF DRAIN
VTR	=	VENT THROUGH ROOF

[illegible]

ALTERATION / ADDITION
OUTAGAMIE COUNTY ADMINISTRATION CENTER
S. WALNUT & W. 8TH, APPLETON, WI 54911
LEVEL 790.00 - ENLARGED PLUMBING PLAN - JUSTICE CENTER


DESIGNED	DRAWN
NDK	NDK
PROJECT NO.	
O0002-61600160	
DATE	
MARCH 3, 2017	
SHEET NO.	

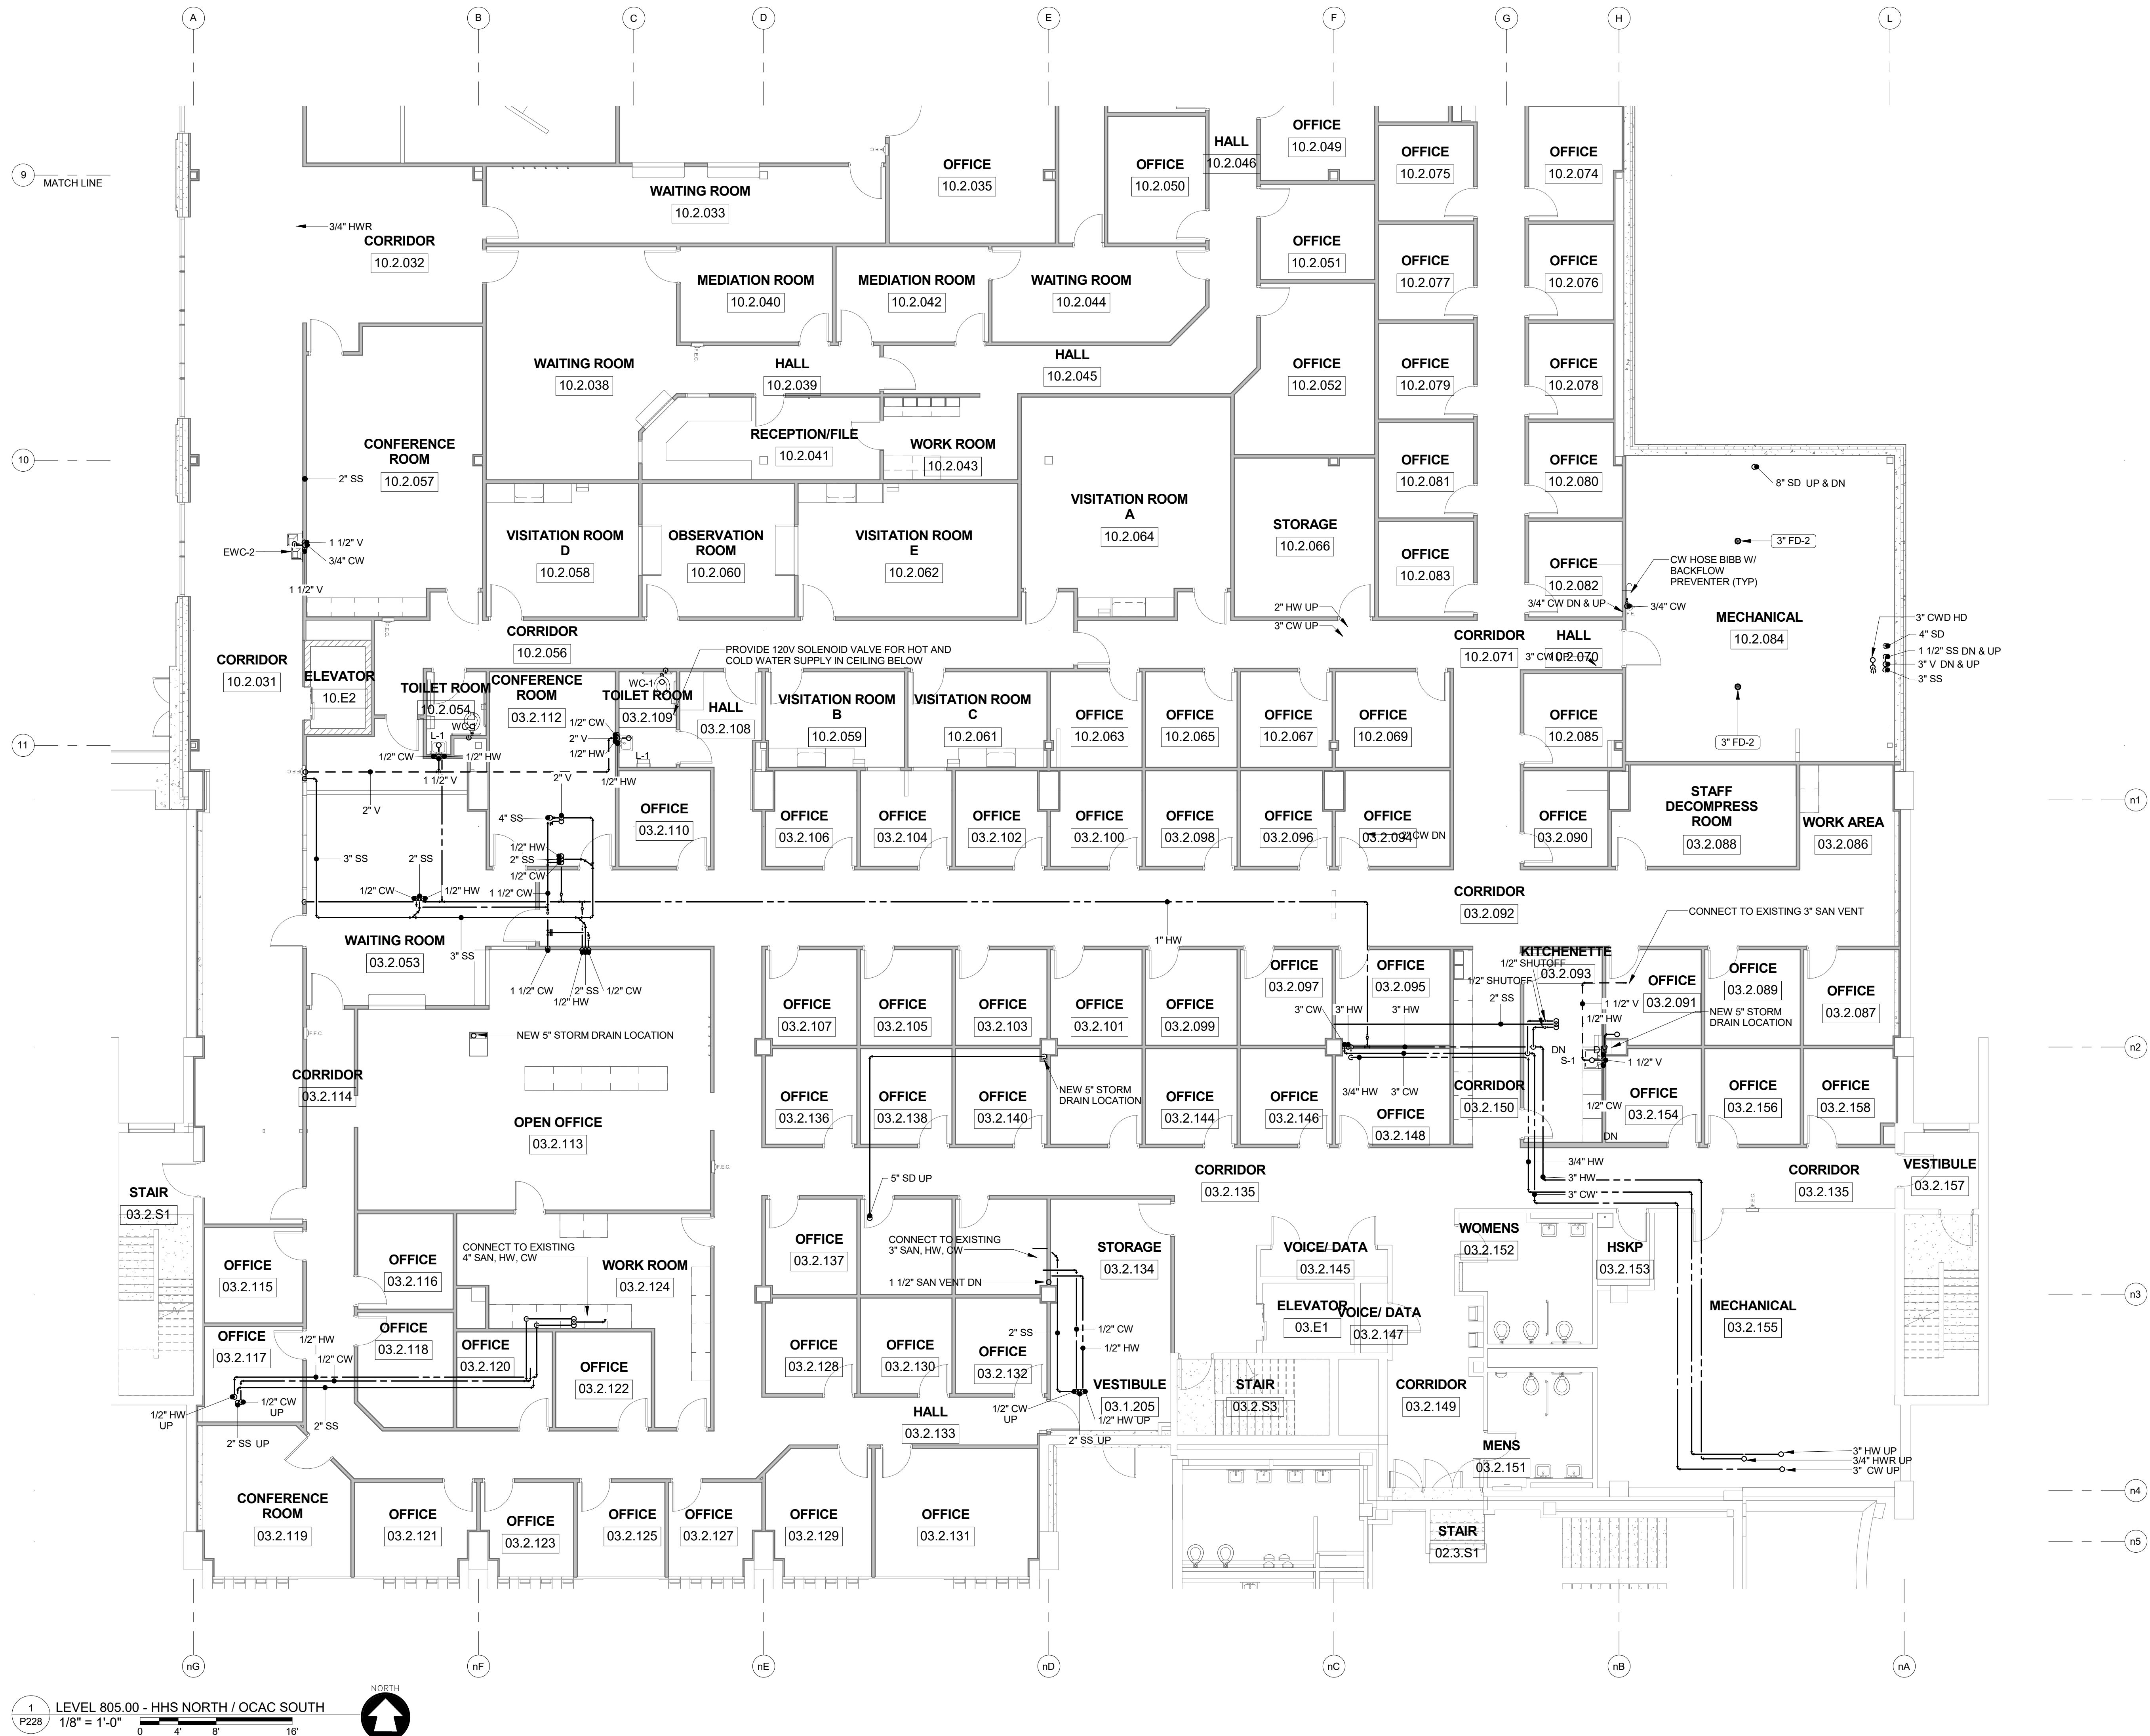

PLUMBING LEGEND

- CW = COLD WATER
- HW = HOT WATER
- HWR = HOT WATER RECIRCULATING
- SS = SANITARY DRAIN
- V = VENT
- SD = STORM DRAIN
- OSD = OVERFLOW STORM DRAIN
- CWD = CLEAR WATER DRAIN
- FD = FLOOR DRAIN
- FCO = FLOOR CLEANOUT
- CO = CLEAN OUT
- RD = ROOF DRAIN
- ORD = OVERFLOW ROOF DRAIN
- VTR = VENT THROUGH ROOF

REISSUE SHEET

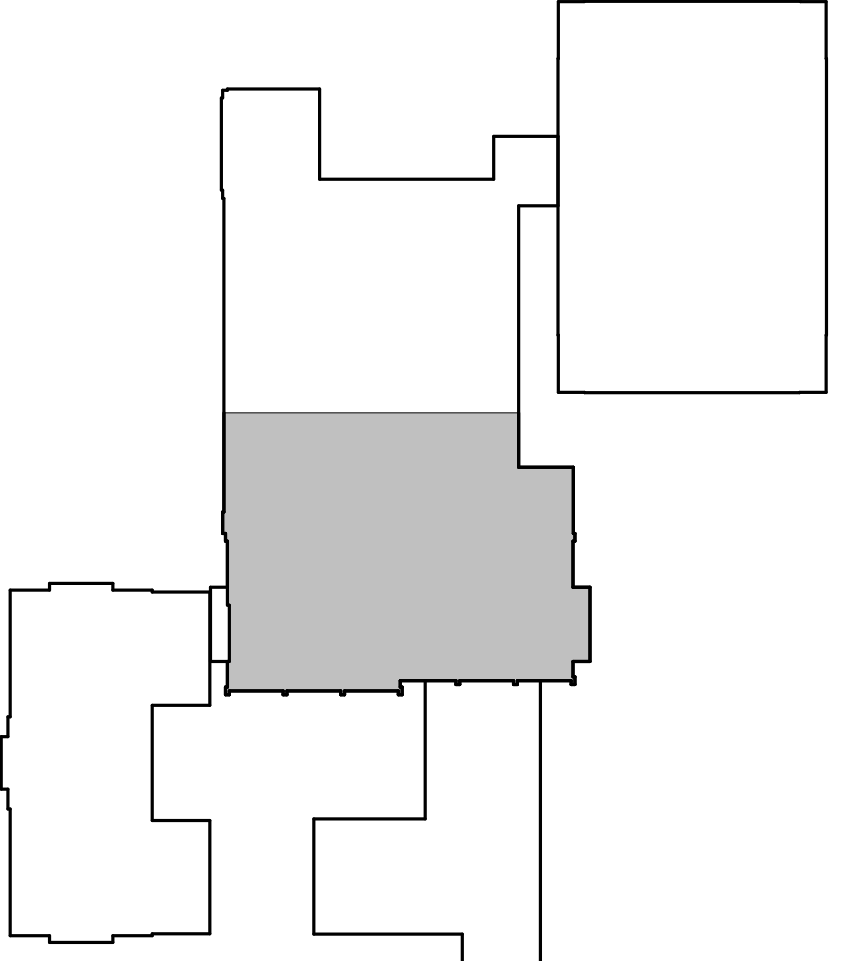



KEY PLAN
NOT TO SCALE

McMahon provides this drawing as a service to the client. It is not to be used for any other purpose without the written consent of McMahon. The client is responsible for obtaining all necessary permits and for the accuracy of the information provided. McMahon is not responsible for any errors or omissions in this drawing.

REVISION
1
2
3
100



ALTERATION / ADDITION
OUTAGAMIE COUNTY ADMINISTRATION CENTER
S. WALNUT & W. 8TH, APPLETON, WI 54911
LEVEL 805.00 - ENLARGED PLUMBING PLAN - HHS NORTH / OCAC SOUTH

DESIGNED	DRAWN
NDK	NDK
PROJECT NO.	00002-61600160
DATE	MARCH 3, 2017
SHEET NO.	P228

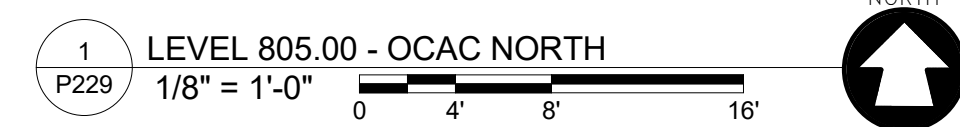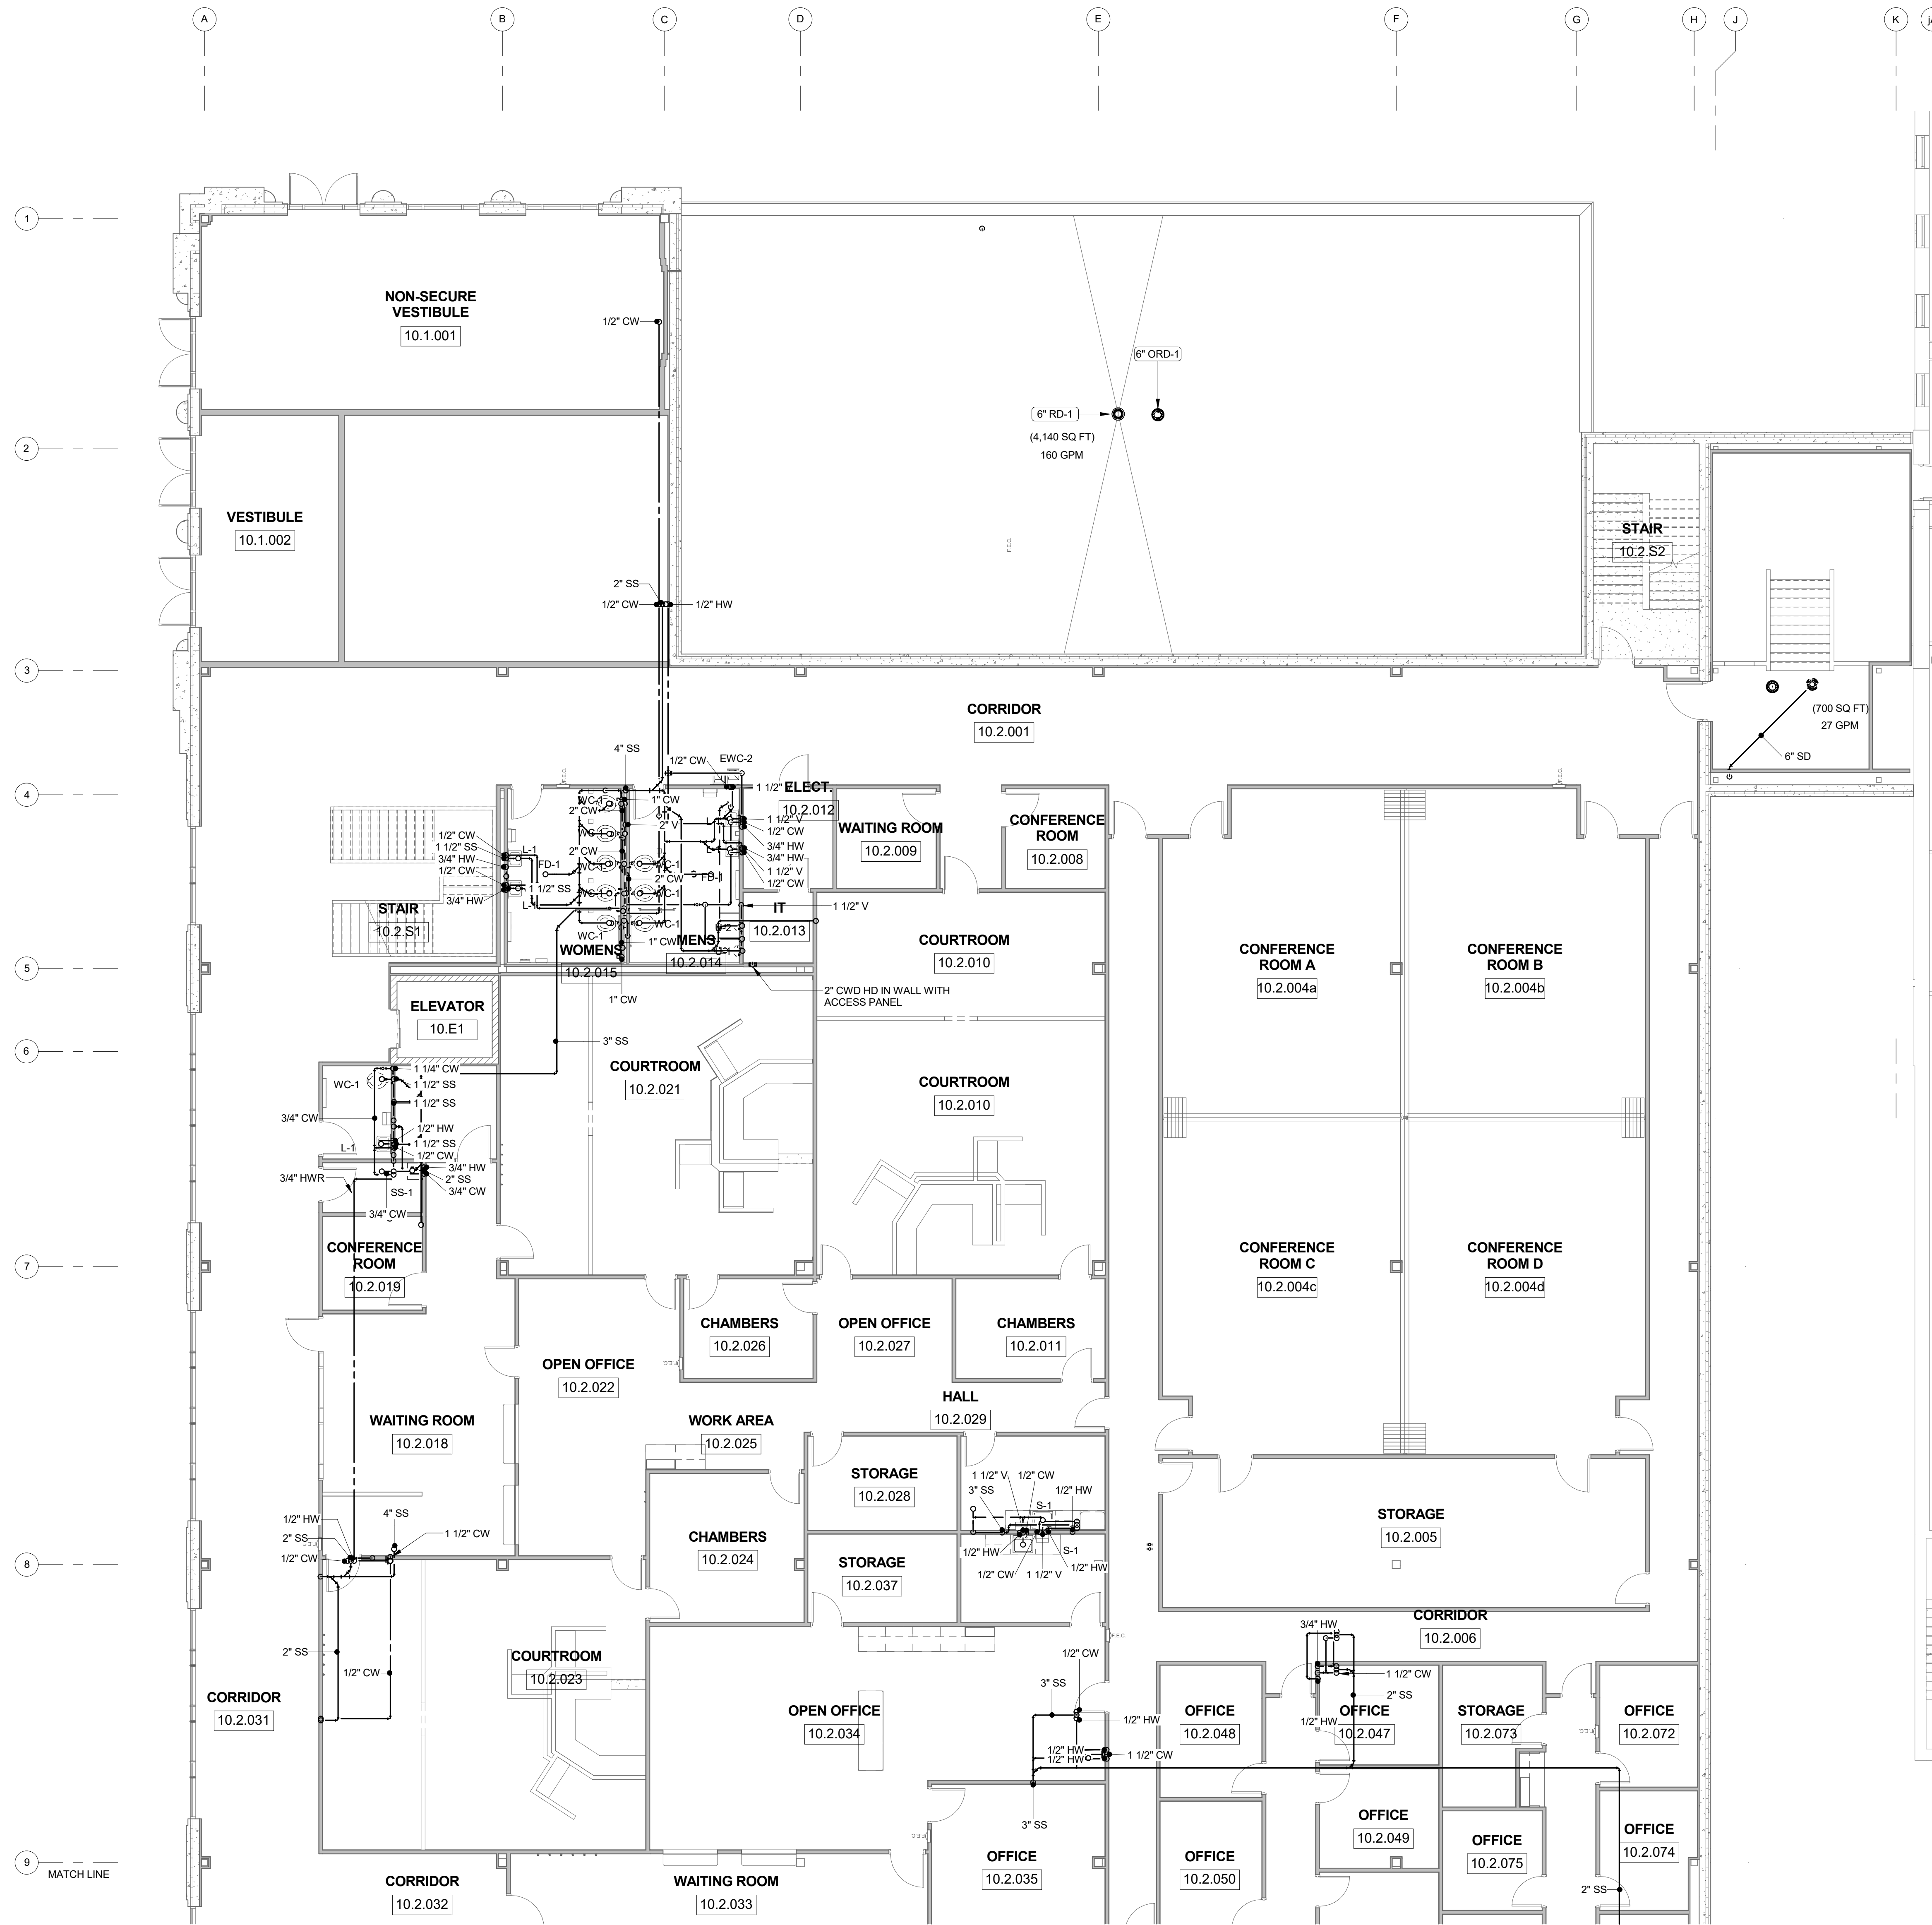


PLUMBING LEGEND

- CW = COLD WATER
- HW = HOT WATER
- HWR = HOT WATER RECIRCULATING
- SS = SANITARY DRAIN
- V = VENT
- SD = STORM DRAIN
- OSD = OVERFLOW STORM DRAIN
- CWD = CLEAR WATER DRAIN
- FD = FLOOR DRAIN
- FCO = FLOOR CLEANOUT
- CO = CLEAN OUT
- RD = ROOF DRAIN
- ORD = OVERFLOW ROOF DRAIN
- VTR = VENT THROUGH ROOF

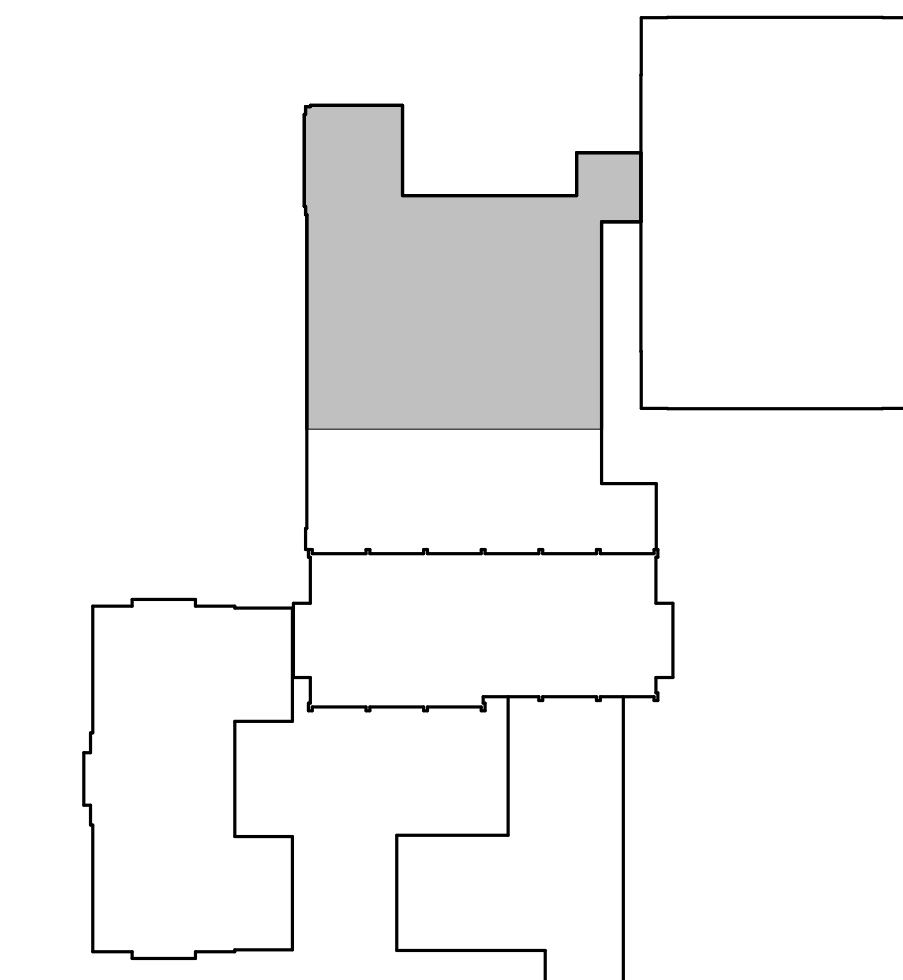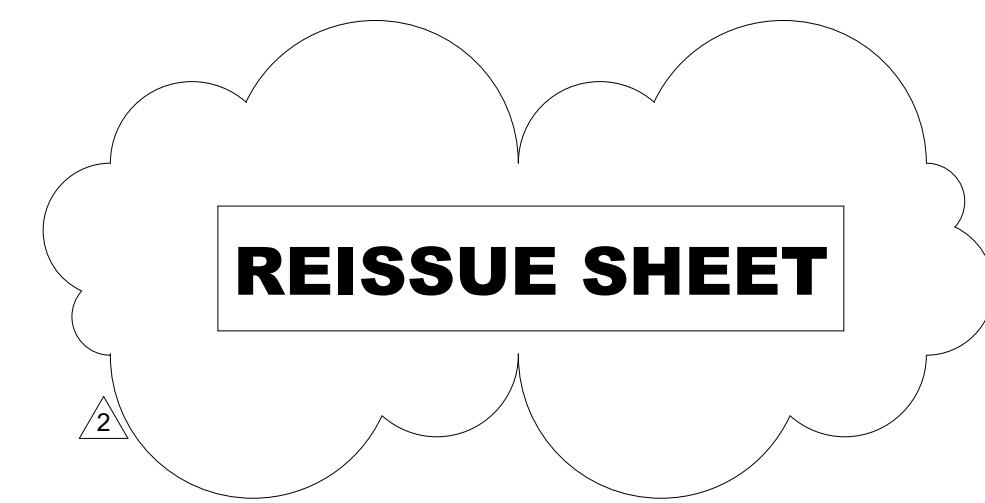

KEY PLAN
NOT TO SCALE

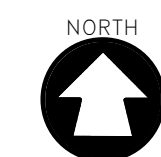


McMahon provides this drawing as instruments of service. All work shall be in accordance with the contract documents. The client shall be responsible for obtaining all necessary permits and for the accuracy of the information provided. McMahon shall not be responsible for any errors or omissions. McMahon reserves the right to make changes to this drawing without notice.

NO.	DATE	REVISION
2	4/9/17	ADDENDUM 2

ALTERATION / ADDITION
OUTAGAMIE COUNTY ADMINISTRATION CENTER
S. WALNUT & W. 8TH, APPLETON, WI 54911
LEVEL 805.00 - ENLARGED PLUMBING PLAN - OCAC NORTH


DESIGNED NDK	DRAWN NDK
PROJECT NO. 00002-61600160	
DATE MARCH 3, 2017	
SHEET NO. P229	

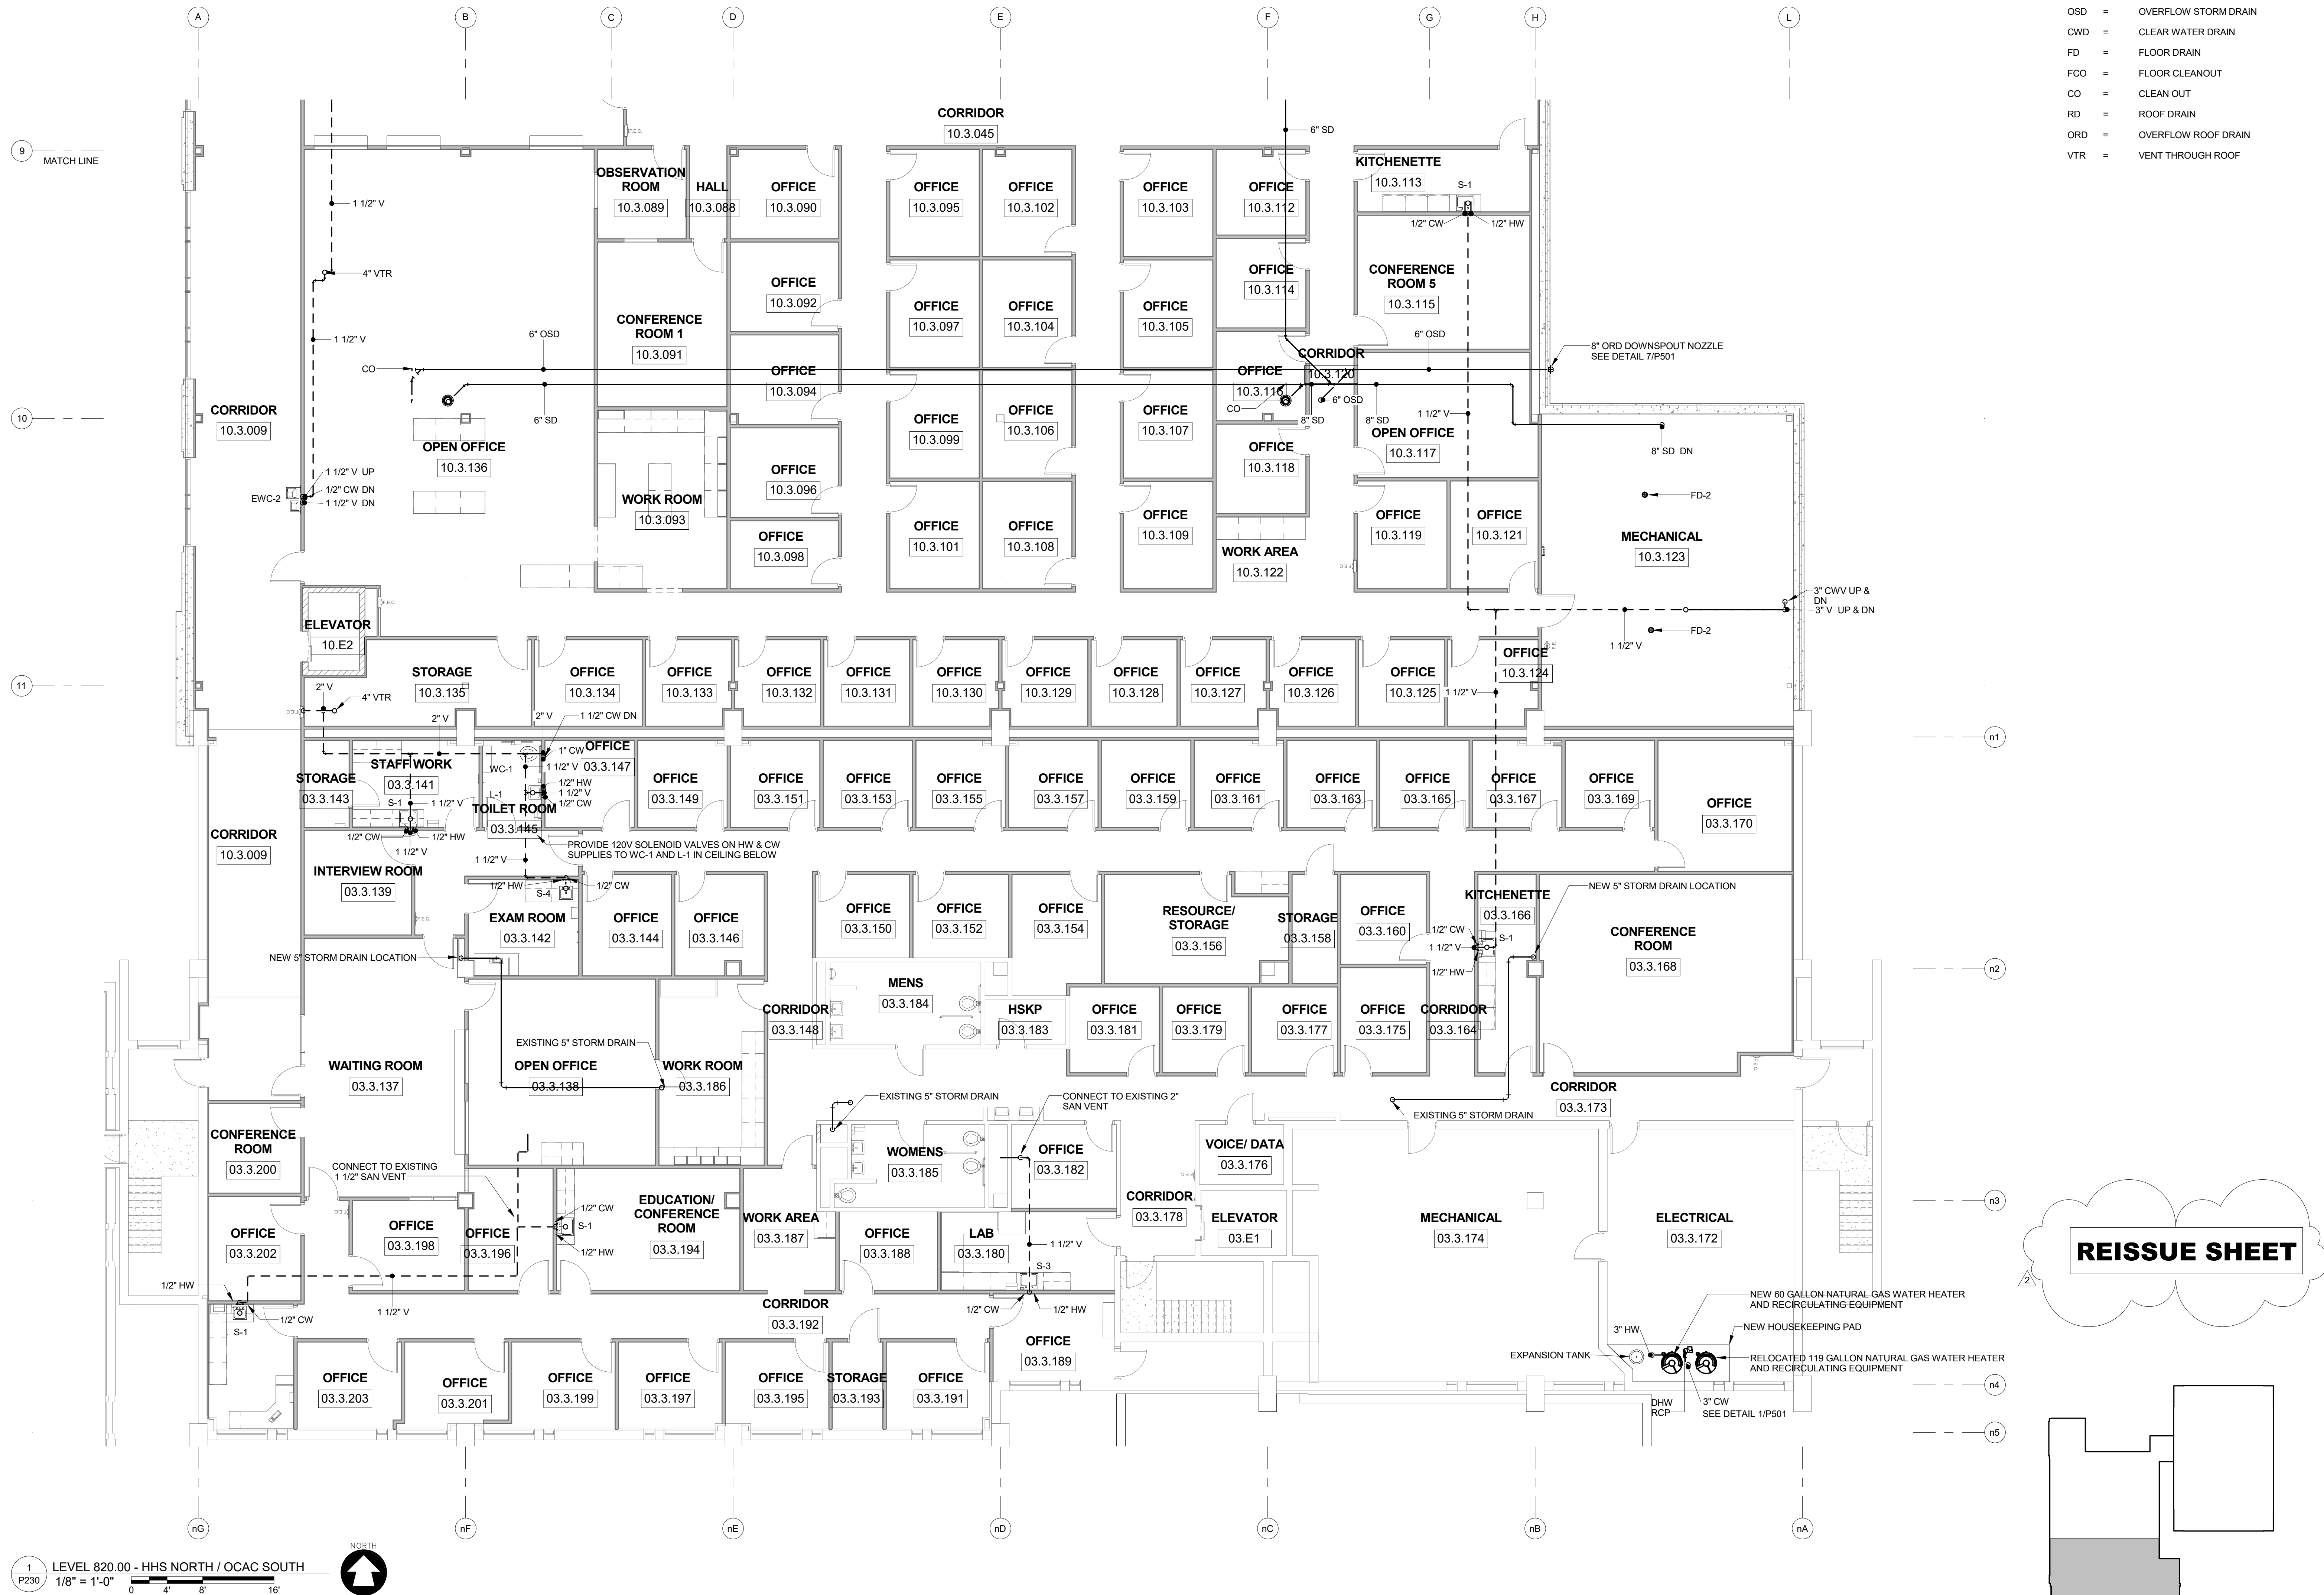

PLUMBING LEGEND

- CW = COLD WATER
- HW = HOT WATER
- HWR = HOT WATER RECIRCULATING
- SS = SANITARY DRAIN
- V = VENT
- SD = STORM DRAIN
- OSD = OVERFLOW STORM DRAIN
- CWD = CLEAR WATER DRAIN
- FD = FLOOR DRAIN
- FCO = FLOOR CLEANOUT
- CO = CLEAN OUT
- RD = ROOF DRAIN
- ORD = OVERFLOW ROOF DRAIN
- VTR = VENT THROUGH ROOF

REISSUE SHEET

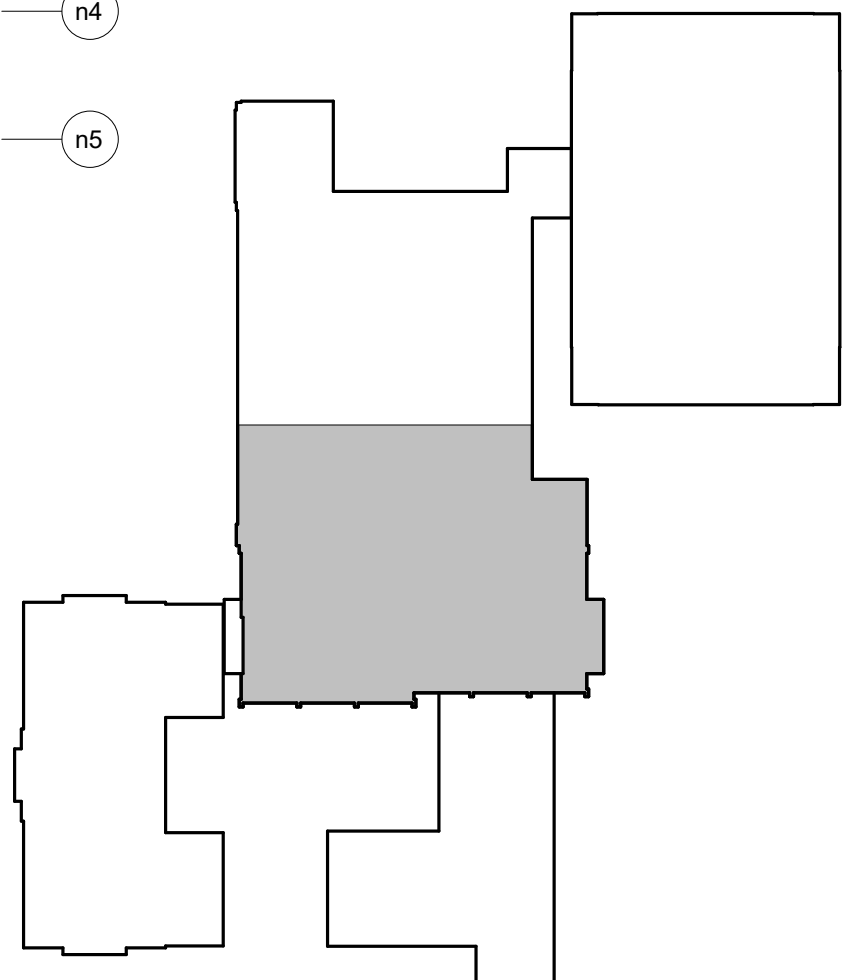

KEY PLAN
NOT TO SCALE

McMahon provides this drawing as a service to the client. It is not to be used for any other purpose without the written consent of McMahon. The client is responsible for obtaining all necessary permits and for the accuracy of the information provided. McMahon is not responsible for any errors or omissions in this drawing.



REVISION	DATE	BY	APP
ADDENDUM 2	4/4/17	2	

ALTERATION / ADDITION
OUTAGAMIE COUNTY ADMINISTRATION CENTER
S. WALNUT & W. 8TH, APPLETON, WI 54911
LEVEL 820.00 - ENLARGED PLUMBING PLAN - HHS NORTH / OCAC SOUTH

DESIGNED NDK	DRAWN NDK
PROJECT NO. 00002-61600160	
DATE MARCH 3, 2017	
SHEET NO.	



1
P231
LEVEL 820.00 - OCAC NORTH
1/8" = 1'-0"

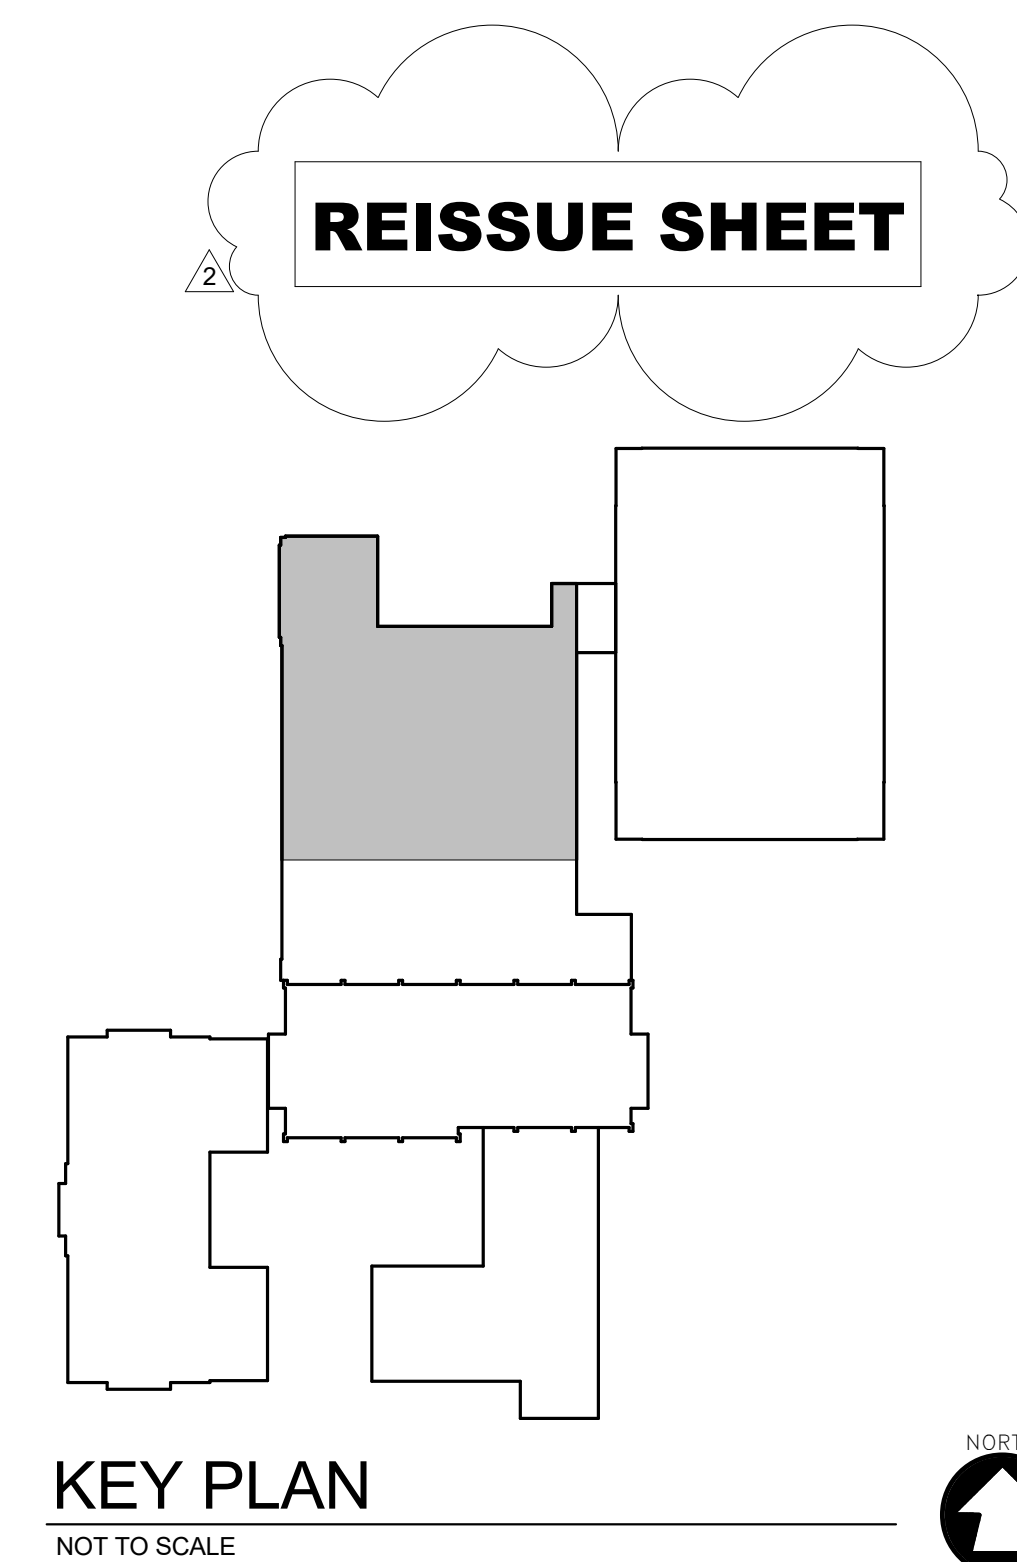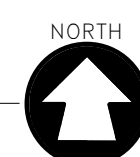

PLUMBING LEGEND


- CW = COLD WATER
HW = HOT WATER
HWR = HOT WATER RECIRCULATING
SS = SANITARY DRAIN
V = VENT
SD = STORM DRAIN
OSD = OVERFLOW STORM DRAIN
CWD = CLEAR WATER DRAIN
FD = FLOOR DRAIN
FCO = FLOOR CLEANOUT
CO = CLEAN OUT
RD = ROOF DRAIN
ORD = OVERFLOW ROOF DRAIN
VTR = VENT THROUGH ROOF

McMahon provides this drawing as instruments of service. All work shall be in accordance with the contract documents and the applicable laws and regulations of the State of Vermont. The client shall be responsible for obtaining all necessary permits and for the accuracy of the information provided. McMahon and its consultants shall not be held responsible for any errors or omissions in this drawing or for any consequences arising therefrom.

REVISION
ADDENDUM 2
DATE 4/4/17
NO 2

ALTERATION / ADDITION
OUTAGAMIE COUNTY ADMINISTRATION CENTER
S. WALNUT & W. 8TH, APPLETON, WI 54911
LEVEL 820.00 - ENLARGED PLUMBING PLAN - OCAC NORTH

DESIGNED	DRAWN
NDK	NDK
PROJECT NO. 00002-61600160	
DATE MARCH 3, 2017	
SHEET NO.	

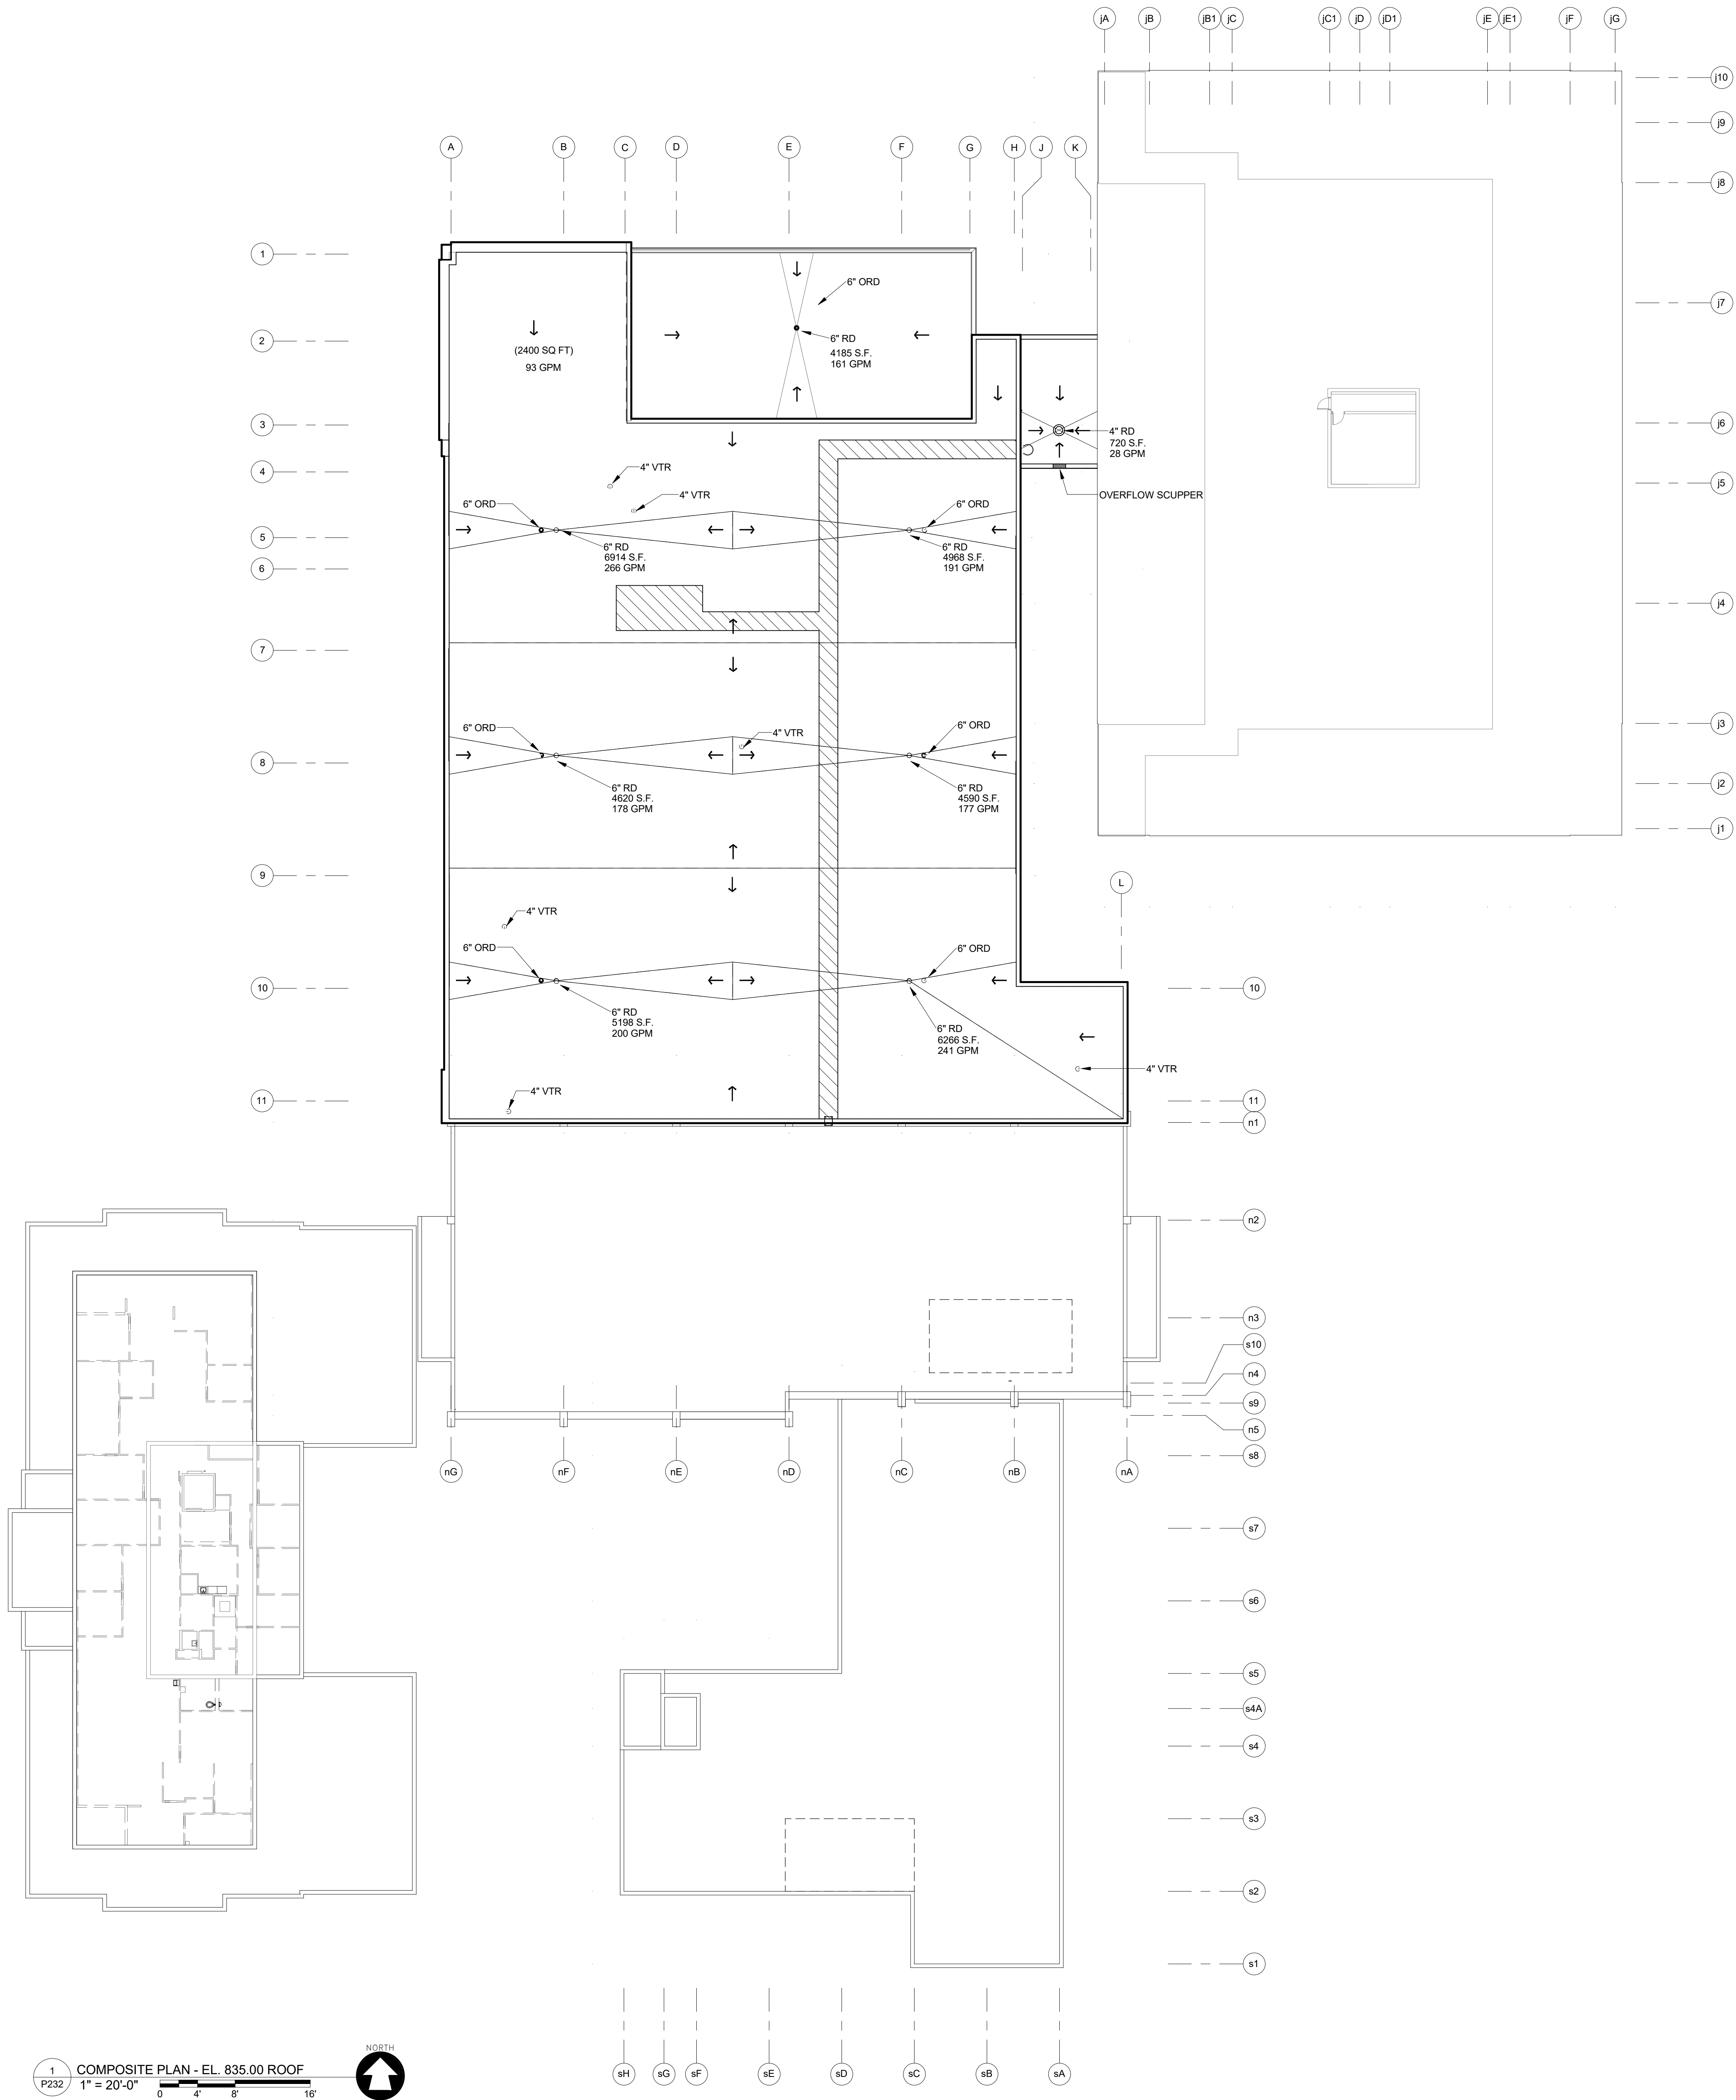

PLUMBING LEGEND

- CW = COLD WATER
- HW = HOT WATER
- HWR = HOT WATER RECIRCULATING
- SS = SANITARY DRAIN
- V = VENT
- SD = STORM DRAIN
- OSD = OVERFLOW STORM DRAIN
- CWD = CLEAR WATER DRAIN
- FD = FLOOR DRAIN
- FCO = FLOOR CLEANOUT
- CO = CLEAN OUT
- RD = ROOF DRAIN
- ORD = OVERFLOW ROOF DRAIN
- VTR = VENT THROUGH ROOF

McMAHON
ENGINEERS ARCHITECTS
Maine P.O. BOX 1023 NEWBURY, VT 05457-0102
Tel: (820) 751-4200 Fax: (820) 751-4284
www.mcngpi.com

McMahon provides this drawing as instruments of service. All work shall be in accordance with the contract documents and the applicable laws and regulations. The client shall be responsible for obtaining all necessary permits and for the accuracy of the information provided. McMahon shall not be responsible for any errors or omissions in this drawing or for any consequences arising therefrom.

NO.	DATE	REVISION
2	4/4/17	ADDENDUM 2

ALTERATION / ADDITION
OUTAGAMIE COUNTY ADMINISTRATION CENTER
S. WALNUT & W. 8TH, APPLETON, WI 54911
LEVEL 835.00 - ROOF DRAIN LAYOUT - HHS NORTH / OCAC SOUTH

DESIGNED NDK	DRAWN NDK
PROJECT NO. 00002-61600160	
DATE MARCH 3, 2017	
SHEET NO. P232	