

PLAN NOTES:


1. LIGHT FIXTURES IN THIS ROOM SHALL BE FED FROM INDICATED CIRCUIT UNLESS NOTED OTHERWISE.
2. EXISTING LIGHT FIXTURES AND CONTROLS IN THIS AREA SHALL REMAIN.

DATE	REVISION
1 3/31/17	Addendum #1
2 4/4/17	Addendum #2

ALTERATION / ADDITION
OUTAGAMIE COUNTY ADMINISTRATION CENTER
S. WALNUT & W. 8TH, APPLETON WI 54911
LEVEL 790.00 LIGHTING PLAN-HHS NORTH/OCAC SOUTH


DESIGNED	DRAWN
CEH	MAL
PROJECT NO.	00002-61600160
DATE	MARCH 3, 2017
SHEET NO.	

EL232

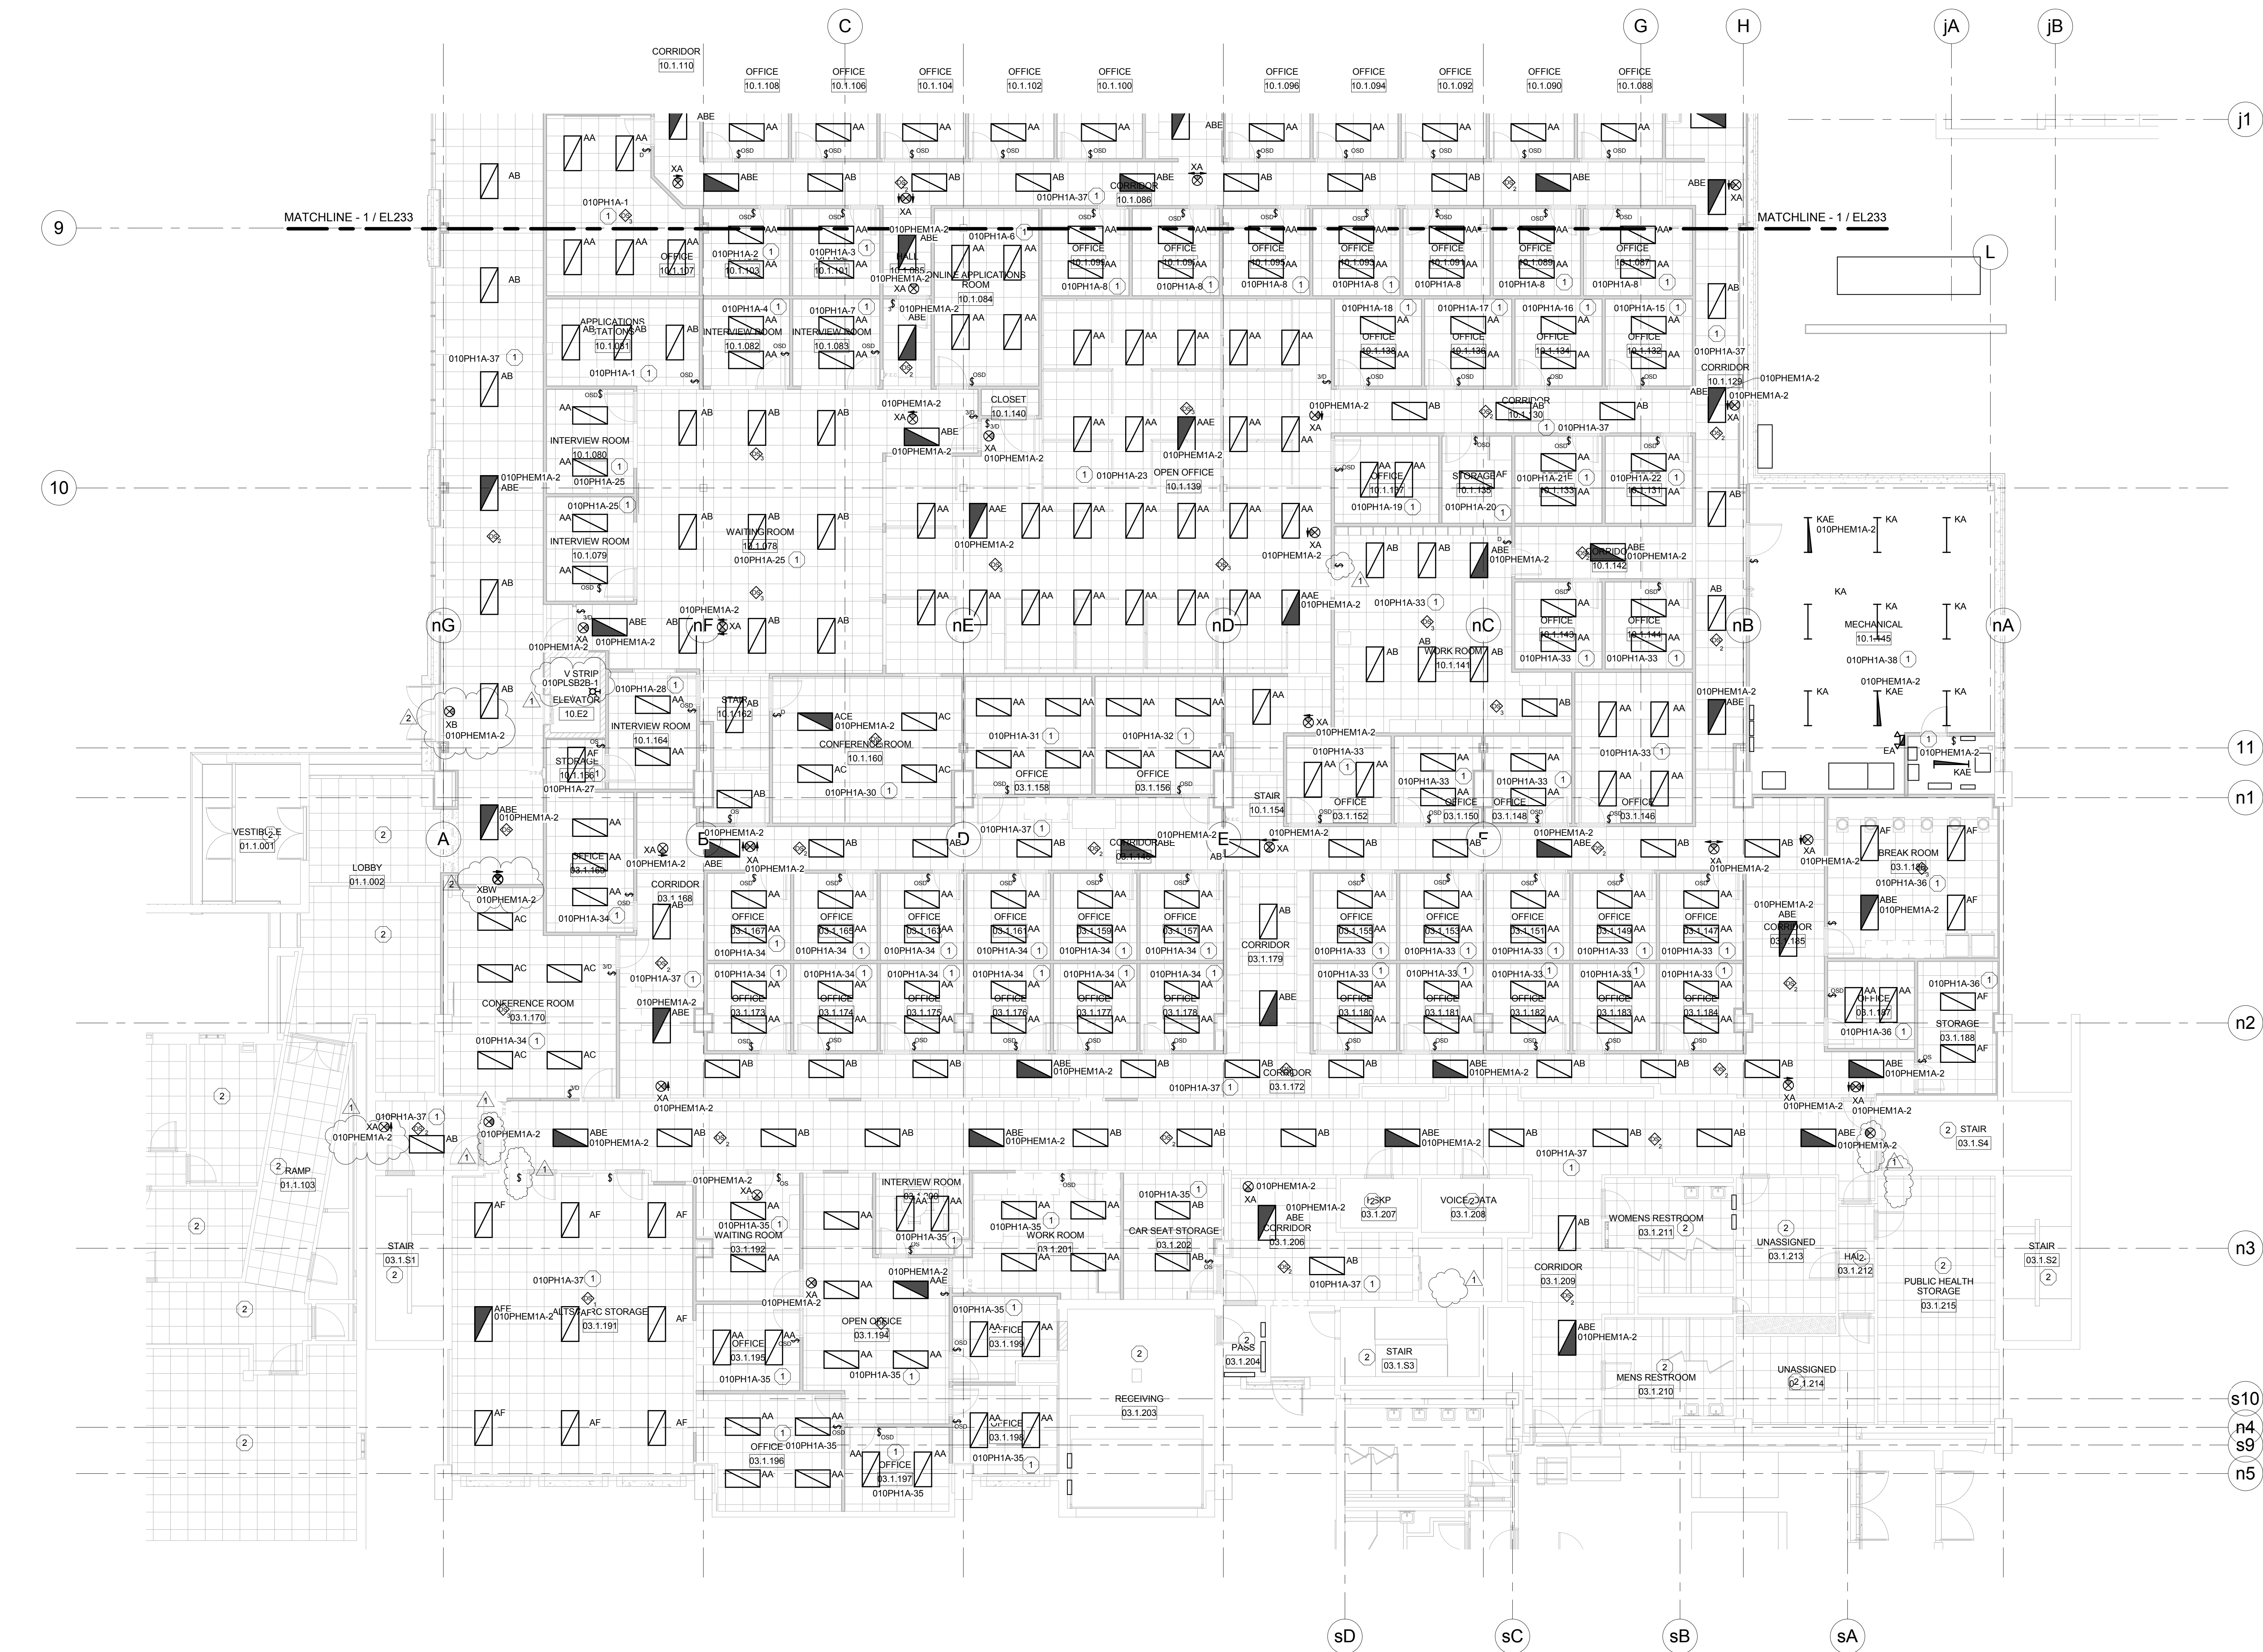


1 LEVEL 790.00 LIGHTING PLAN-HHS NORTH/OCAC SOUTH
Scale: 1/8" = 1'-0"

PLAN KEY

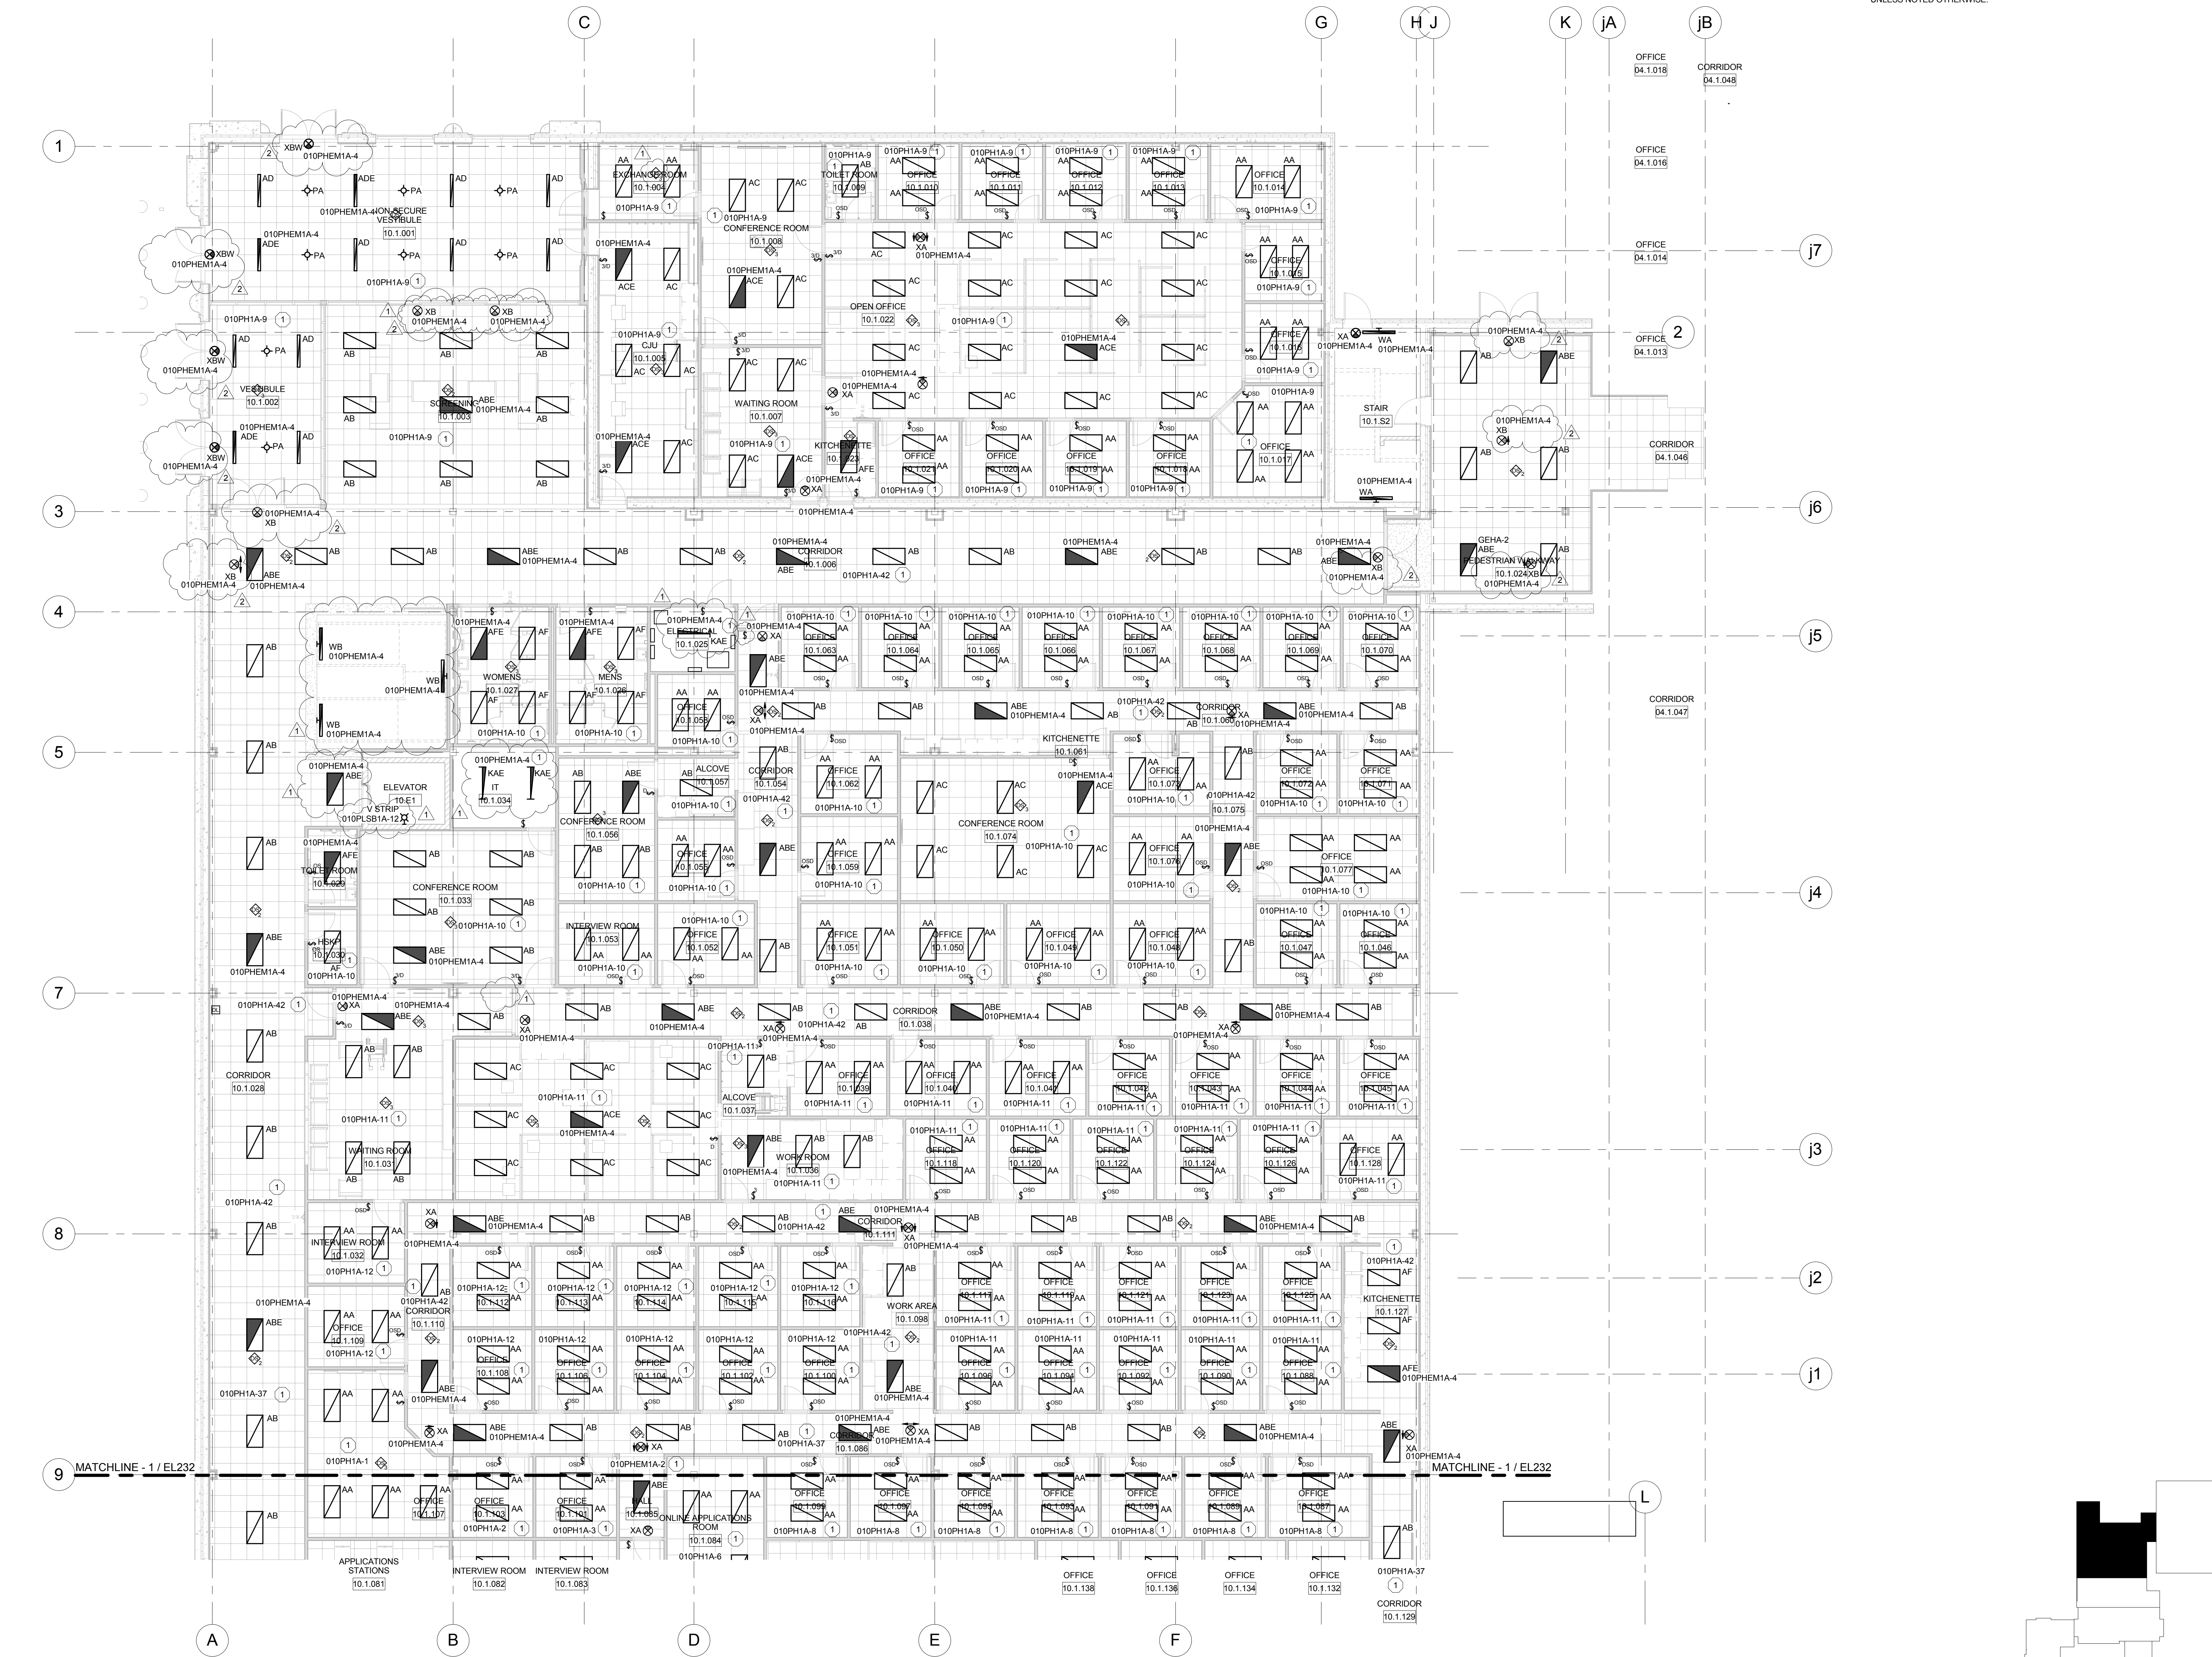

1 LEVEL 790.00 LIGHTING PLAN-OCAC NORTH
Scale: 1/8" = 1'-0"

PLAN NOTES: #
1. LIGHT FIXTURES IN THIS ROOM SHALL BE FED FROM INDICATED CIRCUIT UNLESS NOTED OTHERWISE.

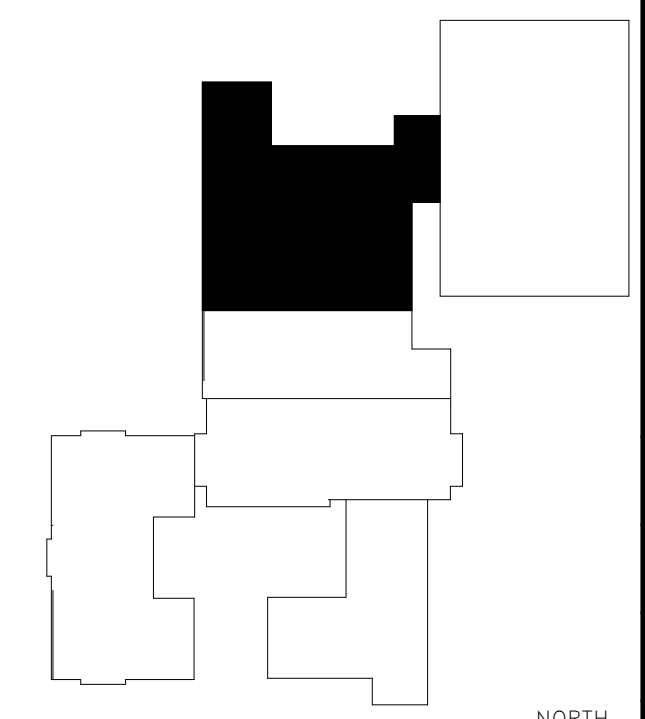

McMAHON
ENGINEERS ARCHITECTS
Maine P.O. BOX 1025 NEWBATH, VT 05457-1025
Tel: (802) 751-4200 Fax: (802) 751-4284
www.mahon.com

McMahon provides this drawing as an instrument of service. All work is to be done in accordance with the contract documents. The client is responsible for obtaining all necessary permits and for the accuracy of the information provided. McMahon is not responsible for any errors or omissions in this drawing or for any consequences arising therefrom. This drawing is the property of McMahon and shall not be reproduced or used in any manner without the written consent of McMahon.

NO.	DATE	REVISION
1	3/31/17	Addendum #1
2	4/4/17	Addendum #2

DESIGNED
CEH

DRAWN
MAL


PROJECT NO.
00002-61600160

DATE
MARCH 3, 2017


SHEET NO.
EL233

ALTERATION / ADDITION
OUTAGAMIE COUNTY ADMINISTRATION CENTER
S. WALNUT & W. 8TH, APPLETON WI 54911
LEVEL 790.00 LIGHTING PLAN-OCAC NORTH

1 LEVEL 790.00 LIGHTING PLAN-JUSTICE CENTER
Scale: 1/8" = 1'-0"

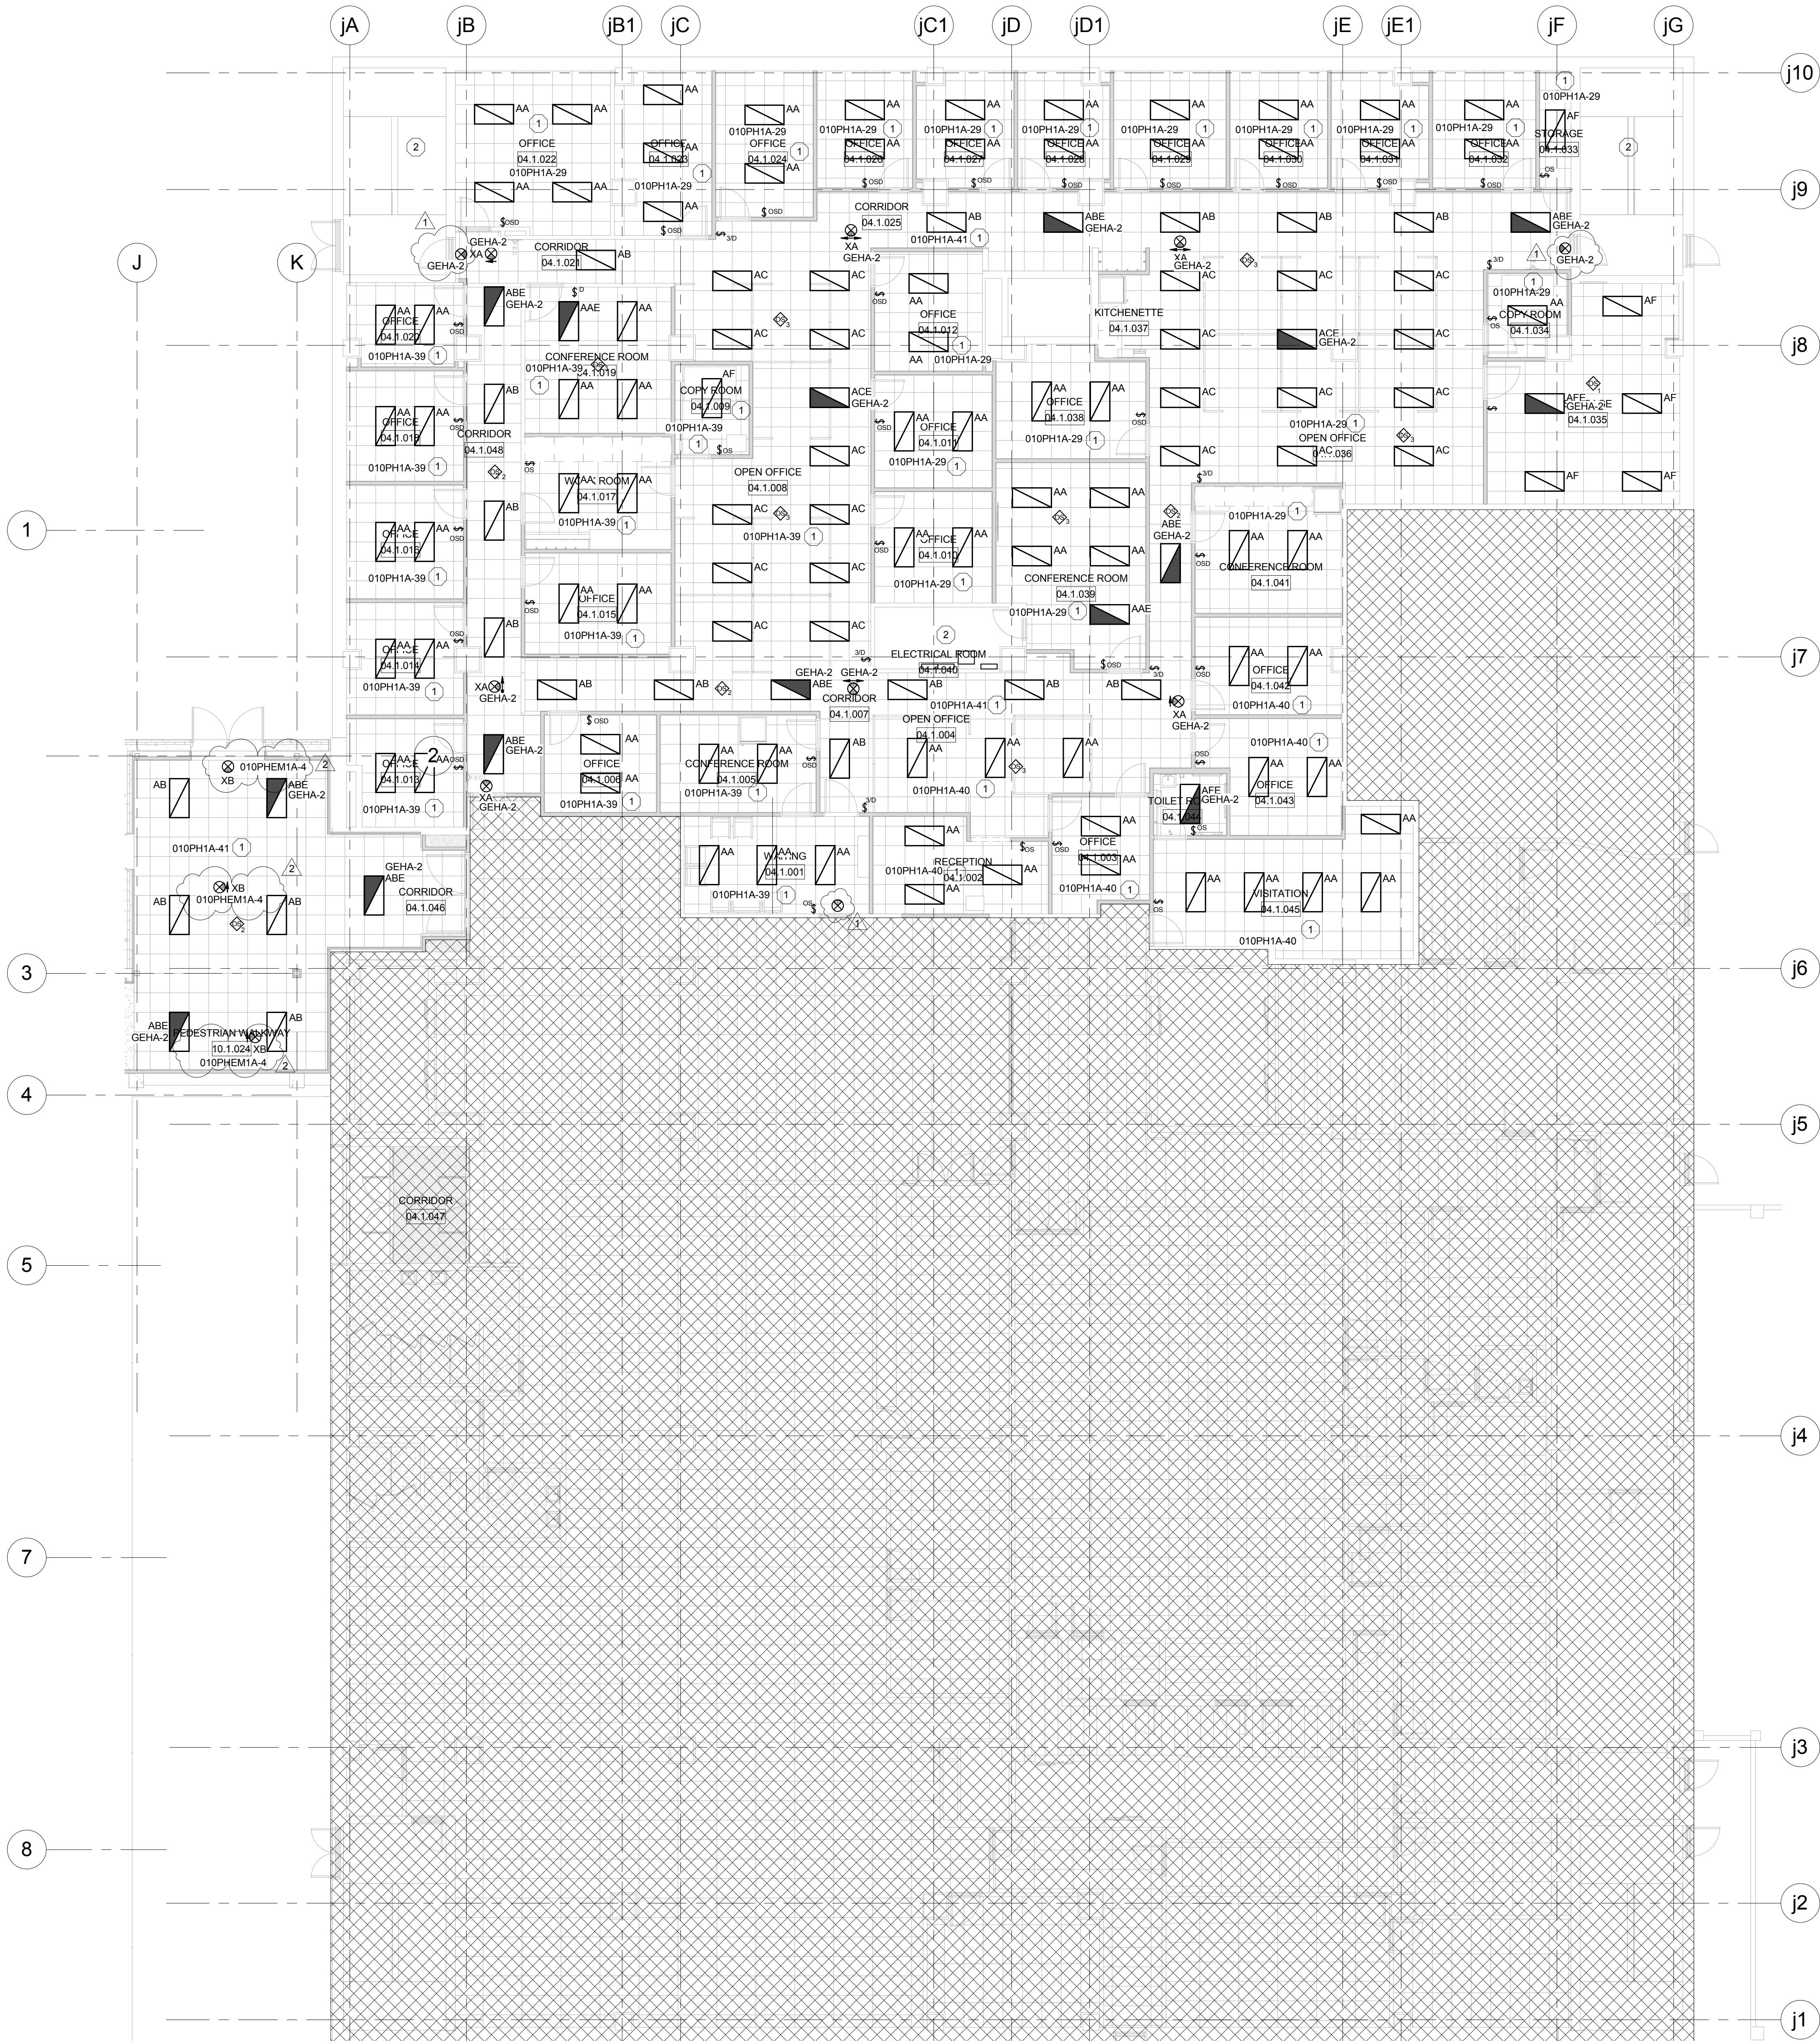

- PLAN NOTES: #
1. LIGHT FIXTURES IN THIS ROOM SHALL BE FED FROM INDICATED CIRCUIT UNLESS NOTED OTHERWISE.
 2. EXISTING LIGHT FIXTURES AND CONTROLS IN THIS AREA SHALL REMAIN.

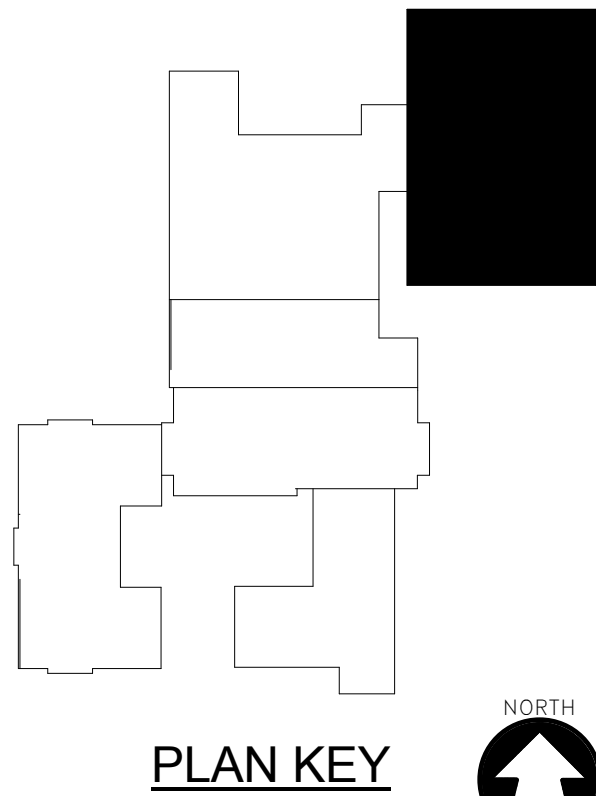

McMAHON
ENGINEERS ARCHITECTS
Main Office: 1025 N. Main St., Suite 200
Milwaukee, WI 53233
Tel: (414) 224-1234 Fax: (414) 224-1235
www.mahon.com

McMahon provides this drawing as an instrument of service. All rights are reserved. The client agrees to indemnify and hold McMahon harmless from and against all claims, damages, costs and expenses, including reasonable attorneys' fees, arising out of or from the use of this drawing, whether or not such claims, damages, costs and expenses are caused in whole or in part by the negligence of McMahon.

REVISION	
NO.	DATE
1	3/31/17
2	4/4/17

ALTERATION / ADDITION
OUTAGAMIE COUNTY ADMINISTRATION CENTER
S. WALNUT & W. 8TH, APPLETON WI 54911
LEVEL 790.00 LIGHTING PLAN-JUSTICE CENTER


DESIGNED	DRAWN
CEH	MAL
PROJECT NO.	00002-61600160
DATE	MARCH 3, 2017
SHEET NO.	EL234

- PLAN NOTES: #
1. LIGHT FIXTURES IN THIS ROOM SHALL BE FED FROM INDICATED CIRCUIT UNLESS NOTED OTHERWISE.
 2. EXISTING LIGHT FIXTURES AND CONTROLS IN THIS AREA SHALL REMAIN.


REVISION	DATE	BY	DESCRIPTION
1	3/31/17	CEH	DESIGNED
2	4/4/17	MAL	DRAWN

ALTERATION / ADDITION
OUTAGAMIE COUNTY ADMINISTRATION CENTER
S. WALNUT & W. 8TH, APPLETON WI 54911
LEVEL 805.00 LIGHTING PLAN-HHS NORTH/OCAC SOUTH

DESIGNED	CEH	DRAWN	MAL
PROJECT NO.	00002-61600160	DATE	MARCH 3, 2017
SHEET NO.	EL235		

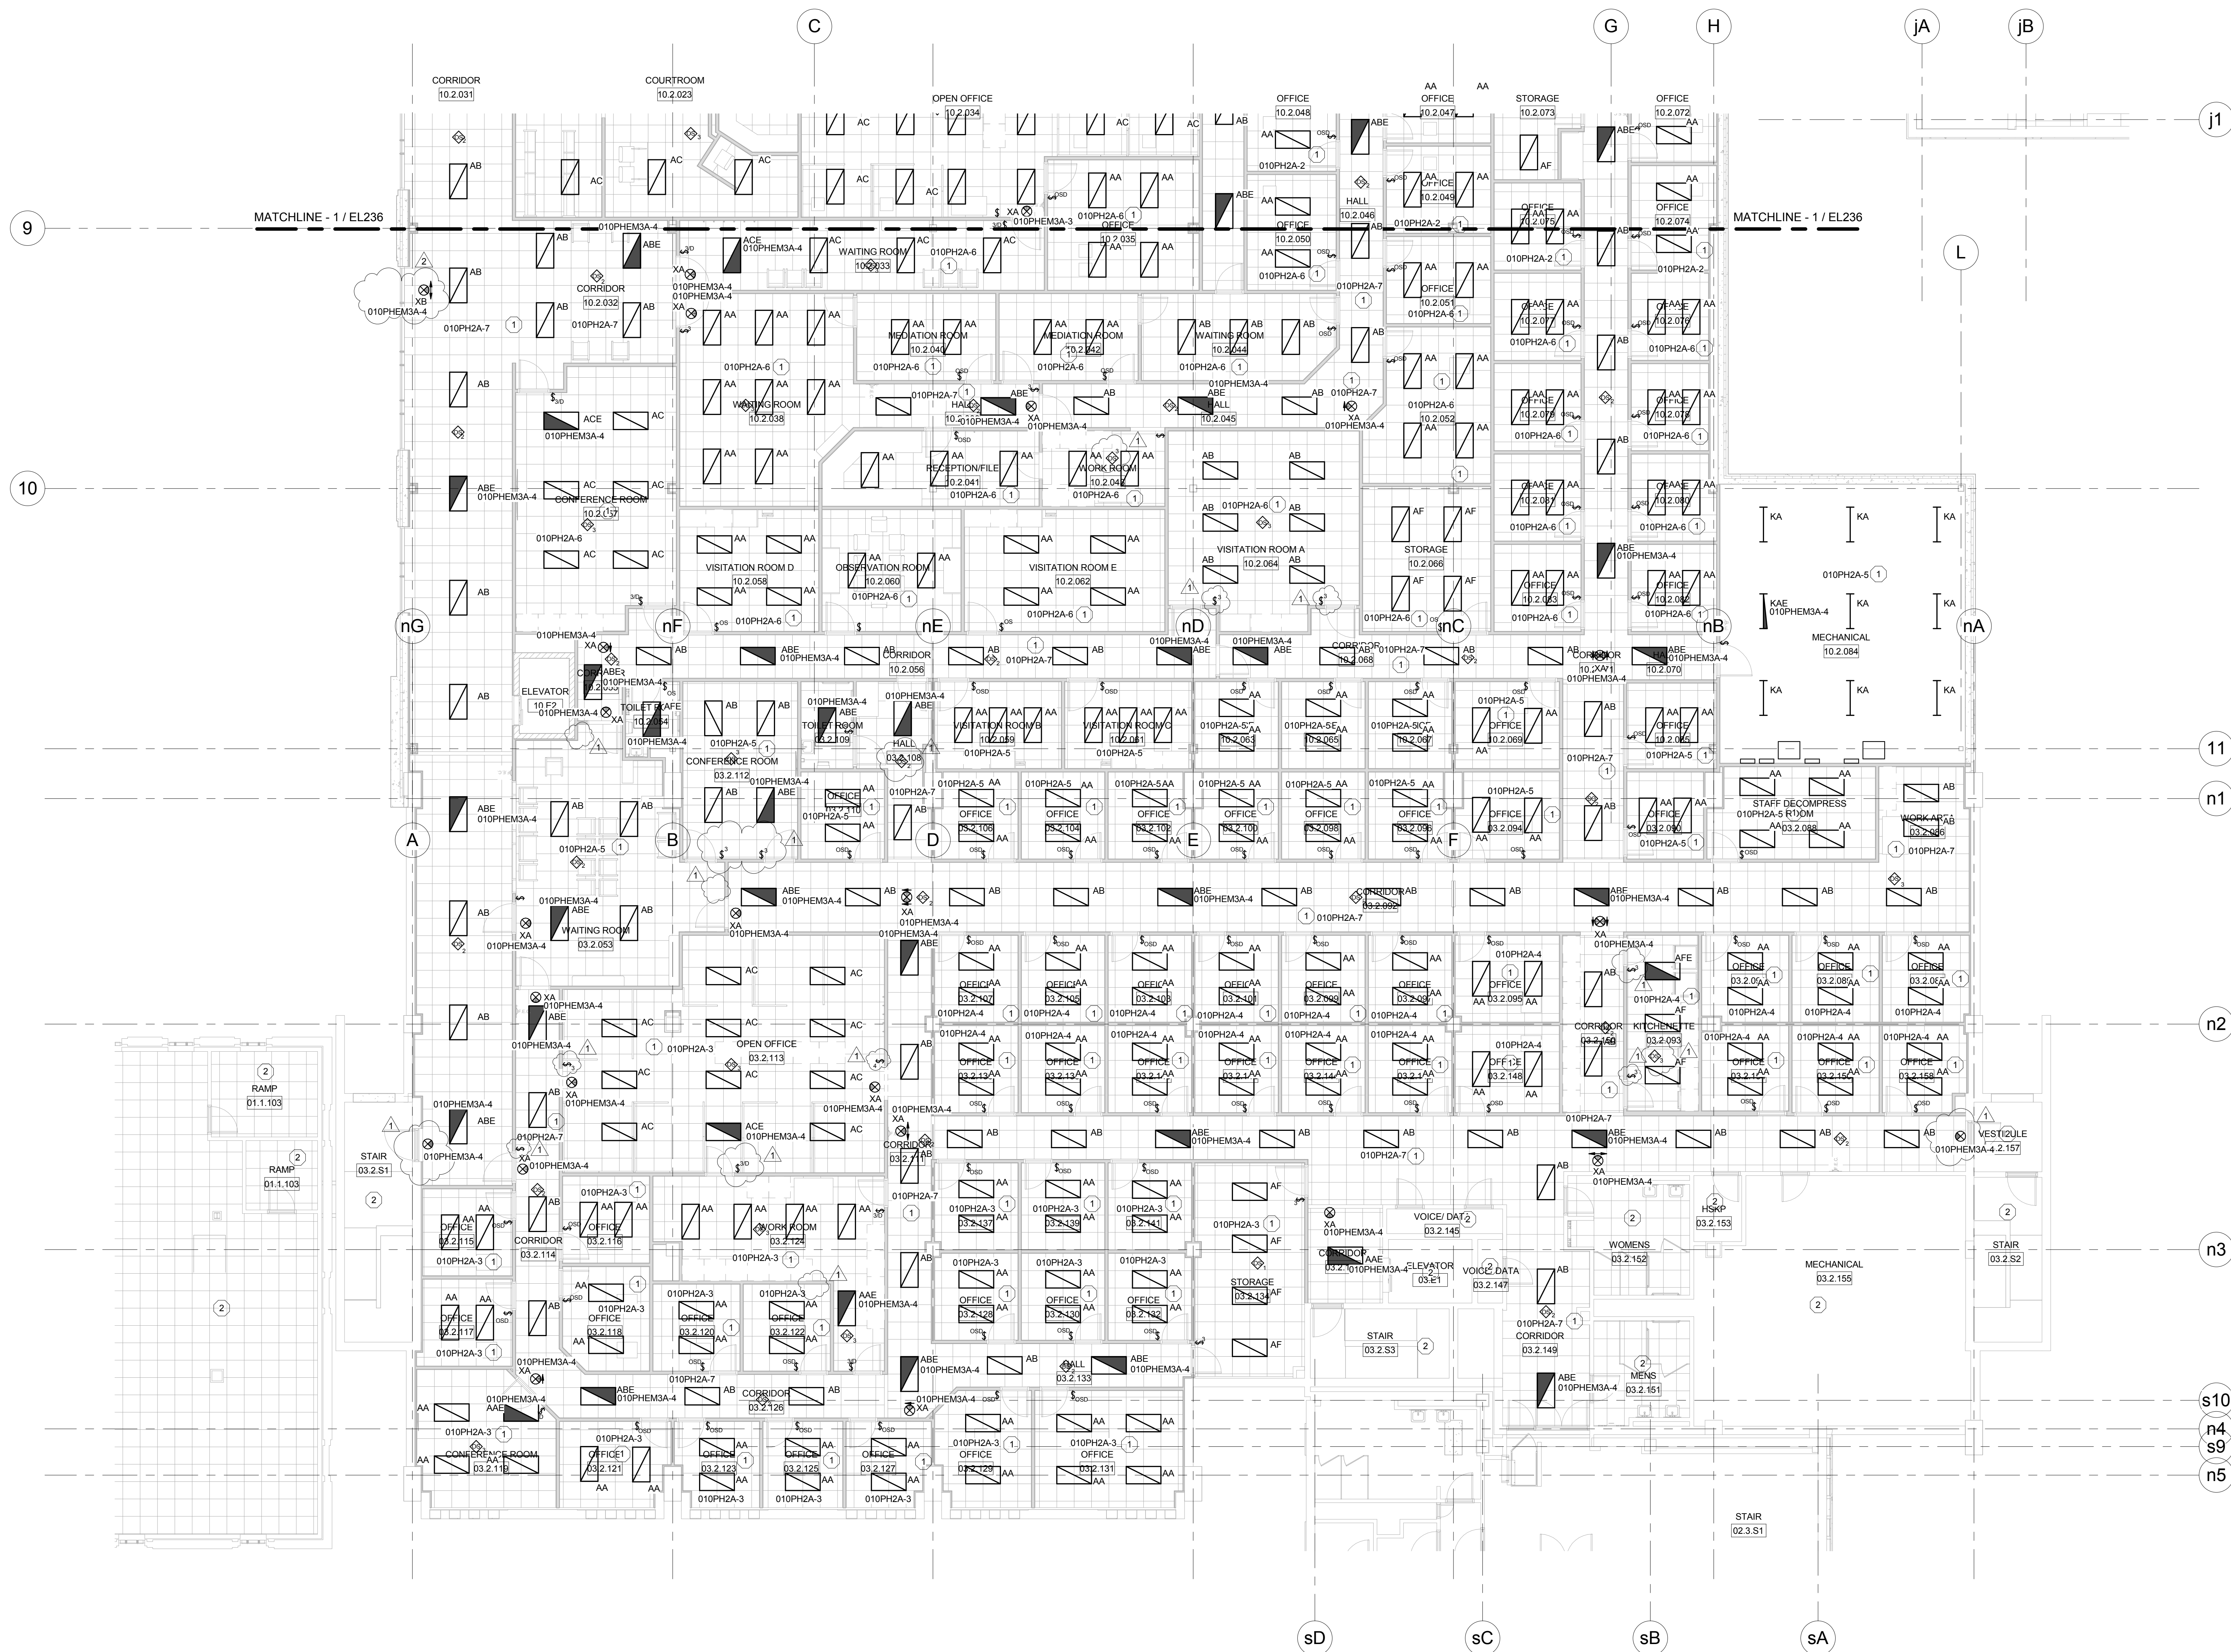


1 LEVEL 805.00 LIGHTING PLAN-HHS NORTH/OCAC SOUTH
Scale: 1/8" = 1'-0"

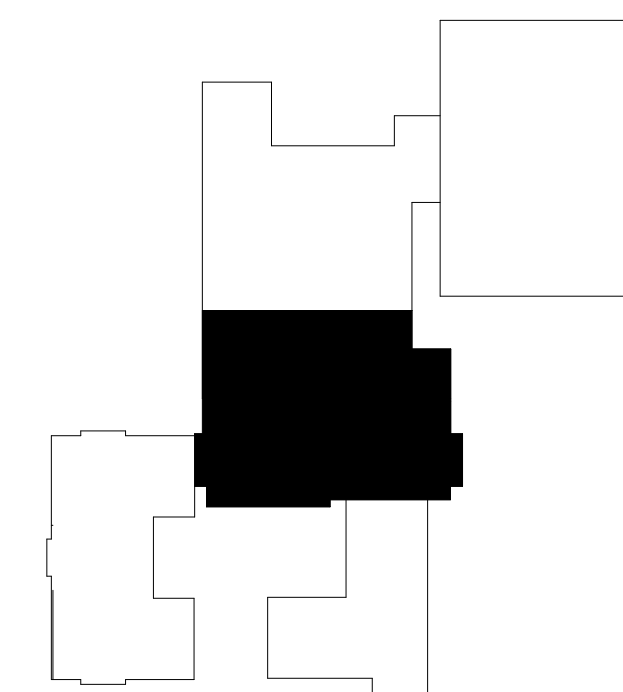



PLAN KEY



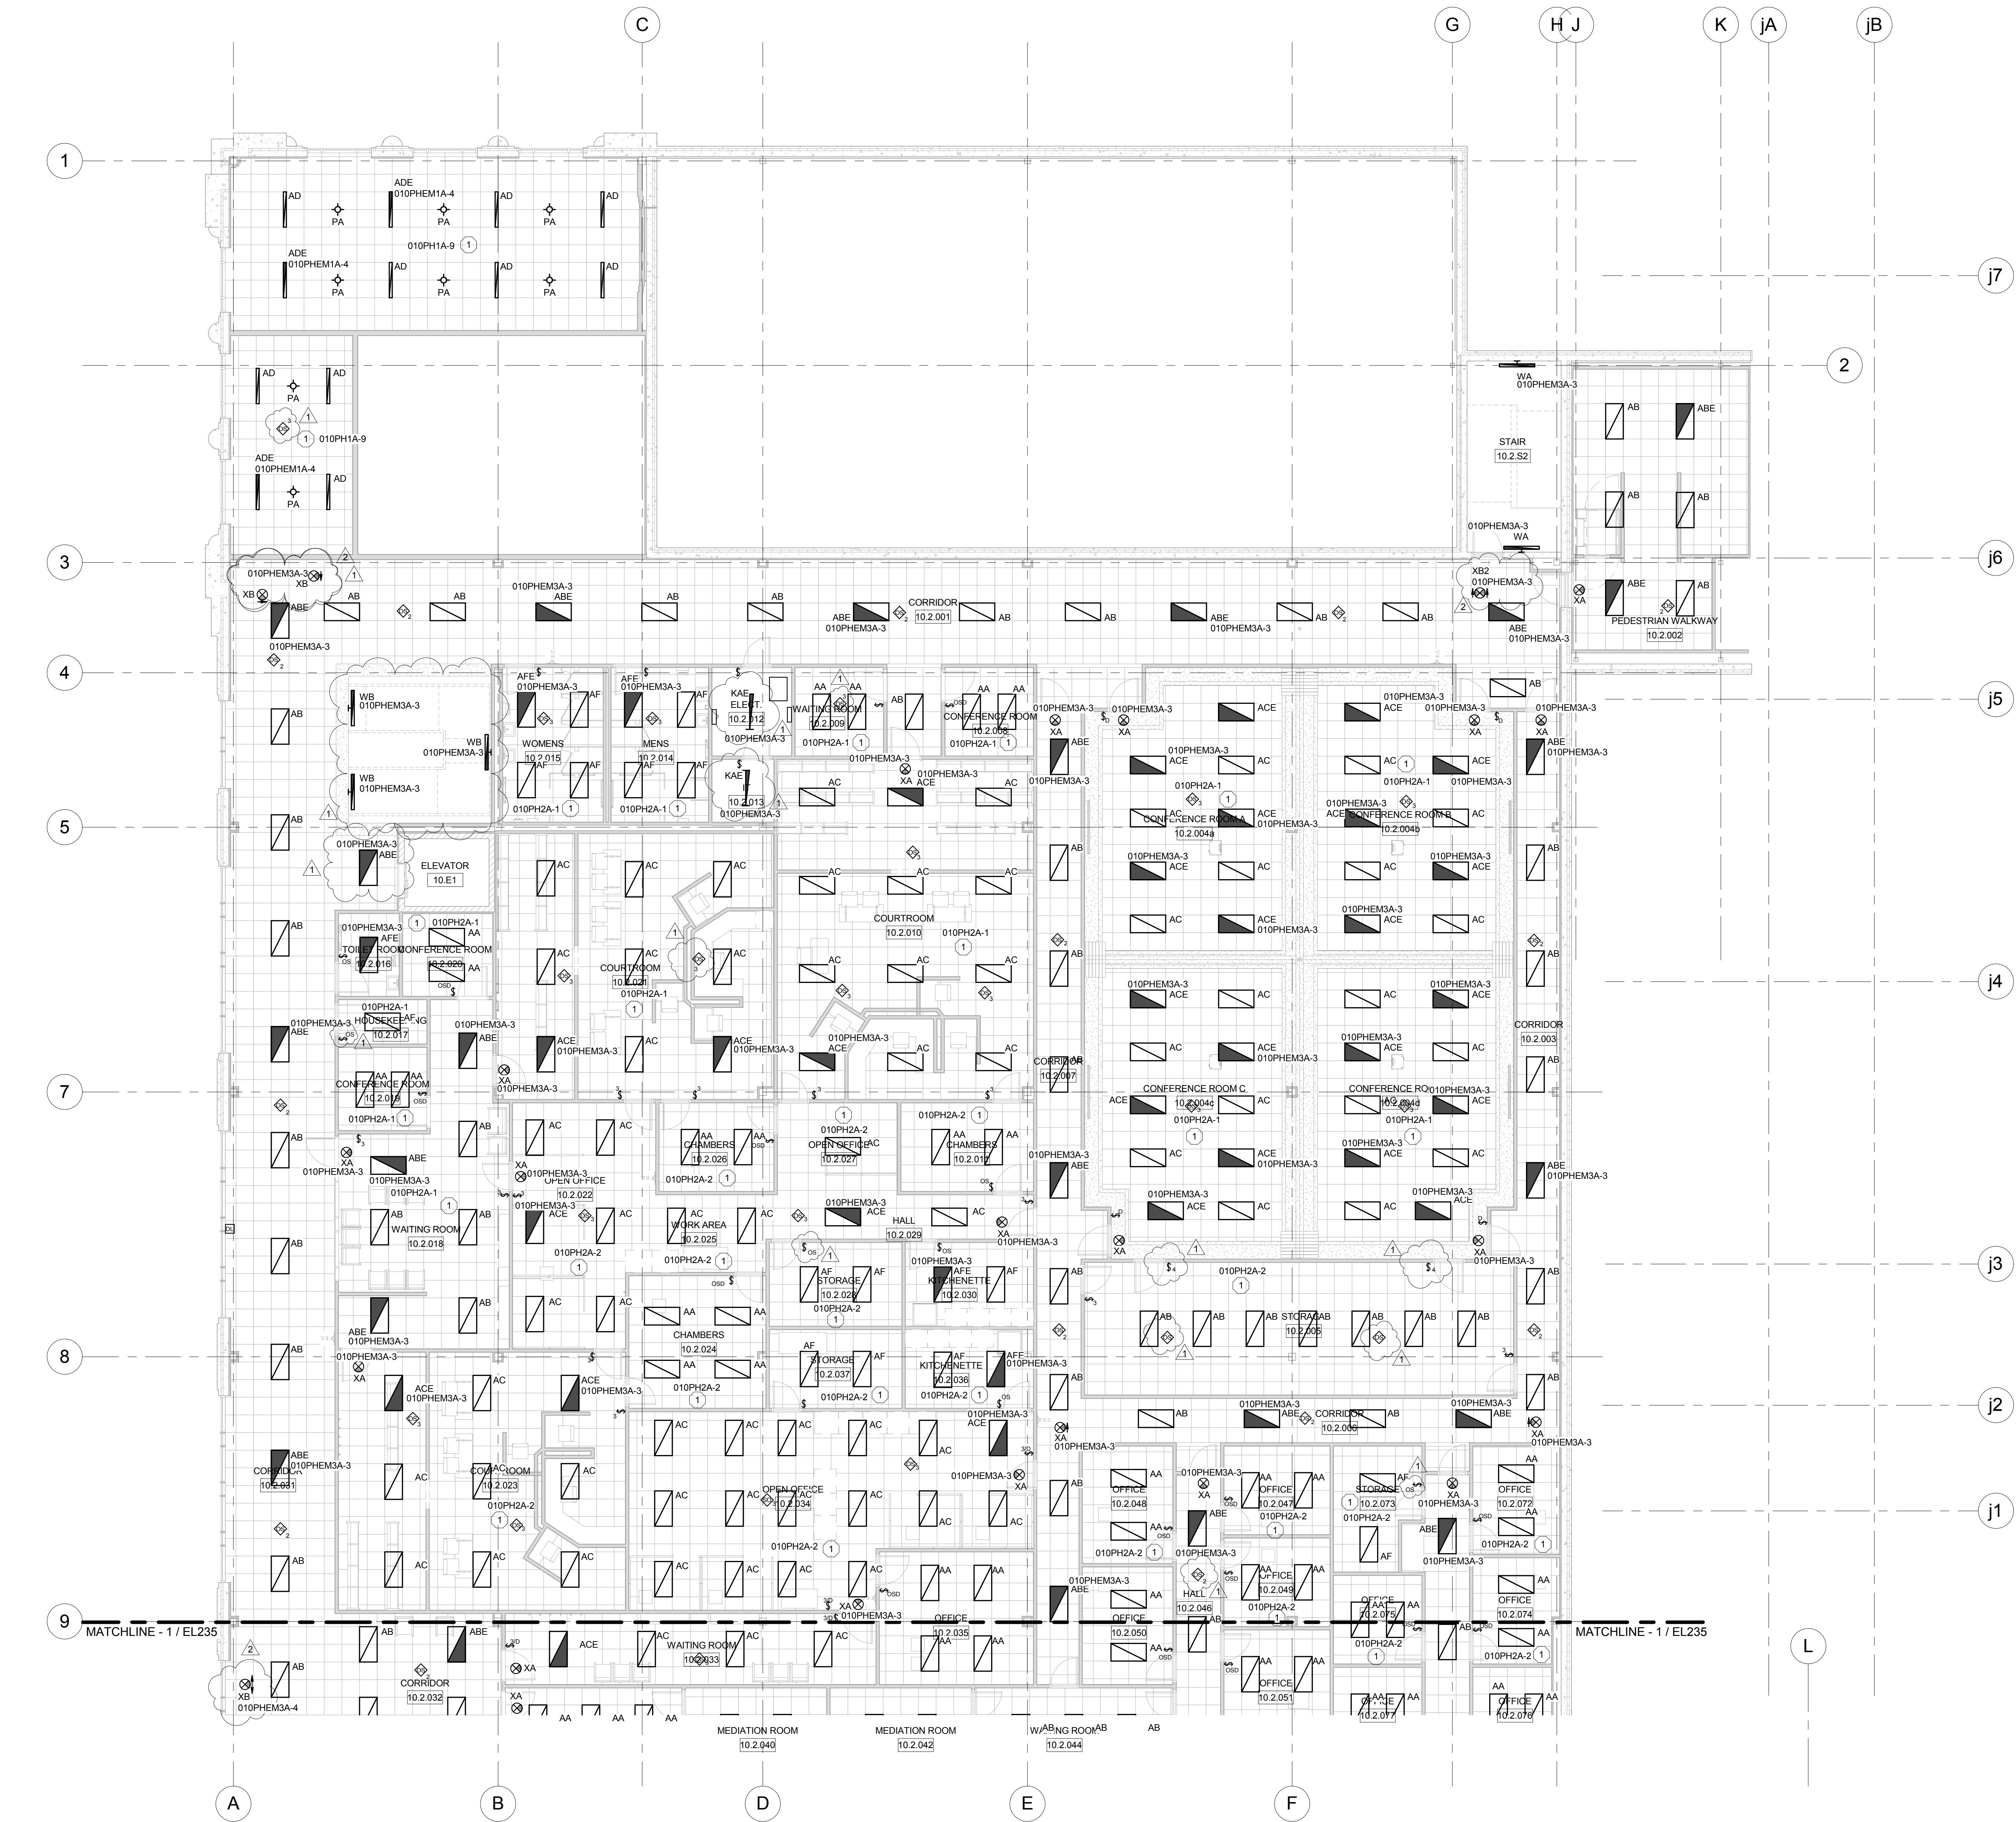

1 LEVEL 805.00 LIGHTING PLAN-OCAC NORTH
Scale: 1/8" = 1'-0"

PLAN NOTES: #
1. LIGHT FIXTURES IN THIS ROOM SHALL BE FED BY THIS CIRCUIT UNLESS NOTED OTHERWISE.

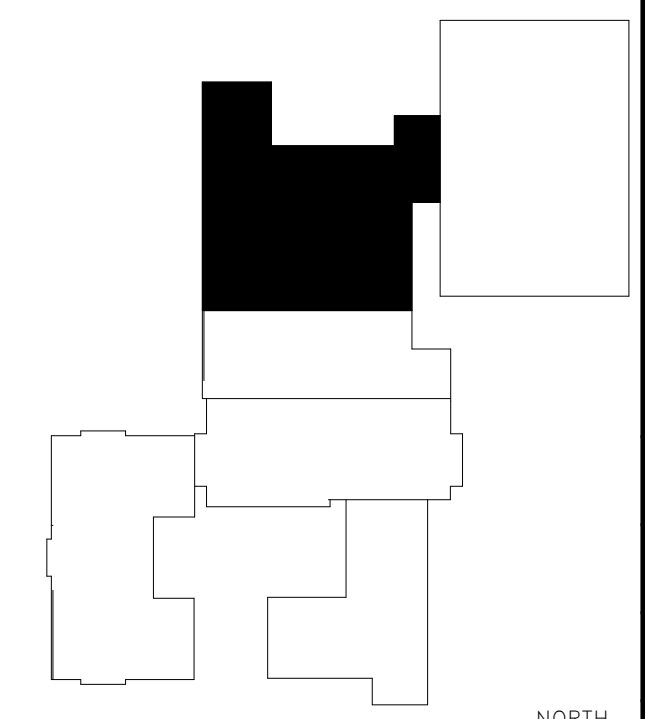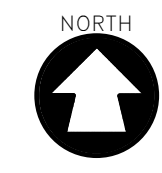


McMAHON
ENGINEERS ARCHITECTS
1000 N. WAUWATONIA AVENUE
MILWAUKEE, WI 53212
Tel: (414) 754-4200 Fax: (414) 754-4204
www.mahon.com

McMahon provides this drawing as a service to the client. It is not to be used for any other purpose without the written consent of McMahon. The client acknowledges that McMahon is not responsible for the accuracy of the information provided by the client or for the results of the use of this drawing. McMahon reserves the right to make changes to this drawing without notice.

NO.	DATE	REVISION
1	3/31/17	Addendum #1
2	4/4/17	Addendum #2


ALTERATION / ADDITION
OUTAGAMIE COUNTY ADMINISTRATION CENTER
S. WALNUT & W. 8TH, APPLETON WI 54911
LEVEL 805.00 LIGHTING PLAN-OCAC NORTH

DESIGNED	CEH	DRAWN	MAL
PROJECT NO.	00002-61600160		
DATE	MARCH 3, 2017		
SHEET NO.	EL236		

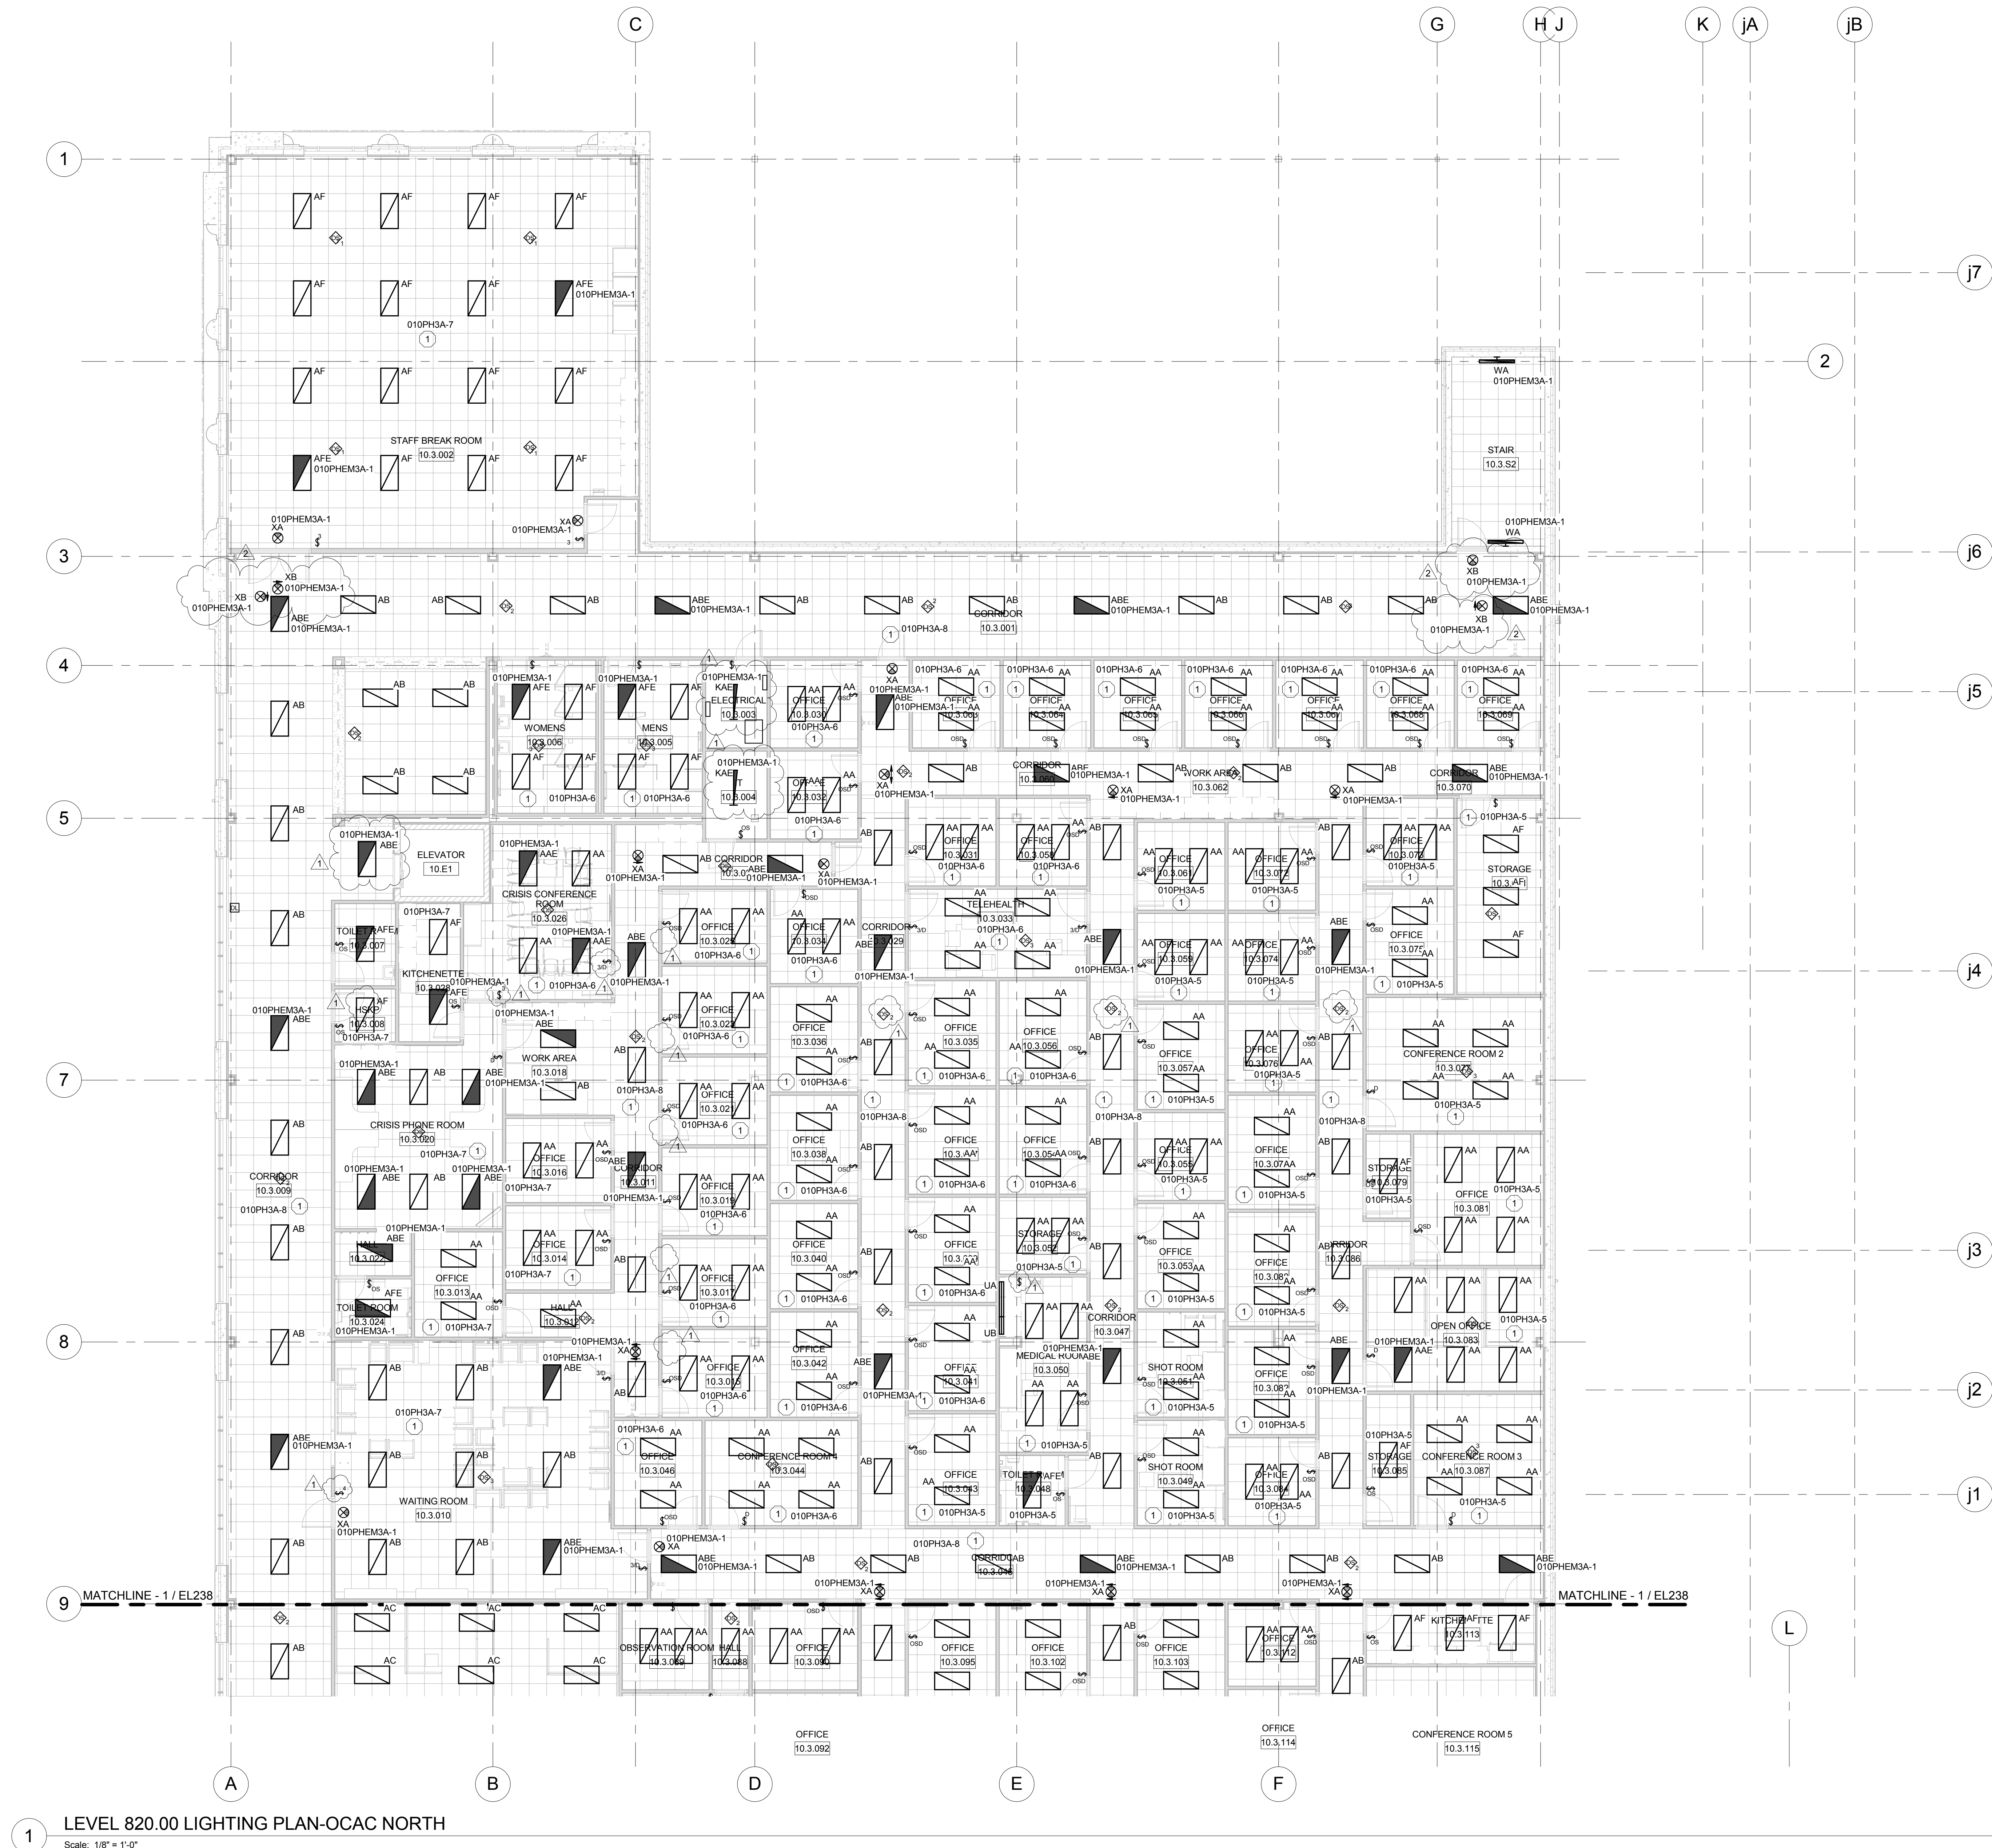

1 LEVEL 820.00 LIGHTING PLAN-OCAC NORTH
Scale: 1/8" = 1'-0"

PLAN NOTES: #
1. LIGHT FIXTURES IN THIS ROOM SHALL BE FED BY THIS CIRCUIT UNLESS NOTED OTHERWISE.

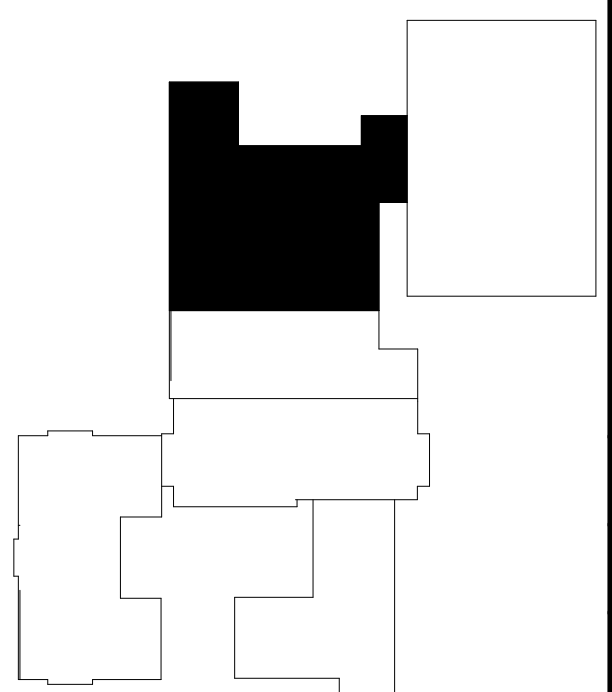

McMAHON
ENGINEERS ARCHITECTS
Maine P.O. BOX 1023 NEWBURY, VT 05457-1023
Tel: (802) 751-4200 Fax: (802) 751-4284
www.mahon.com

McMahon provides this drawing as instruments of service. All drawings are the property of McMahon. The client agrees to indemnify and hold McMahon harmless from all claims, damages, costs and expenses, including reasonable attorneys' fees, arising from the use of this drawing for any purpose other than that for which it was prepared.

DATE	REVISION
1 3/31/17	Addendum #1
2 4/4/17	Addendum #2

ALTERATION / ADDITION
OUTAGAMIE COUNTY ADMINISTRATION CENTER
S. WALNUT & W. 8TH, APPLETON WI 54911
LEVEL 820.00 LIGHTING PLAN-OCAC NORTH

DESIGNED	DRAWN
CEH	MAL
PROJECT NO.	00002-61600160
DATE	MARCH 3, 2017
SHEET NO.	EL239

1
2

LIGHTING FIXTURE SCHEDULE							
TYPE	DESCRIPTION	MANUFACTURER	CATALOG NUMBER	LAMP TYPE	LAMP QTY PER FIXTURE	FT. Elec. Voltage_Connector_1	WATTAGE
AA	2'X4' RECESSED TROFFER, DIMMABLE, 6000 LUMENS, 4000K	LITHONIA	2FSL4 60L EZ1 LP840	LED	1	277 V	52.4
AAE	SAME AS AA EXCEPT POWERED BY GENERATOR	LITHONIA	2FSL4 60L EZ1 LP840 N80EMG	LED	1	277 V	52.4
AB	2'X4' RECESSED TROFFER, DIMMABLE, 4800 LUMENS, 4000K	LITHONIA	2FSL4 48L EZ1 LP840	LED	1	277 V	46.6
ABE	SAME AS AB EXCEPT POWERED BY GENERATOR	LITHONIA	2FSL4 48L EZ1 LP840 N80EMG	LED	1	277 V	46.6
AC	2'X4' RECESSED TROFFER, DIMMABLE, 7200 LUMENS, 4000K	LITHONIA	2FSL4 72L EZ1 LP840	LED	1	277 V	70.2
ACE	SAME AS AC EXCEPT POWERED BY GENERATOR	LITHONIA	2FSL4 72L EZ1 LP840 N80EMG	LED	1	277 V	70.2
AD	4' RECESSED LINEAR FIXTURE, 4000K	ALCON LIGHTING	14004-4-45-UNV-40K	LED	1	277 V	45
ADE	SAME AS AD EXCEPT POWERED BY GENERATOR	ALCON LIGHTING	14004-4-45-UNV-40K	LED	1	277 V	45
AF	2'X4' RECESSED TROFFER, 4800 LUMENS, 4000K	LITHONIA	2FSL4 482L E0HN LP840	LED	1	277 V	70.2
AFE	SAME AS AF EXCEPT POWERED BY GENERATOR	LITHONIA	2FSL4 482L E0HN LP840	LED	1	277 V	70.2
D1	6" OPEN LED DOWNLIGHT	LITHONIA	LDN6 40/20 L06 277	LED	1	277 V	35
D1E	SAME AS D1 EXCEPT POWERED BY GENERATOR	LITHONIA	LDN6 40/20 L06 277	LED	1	277 V	35
EA	EMERGENCY LIGHT	LITHONIA	ELM2 LED	LED	1	277 V	1.5
EX	EXISTING REUSED/RELOCATED FIXTURE					277 V	
EXE	EXISTING REUSED/RELOCATAED FIXTURED POWERED BY GENERATOR					277 V	
KA	4' GENERAL PURPOSE STRIP LIGHT	LITHONIA	C 2 32 MVOLT GEB10IS	32W T8	2	277 V	64
KAE	SAME AS KA EXCEPT POWERED BY GENERATOR	LITHONIA	C 2 32 MVOLT GEB10IS	32W T8	2	277 V	64
OA	LED WALL PACK - FULL CUTOFF WITH DIFFUSER	HUBBELL	LNC2 7L U 4K 3 *FINISH* PC / 93044013	LED	1	277 V	17W
PA	SHAPER, CYLINDRICAL SHADE, 52" HEIGHT	EATON MCGRAW EDISON	146-52-P1S-L5/840-UNV-ALP-52	LED	1	277 V	37
UA	4' UNDERCABINET LIGHT	LITHONIA	2UC 32 MVOLT GEB10IS	32W T8	1	277 V	32
UB	2' UNDERCABINET LIGHT	LITHONIA	2UC 17 MVOLT GEB10IS	17W T8	1	277 V	17
V STRIP	VAPOR TIGHT STRIP FIXTURE	LITHONIA	FEM L48 4000LM IMAFL MD MVOLT GZ10 40K 80CRI	LED	1	120 V	30
WA	4' WALL BRACKET	LITHONIA	WC 1 32 MVOLT GEB10IS	32W T8	1	277 V	32
WB	4' ARCHITECTURAL WALL MOUNT LUMINAIRE	ALCON LIGHTING	11112-4-40L-40	LED	1	277 V	40
XA	EXIT SIGN	LITHONIA	EXR LED M6	LED	1	277 V	0.8
XB	EXIT SIGN, SURFACE MOUNT	LITHONIA	EDG 1 R	LED	1	277 V	2.8
XB2	EXIT SIGN, DOUBLE FACED	LITHONIA	EDG 2 RW	LED	1	277 V	2.8
XBW	EXIT SIGN, WALL MOUNT	LITHONIA	EDG 1 R WM	LED	1	277 V	2.8

DESIGNED
CEH

DRAWN
MAL

PROJECT NO.
00002-61600160

DATE
MARCH 3, 2017

SHEET NO.
EL801

ALTERATION / ADDITION
OUTAGAMIE COUNTY ADMINISTRATION CENTER
S. WALNUT & W. 8TH, APPLETON WI 54911
LIGHTING FIXTURE SCHEDULE


REVISION

Addendum #1

Addendum #2

Mcmahon provides this drawing as instruments of service. All work shall be in accordance with the contract documents prepared by McMahon. The client shall be responsible for obtaining all necessary permits and for securing all required approvals. McMahon shall not be responsible for any delays or costs incurred by the client due to failure to obtain necessary permits or approvals. McMahon shall not be responsible for any changes made to the original design or construction documents without the written consent of McMahon.

MCMAHON
ENGINEERS ARCHITECTS
1025 N. KENNAH AVE., SUITE 200
MILWAUKEE, WI 53233
Tel: (820) 751-4200 Fax: (820) 751-4284
www.mcmahon.com

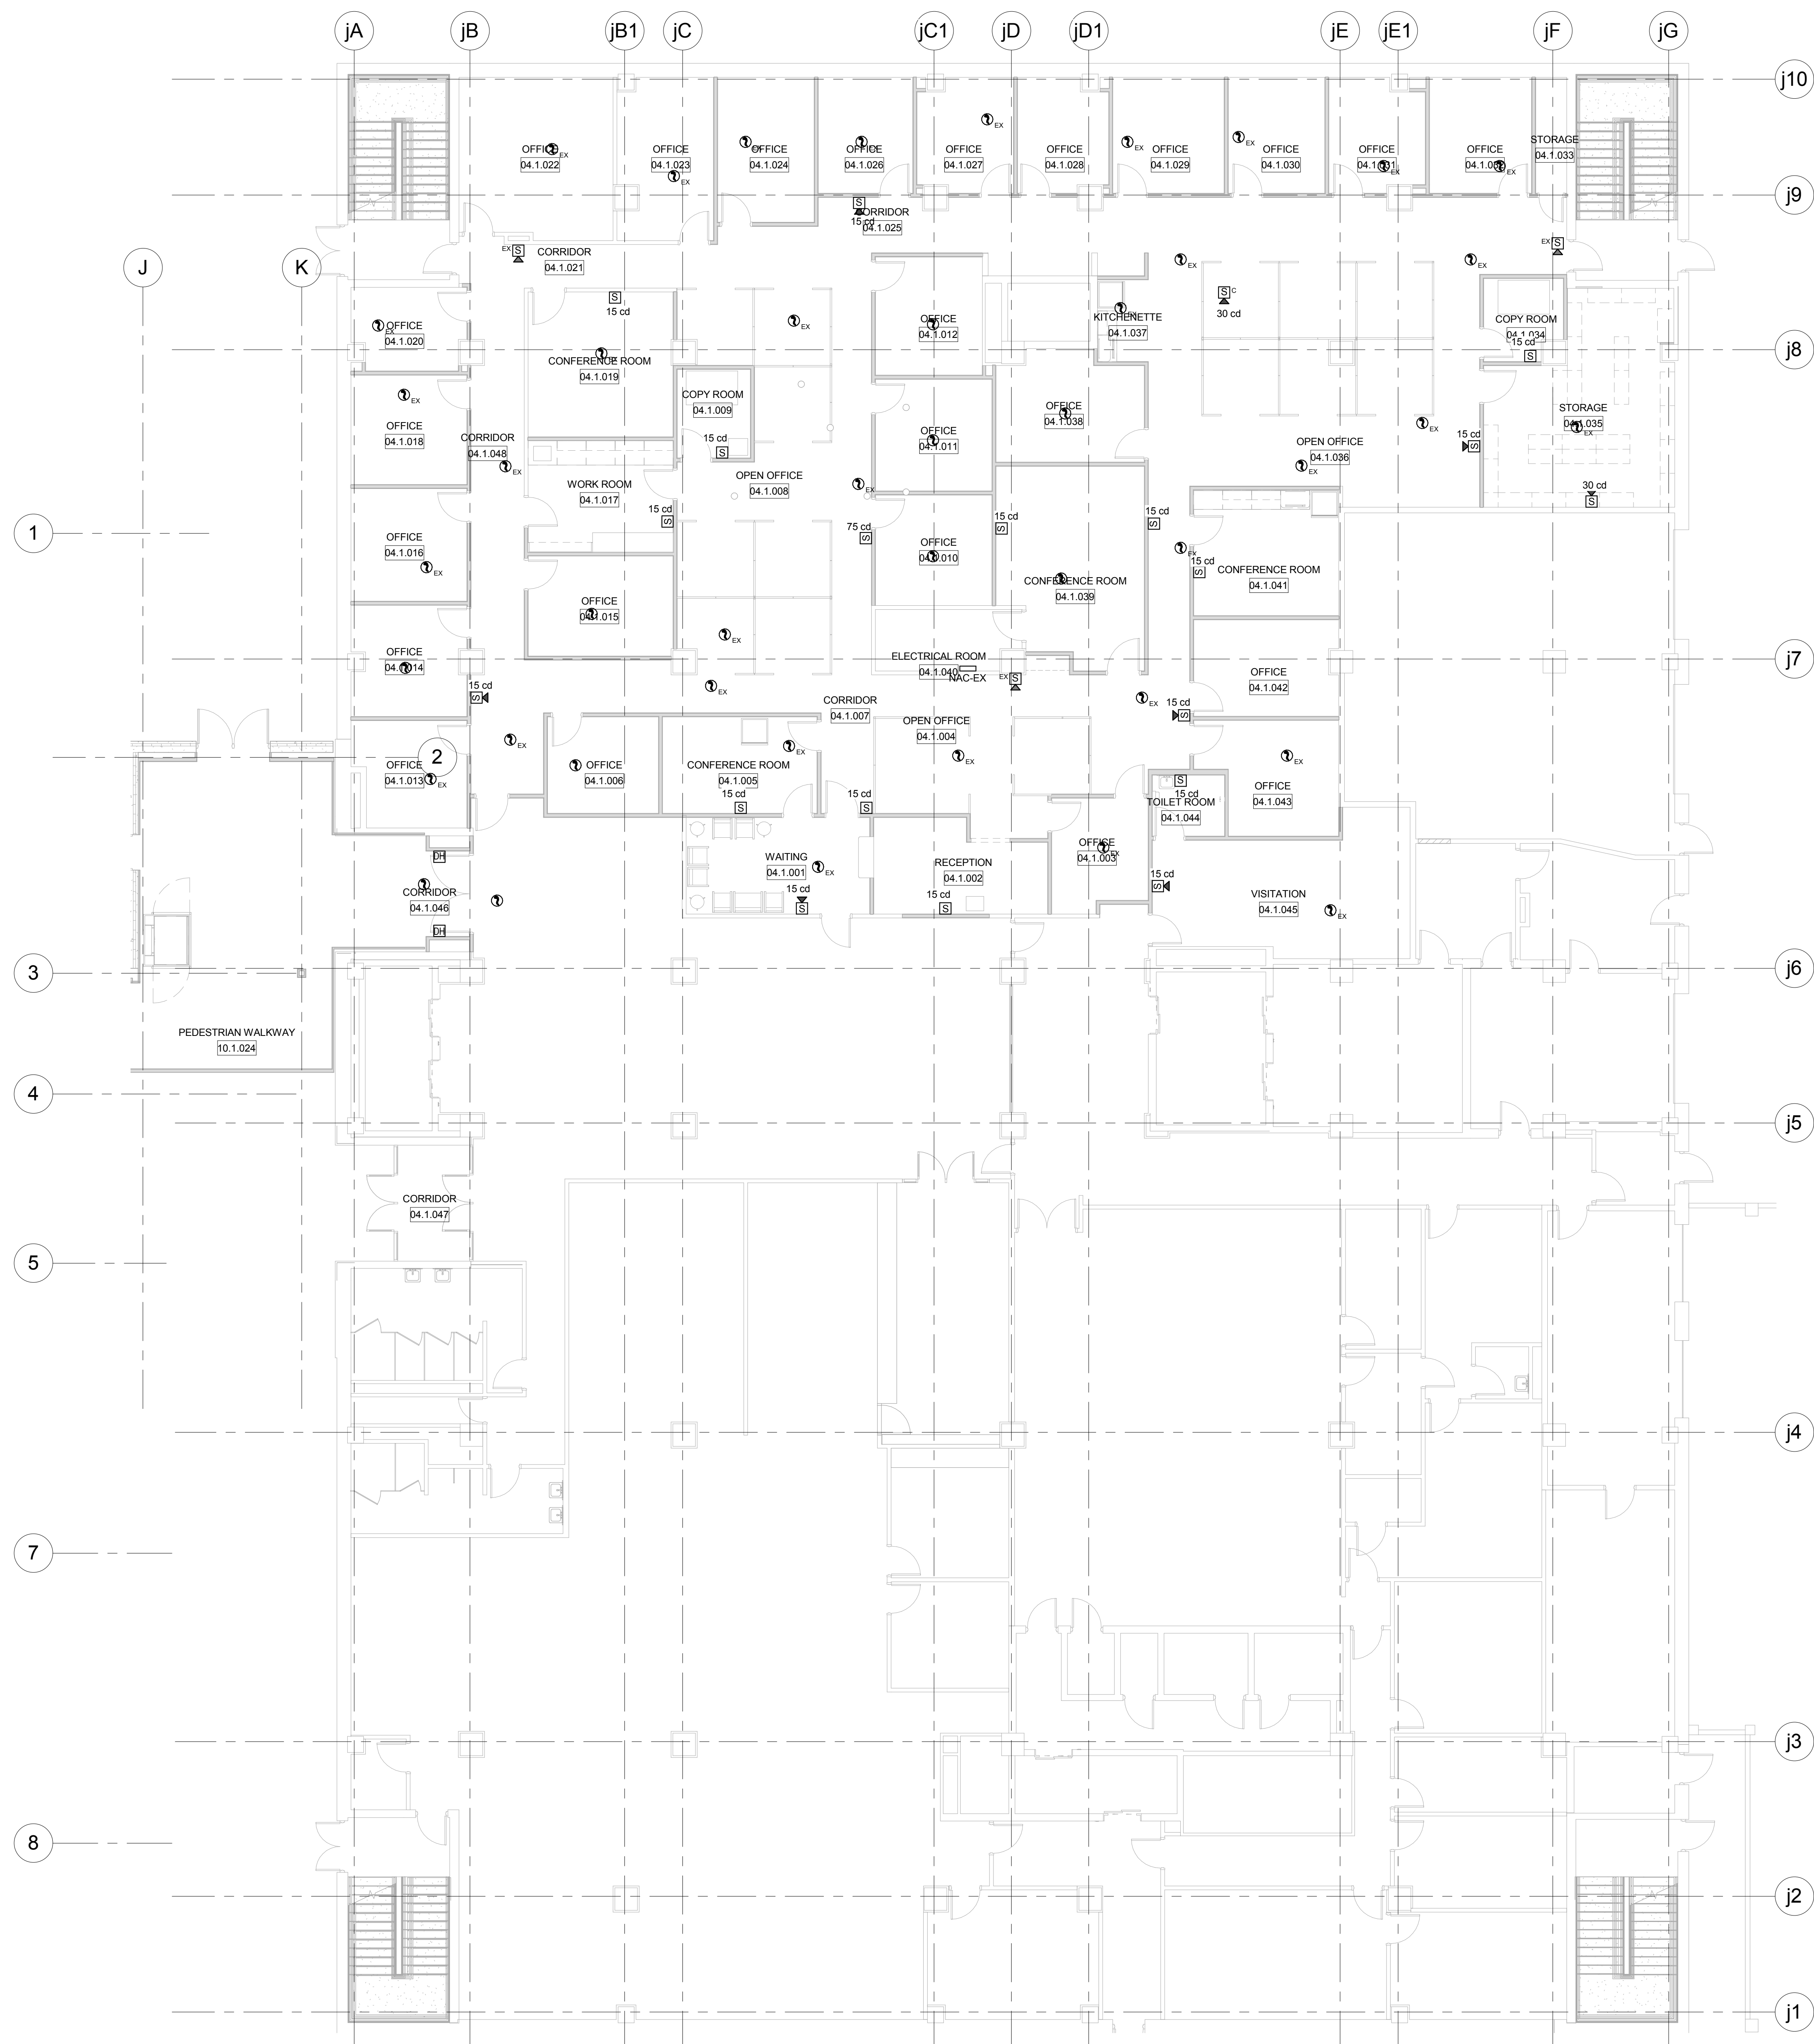

GENERAL NOTES:


A. FIRE ALARM DEVICES IN THIS AREA ARE NOTIFIER DEVICES.

B. REUSE EXISTING FIRE ALARM DEVICES WHERE FEASIBLE.

C. FIRE ALARM DEVICES SHOWN ARE FOR BIDDING PURPOSES ONLY. INSTALLING CONTRACTOR SHALL ENSURE FIRE ALARM DESIGN MEETS STATE, LOCAL, AND NATIONAL CODES.

1 LEVEL 790.00 FIRE ALARM SYSTEM PLAN-JUSTICE CENTER

Scale: 1/8" = 1'-0"

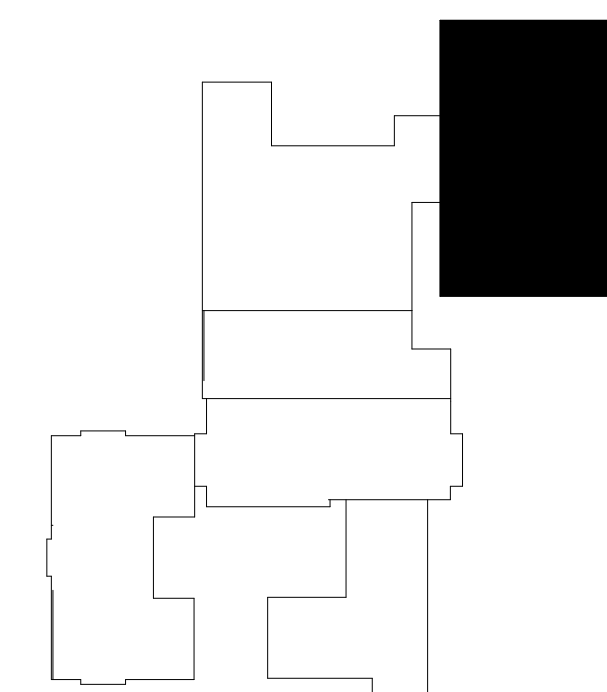

PLAN KEY

McMAHON
ENGINEERS ARCHITECTS
Main Office: 1025 N. Main St., Appleton, WI 54911
Tel: (920) 751-4200 Fax: (920) 751-4284
www.mahon.com

McMahon provides this drawing as a service to the client. It is not to be used for any other purpose without the written consent of McMahon. The client is responsible for obtaining all necessary permits and approvals from the appropriate authorities. McMahon is not responsible for any errors or omissions in this drawing.

REVISION

2

Addendum #2

DATE

4/6/17

NO.

2

DESIGNED

DVM

DRAWN

MAL

PROJECT NO.

00002-61600160

DATE

MARCH 3, 2017

SHEET NO.


FA234

ALTERATION / ADDITION

OUTAGAMIE COUNTY ADMINISTRATION CENTER



S. WALNUT & W. 8TH, APPLETON WI 54911

LEVEL 790.00 FIRE ALARM SYSTEM PLAN-JUSTICE CENTER

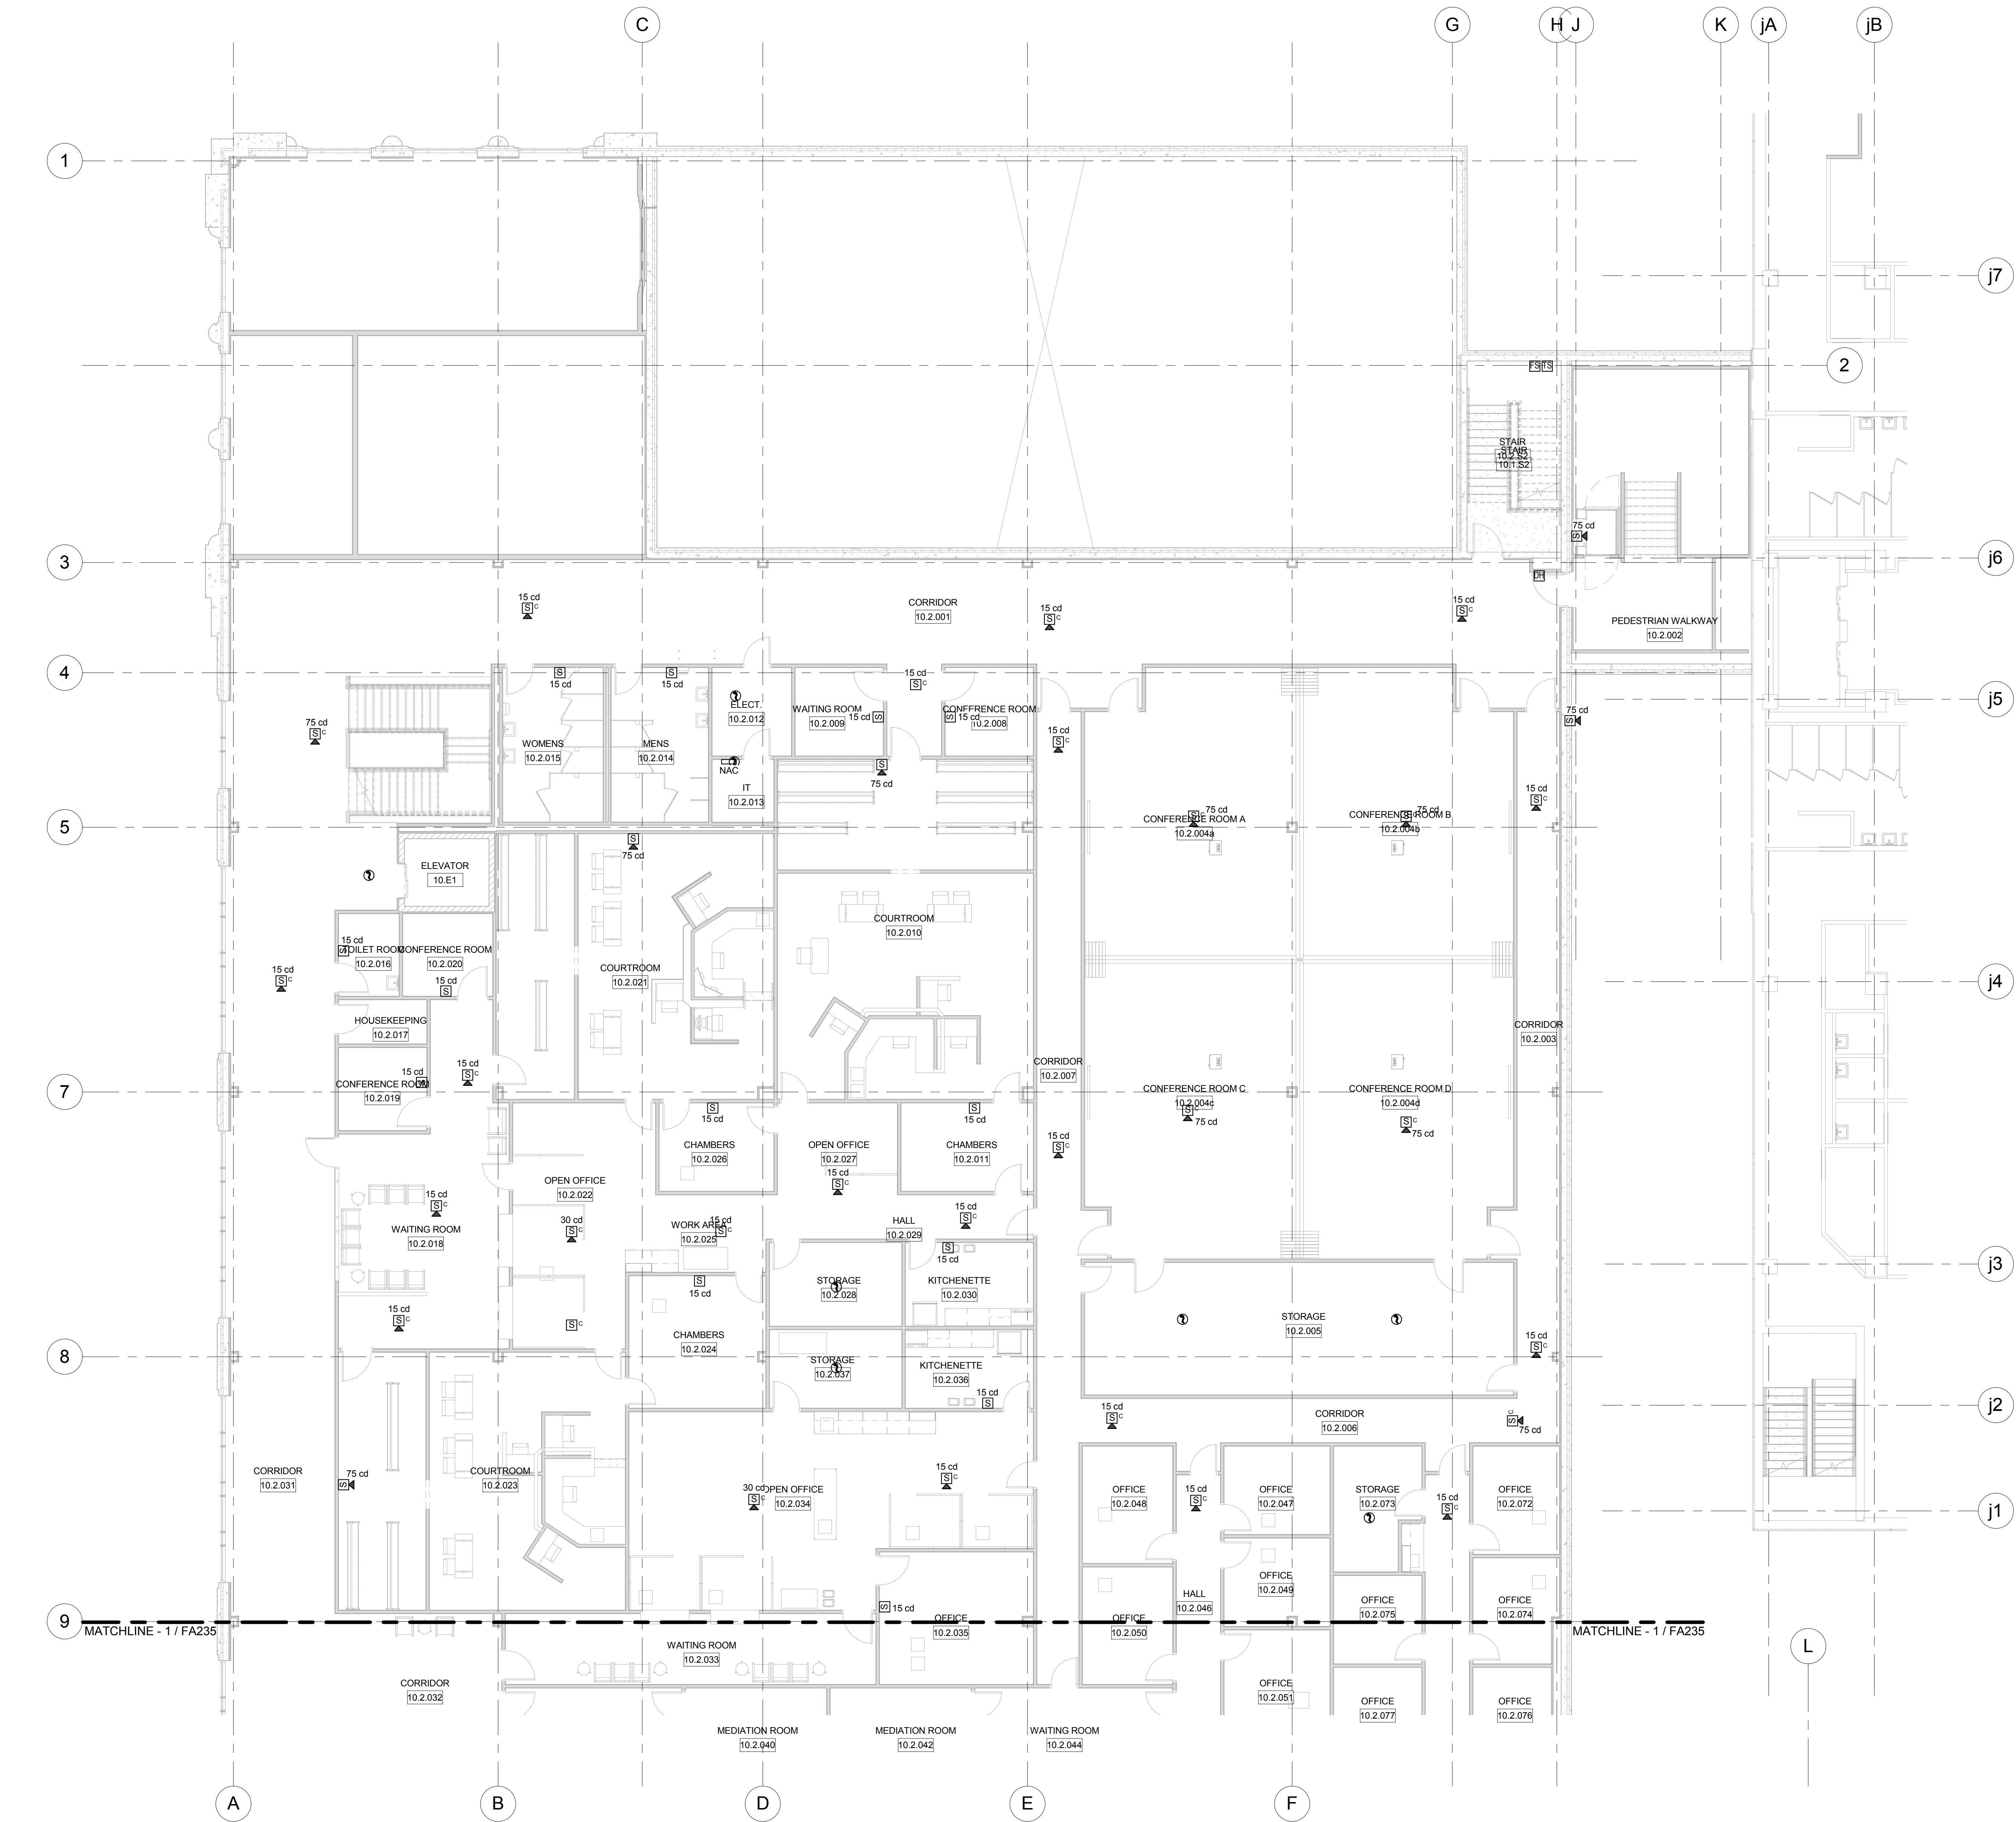

1 LEVEL 805.00 FIRE ALARM SYSTEM PLAN-OCAC NORTH
Scale: 1/8" = 1'-0"

GENERAL NOTES:
A. FIRE ALARM DEVICES IN THIS AREA ARE NOTIFIER DEVICES.
B. REUSE EXISTING FIRE ALARM DEVICES WHERE FEASIBLE.
C. FIRE ALARM DEVICES SHOWN ARE FOR BIDDING PURPOSES ONLY. INSTALLING CONTRACTOR SHALL ENSURE FIRE ALARM DESIGN MEETS STATE, LOCAL, AND NATIONAL CODES.

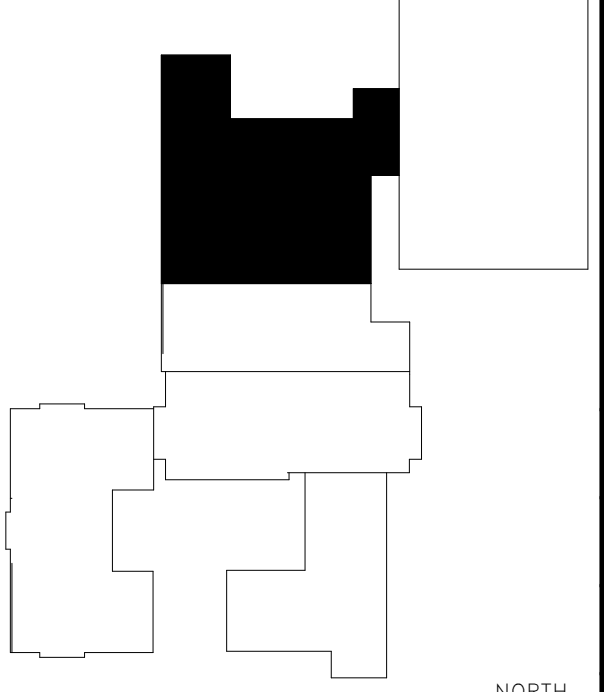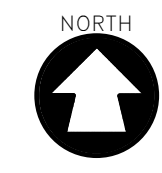

McMAHON

ENGINEERS ARCHITECTS

McMAHON ENGINEERS ARCHITECTS

1005 N. KENNA RD. SUITE 200
MILWAUKEE, WI 53226
Tel: (414) 754-4200 Fax: (414) 754-4284
www.mahon.com

McMahon provides this drawing as a service to the client. It is not to be used for any other purpose without the written consent of McMahon. The client is responsible for ensuring that the drawing is used in accordance with the terms of the contract. McMahon is not responsible for any errors or omissions in this drawing. McMahon is not responsible for any changes made to the original drawing without the written consent of McMahon.

REVISION

2 4/4/17 Addendum #2

DESIGNED

DVM

DRAWN

MAL

PROJECT NO.

00002-61600160

DATE

MARCH 3, 2017

SHEET NO.


FA236

ALTERATION / ADDITION

OUTAGAMIE COUNTY ADMINISTRATION CENTER


S. WALNUT & W. 8TH, APPLETON WI 54911

LEVEL 805.00 FIRE ALARM SYSTEM PLAN-OCAC NORTH

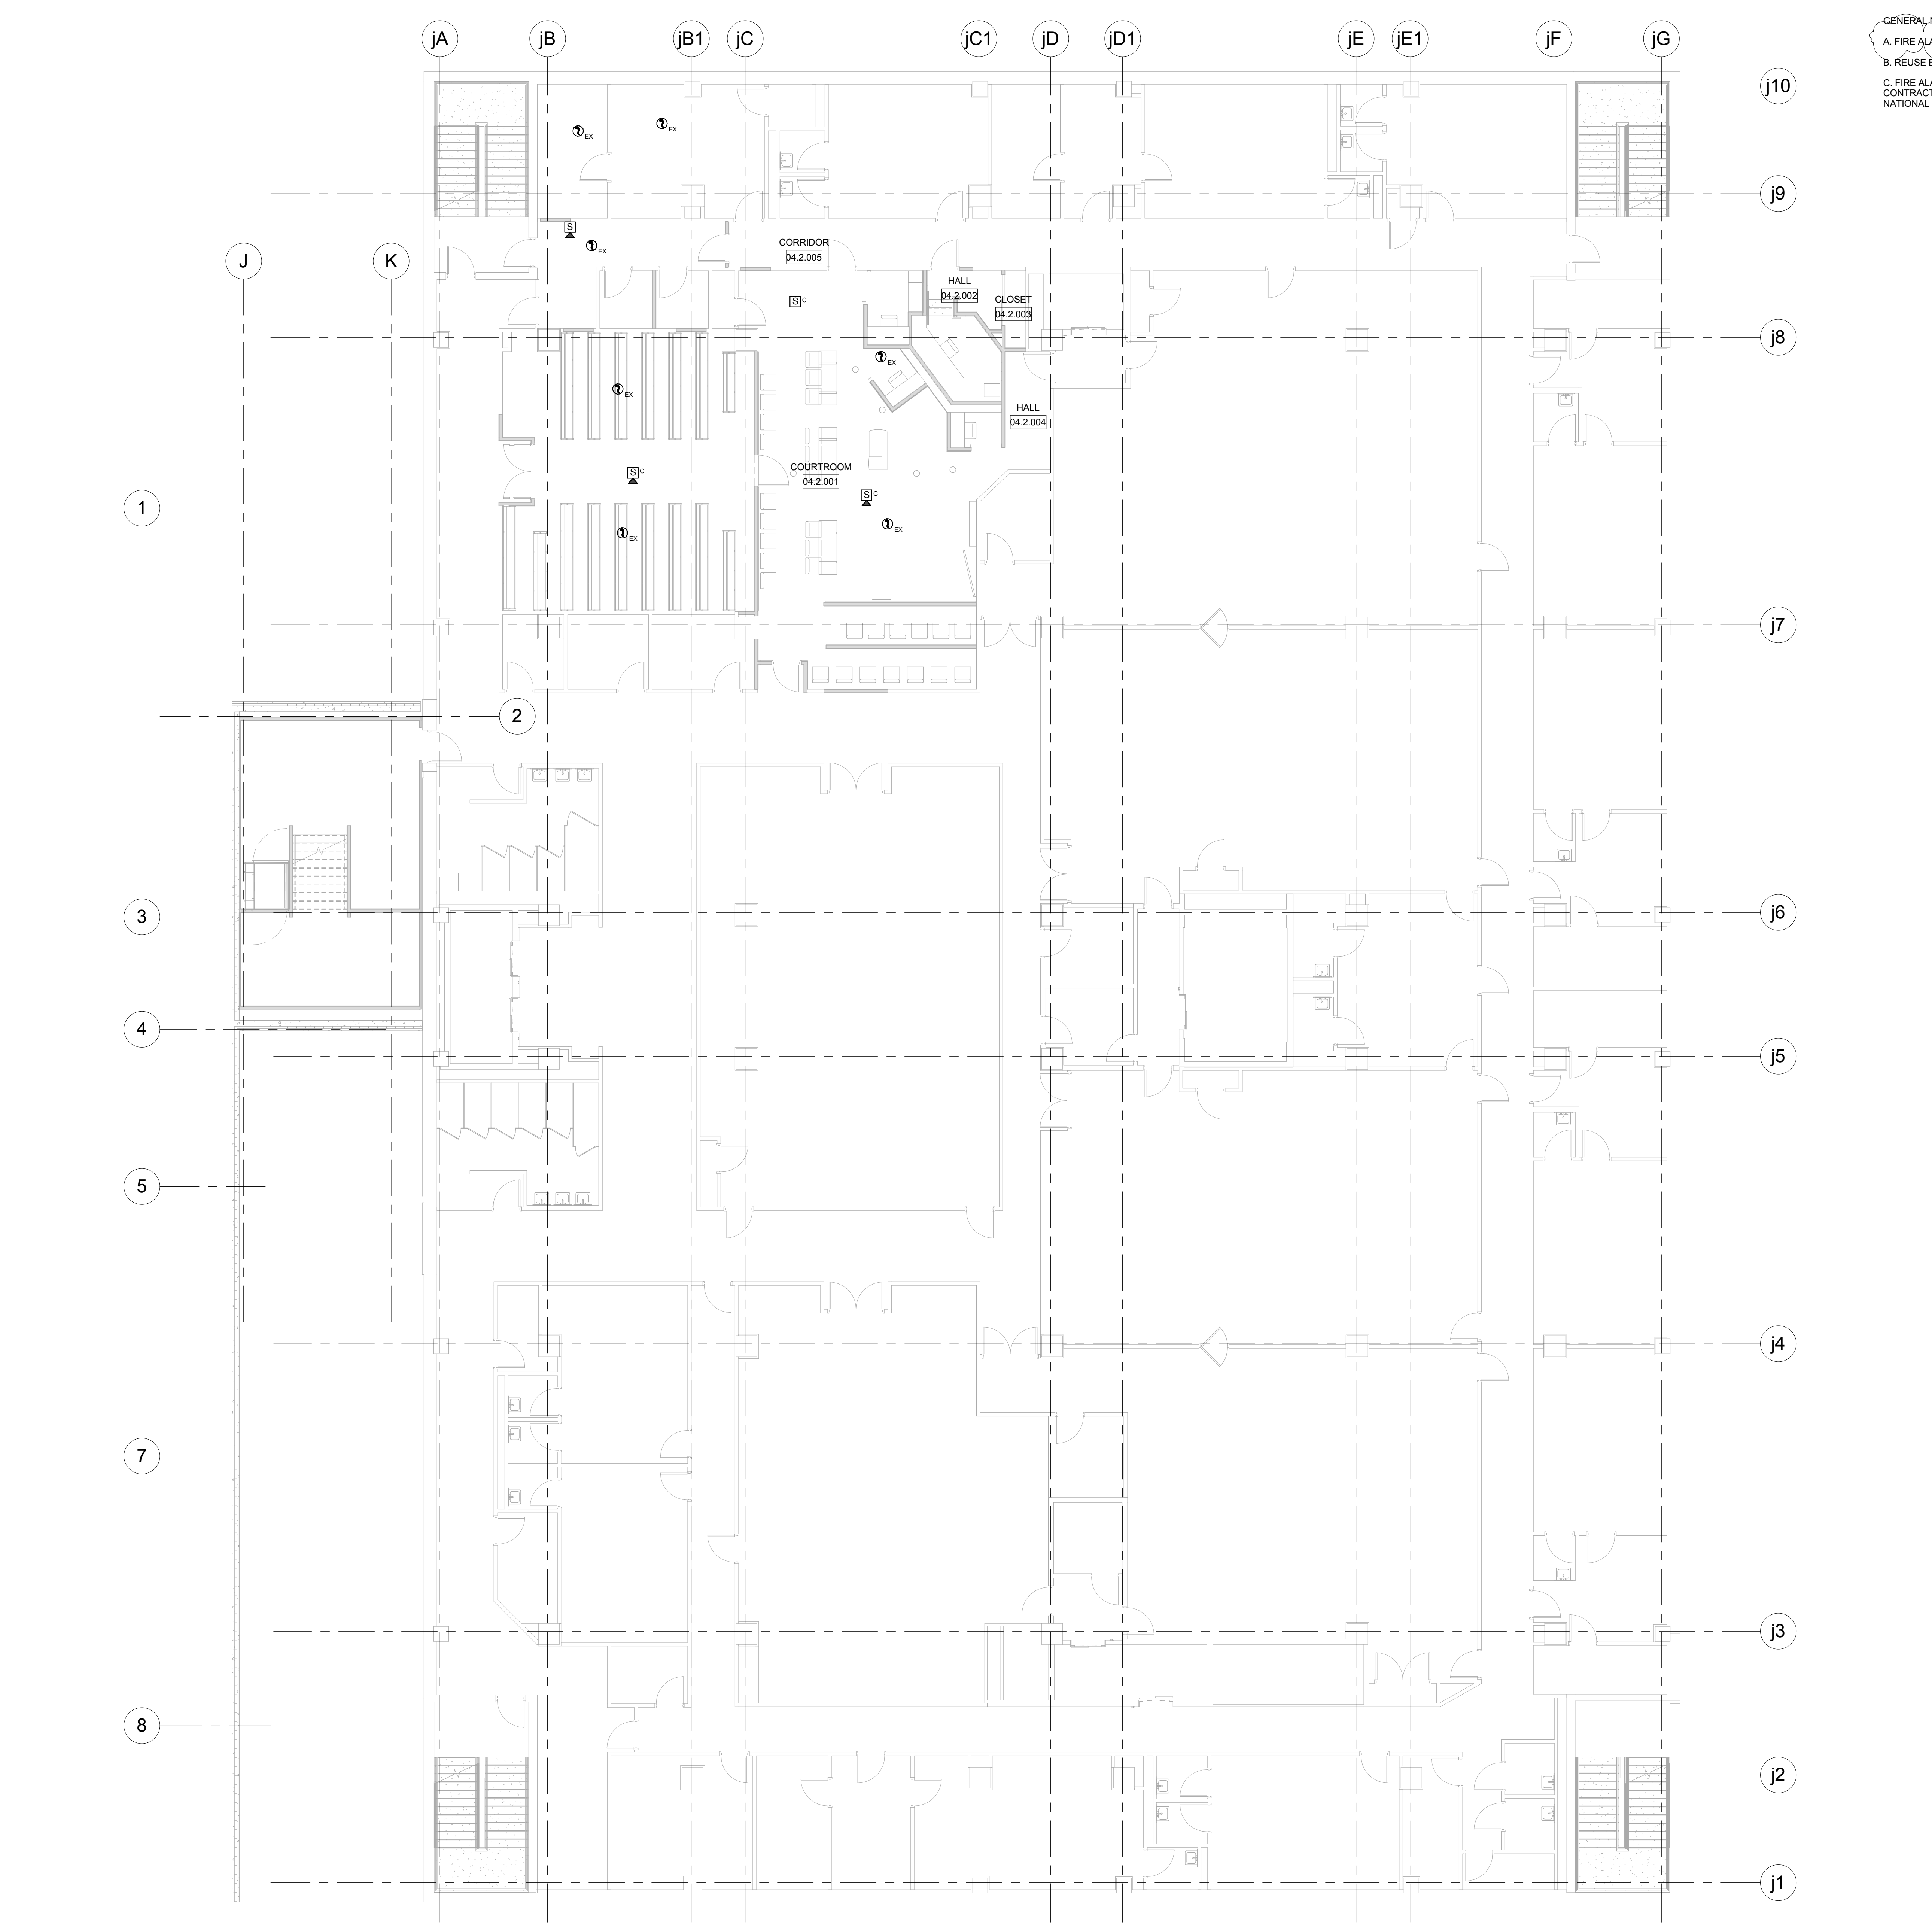

GENERAL NOTES:
A. FIRE ALARM DEVICES IN THIS AREA ARE NOTIFIER DEVICES.
B. REUSE EXISTING FIRE ALARM DEVICES WHERE FEASIBLE.
C. FIRE ALARM DEVICES SHOWN ARE FOR BIDDING PURPOSES ONLY. INSTALLING CONTRACTOR SHALL ENSURE FIRE ALARM DESIGN MEETS STATE, LOCAL, AND NATIONAL CODES.

1 LEVEL 805.00 FIRE ALARM SYSTEM PLAN-JUSTICE CENTER
Scale: 1/8" = 1'-0"

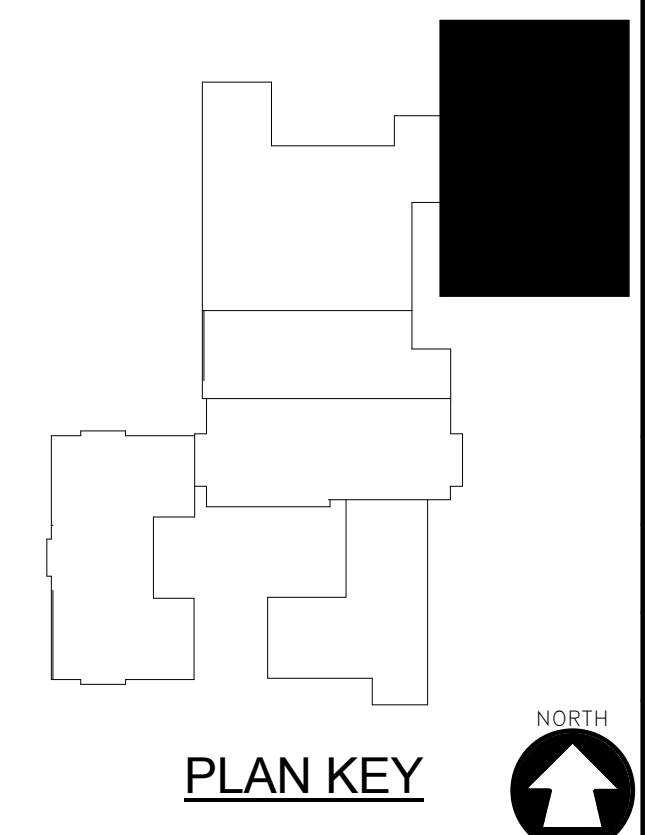

McMAHON

ENGINEERS ARCHITECTS

McMahon provides this drawing as instruments of service. All work is subject to the terms and conditions set forth in the contract. The client agrees to indemnify and hold McMahon harmless from and against all claims, damages, costs and expenses, including reasonable attorneys' fees, arising out of or from the use of this drawing, whether or not such claims, damages, costs and expenses are caused in whole or in part by the negligence of McMahon.

Mailing: P.O. BOX 1025 NEENAH, WI 54957-1025
Tel: (920) 751-4200 Fax: (920) 751-4284
www.mahon.com

NO.	DATE	REVISION
2	4/6/17	Addendum #2

ALTERATION / ADDITION
OUTAGAMIE COUNTY ADMINISTRATION CENTER
S. WALNUT & W. 8TH, APPLETON WI 54911
LEVEL 805.00 FIRE ALARM SYSTEM PLAN-JUSTICE CENTER

DESIGNED	DVM	DRAWN	MAL
PROJECT NO. 00002-61600160			
DATE MARCH 3, 2017			
SHEET NO. FA237			