



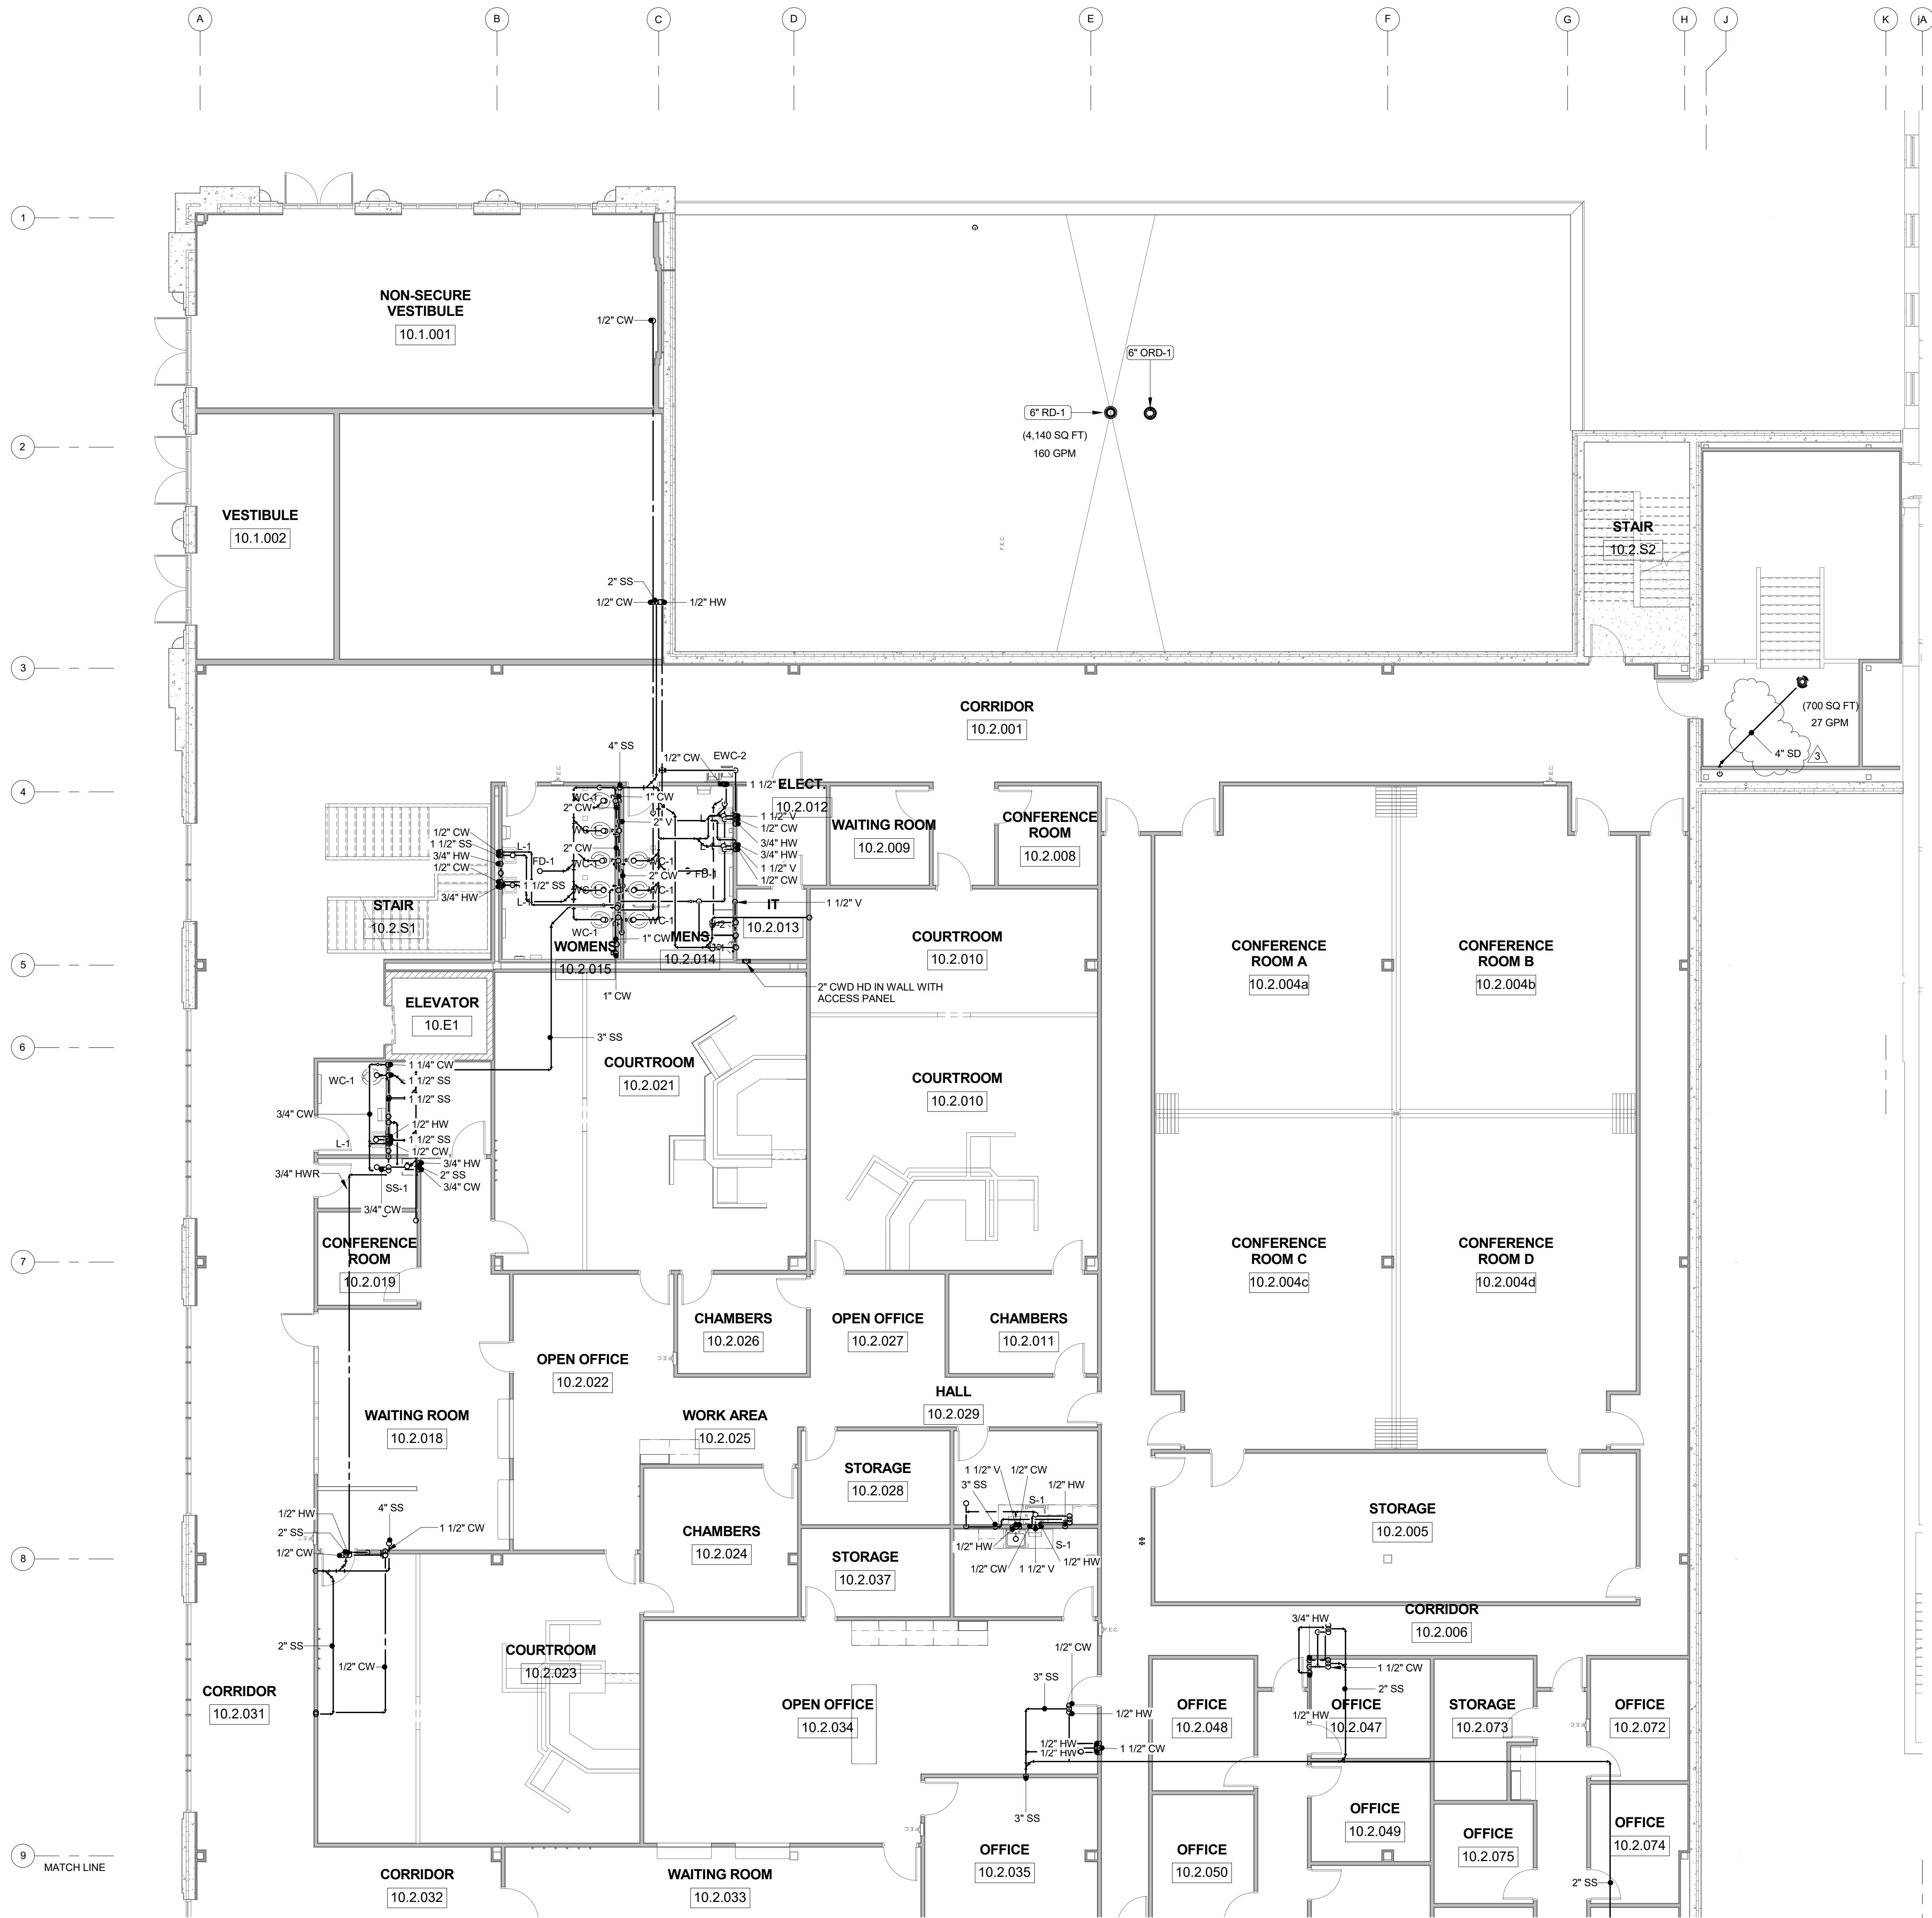

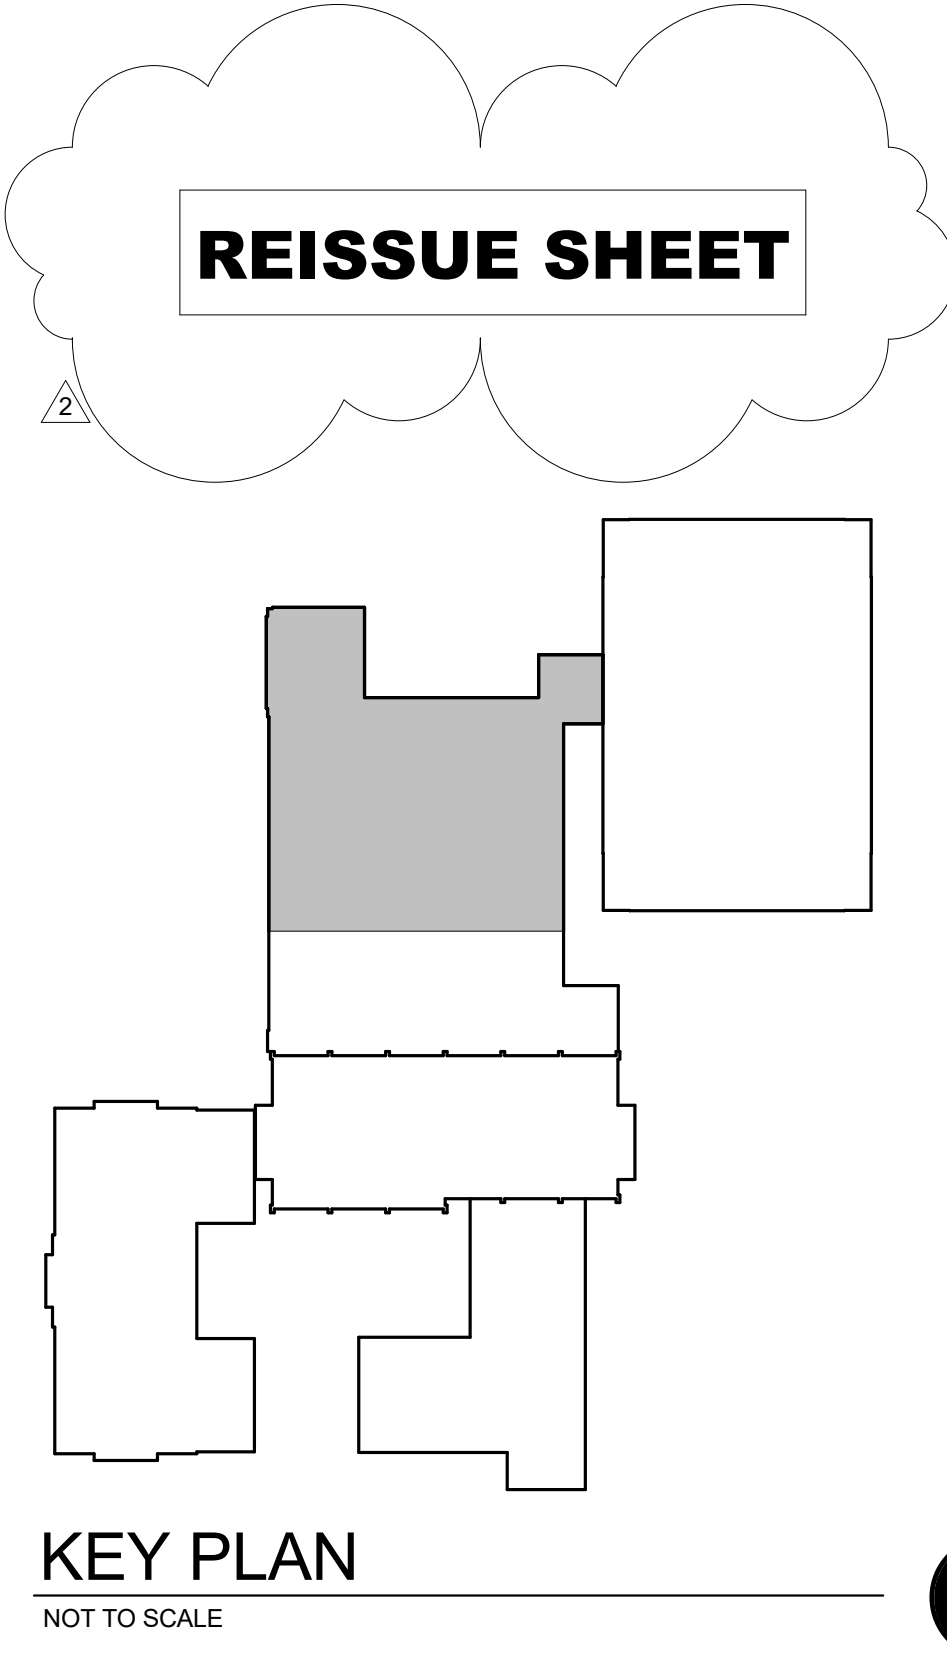

PLUMBING LEGEND

- CW = COLD WATER
- HW = HOT WATER
- HWR = HOT WATER RECIRCULATING
- SS = SANITARY DRAIN
- V = VENT
- SD = STORM DRAIN
- OSD = OVERFLOW STORM DRAIN
- CWD = CLEAR WATER DRAIN
- FD = FLOOR DRAIN
- FCO = FLOOR CLEANOUT
- CO = CLEAN OUT
- RD = ROOF DRAIN
- ORD = OVERFLOW ROOF DRAIN
- VTR = VENT THROUGH ROOF




McMahon provides this drawing as instruments of service. All work shall be in accordance with the contract documents and the applicable building codes. The client shall be responsible for obtaining all necessary permits and for the accuracy of the information provided. McMahon shall not be responsible for any errors or omissions in this drawing or for any consequences arising therefrom. McMahon reserves the right to make changes to this drawing without notice.


REVISION	
NO.	DATE
1	4/6/17
2	4/6/17
3	4/6/17

ALTERATION / ADDITION
OUTAGAMIE COUNTY ADMINISTRATION CENTER
S. WALNUT & W. 8TH, APPLETON, WI 54911
LEVEL 805.00 - ENLARGED PLUMBING PLAN - OCAC NORTH


DESIGNED	DRAWN
NDK	NDK
PROJECT NO.	
00002-61600160	
DATE	
MARCH 3, 2017	
SHEET NO.	
P229	

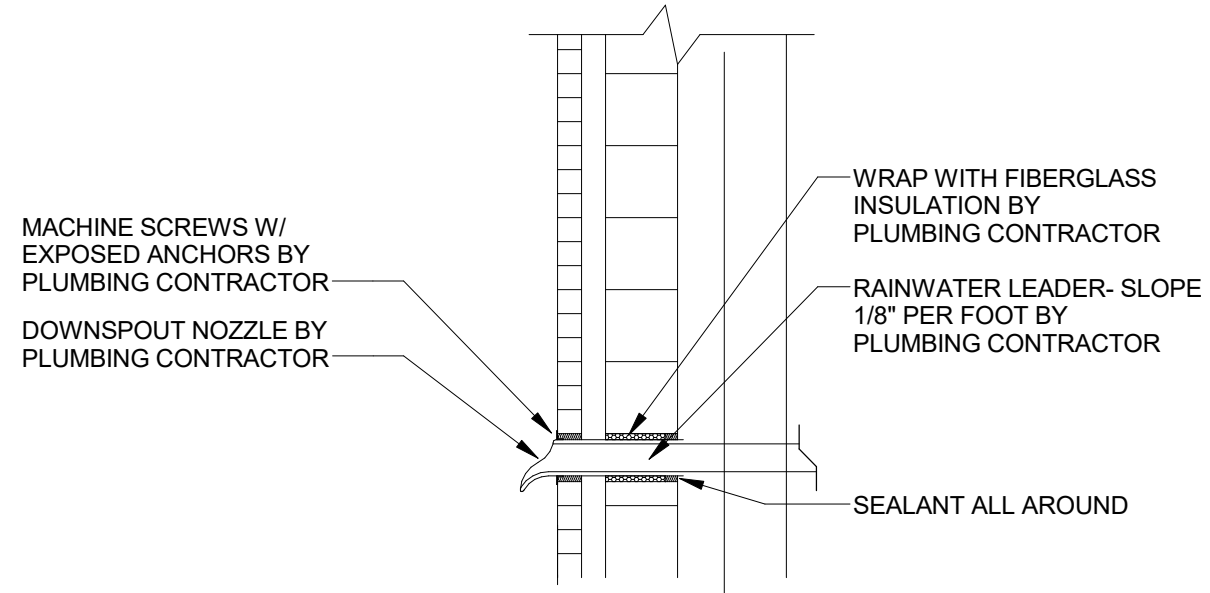


7 RAINWATER LEADER NOZZLE OUTLET DETAIL
P501 1/8" = 1'-0" 0 4' 8' 16'

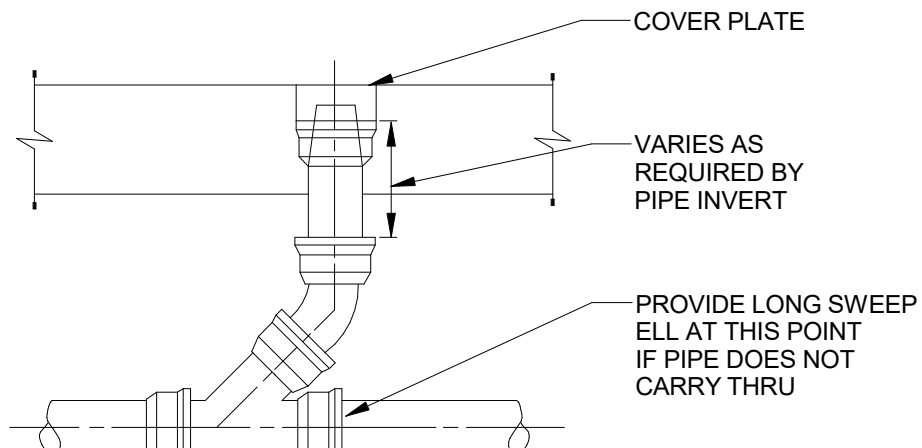


8 CLEAN OUT AND PLUGGED RISER
P501 1/8" = 1'-0" 0 4' 8' 16'

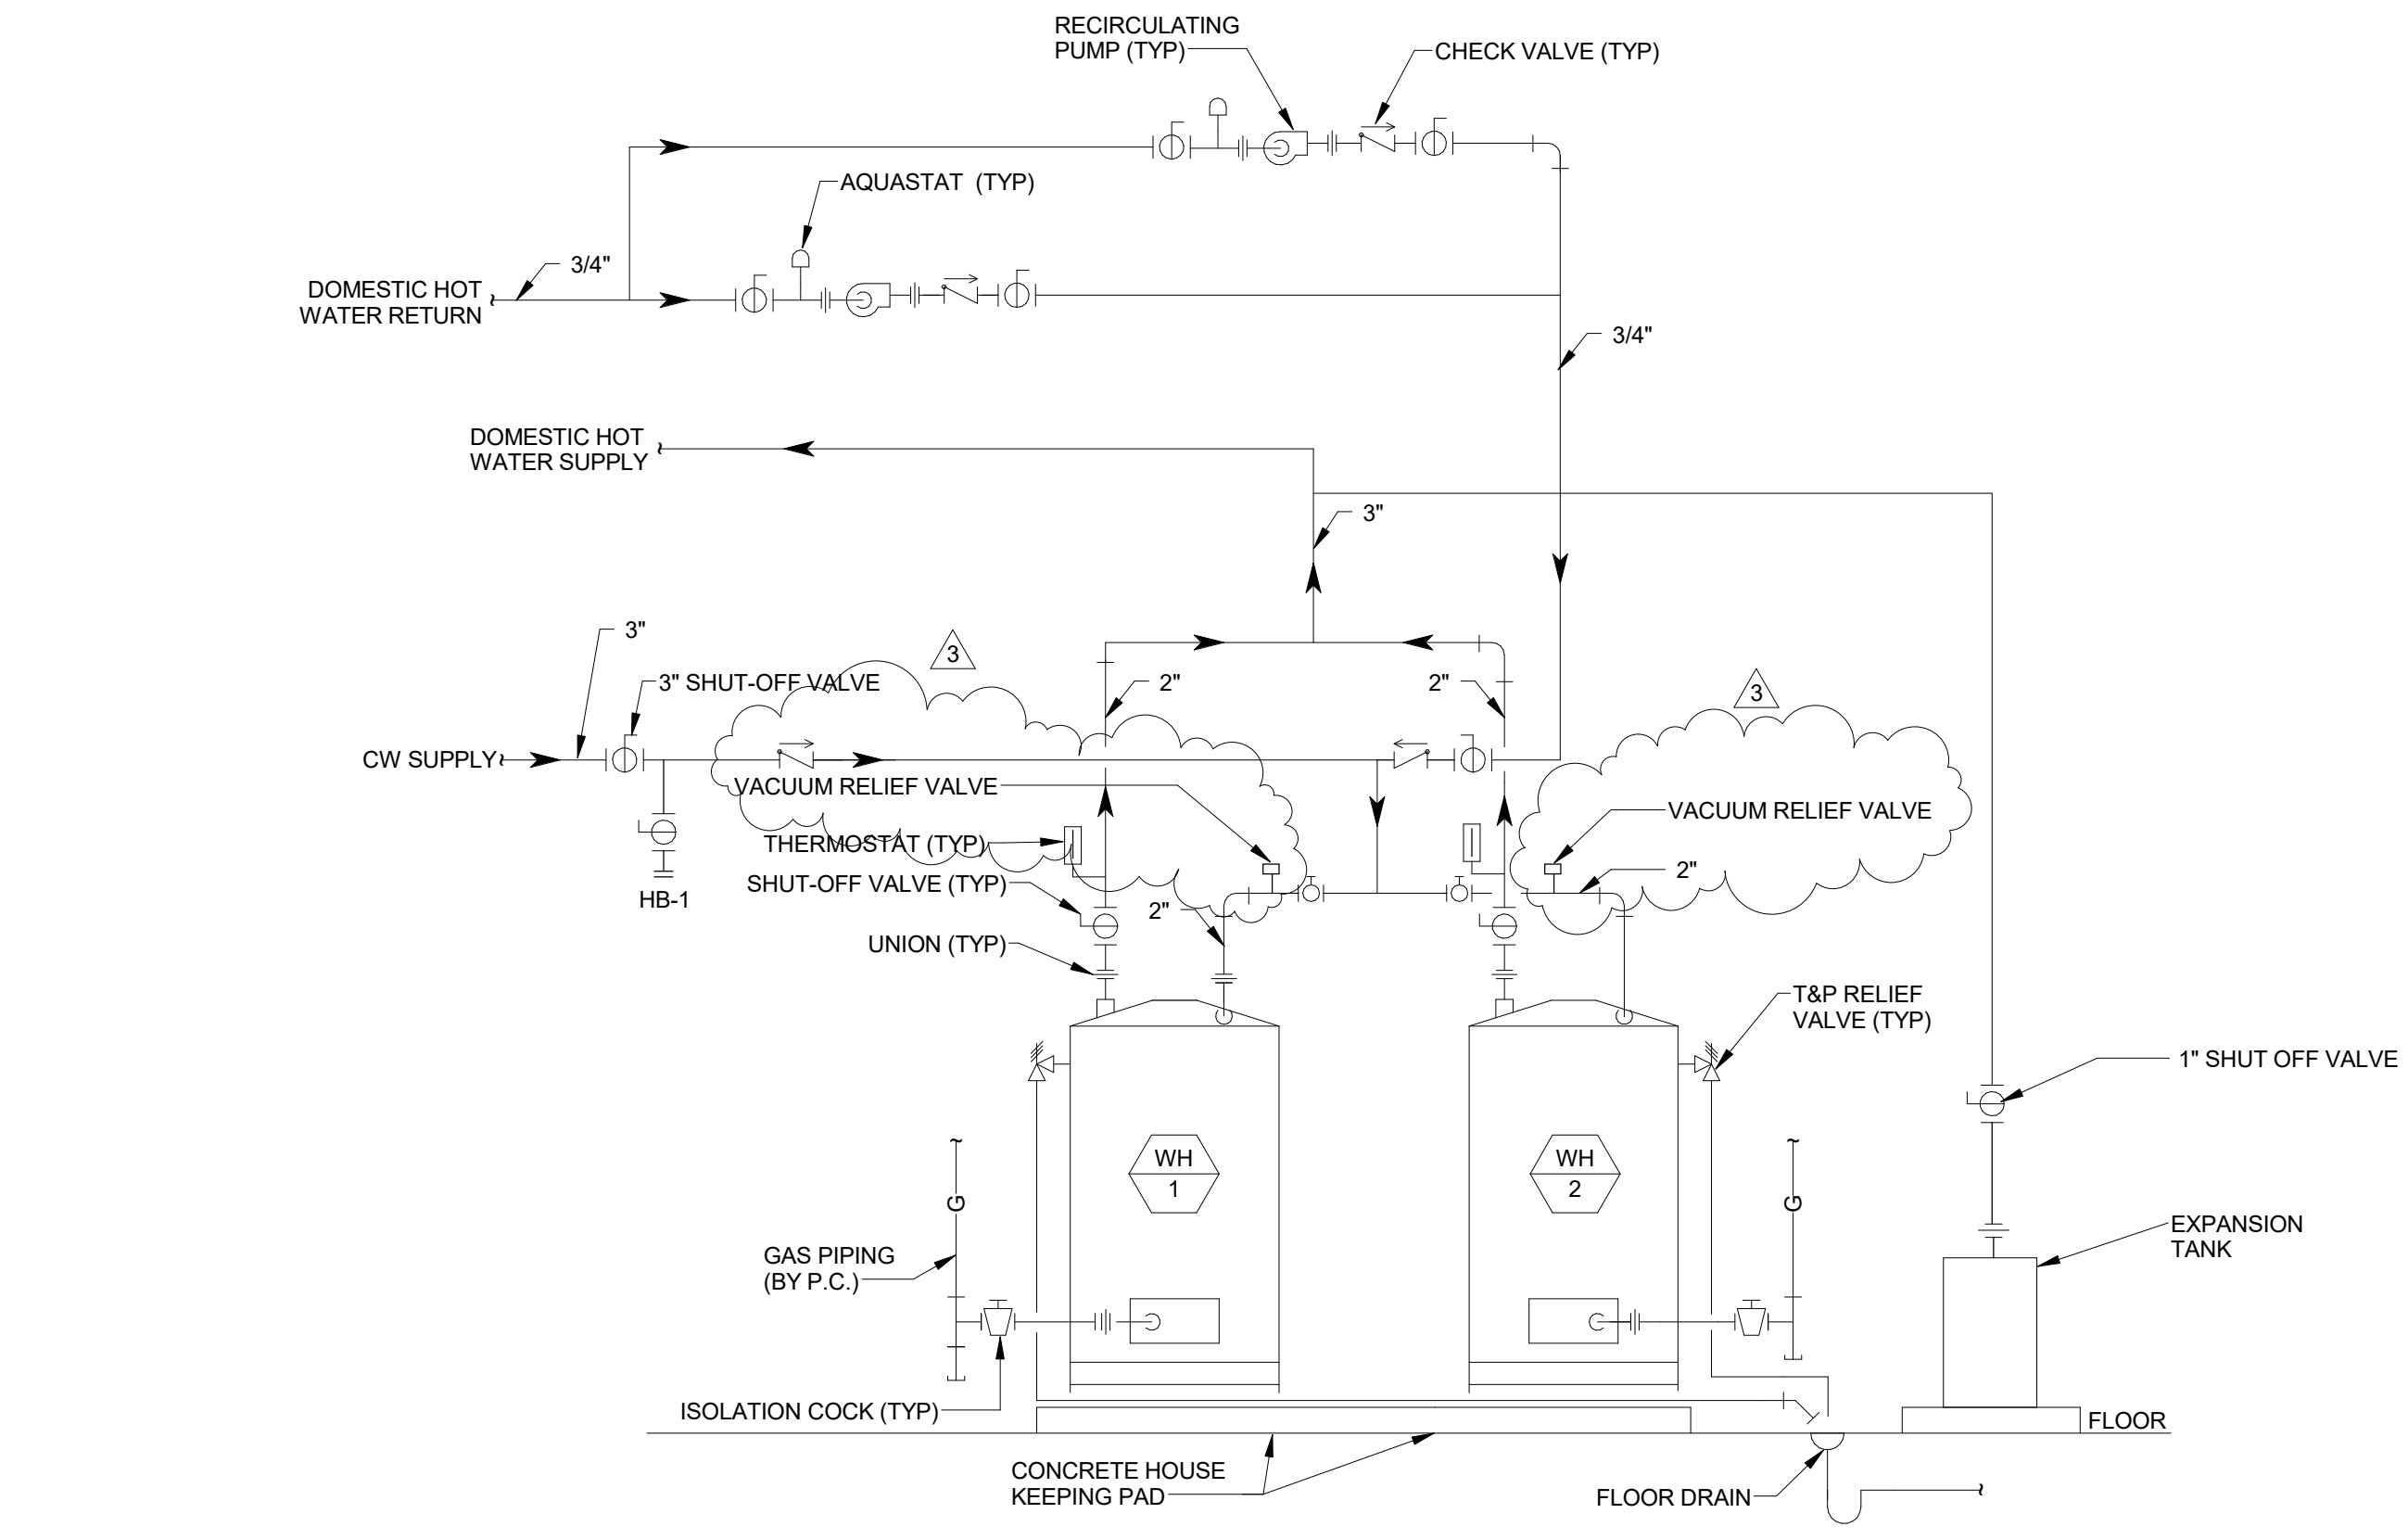


1 WATER HEATER PIPING DETAIL - TWO HEATERS
P501 1/8" = 1'-0" 0 4' 8' 16'

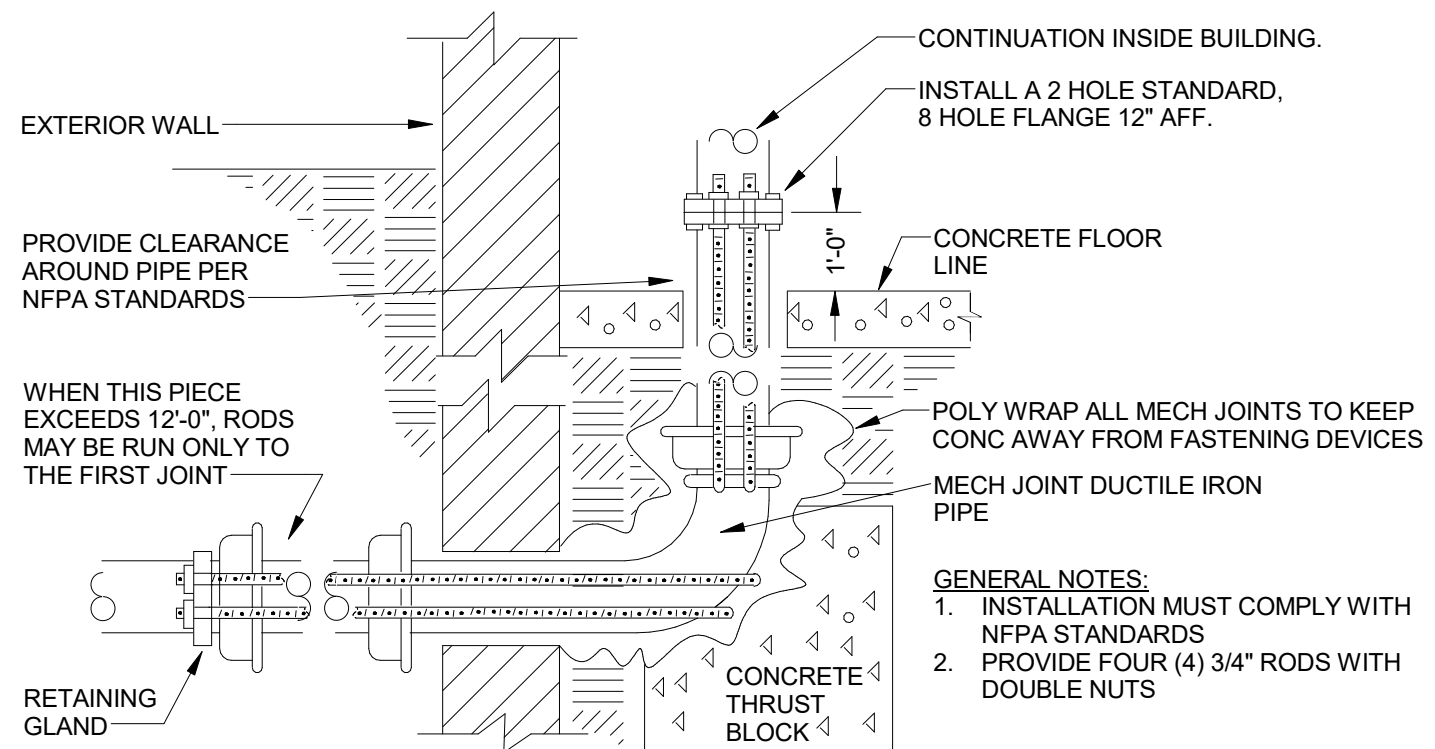


8 WATER SERVICE LINE EXTENSION DETAIL
P501 NO SCALE 0 4' 8' 16'

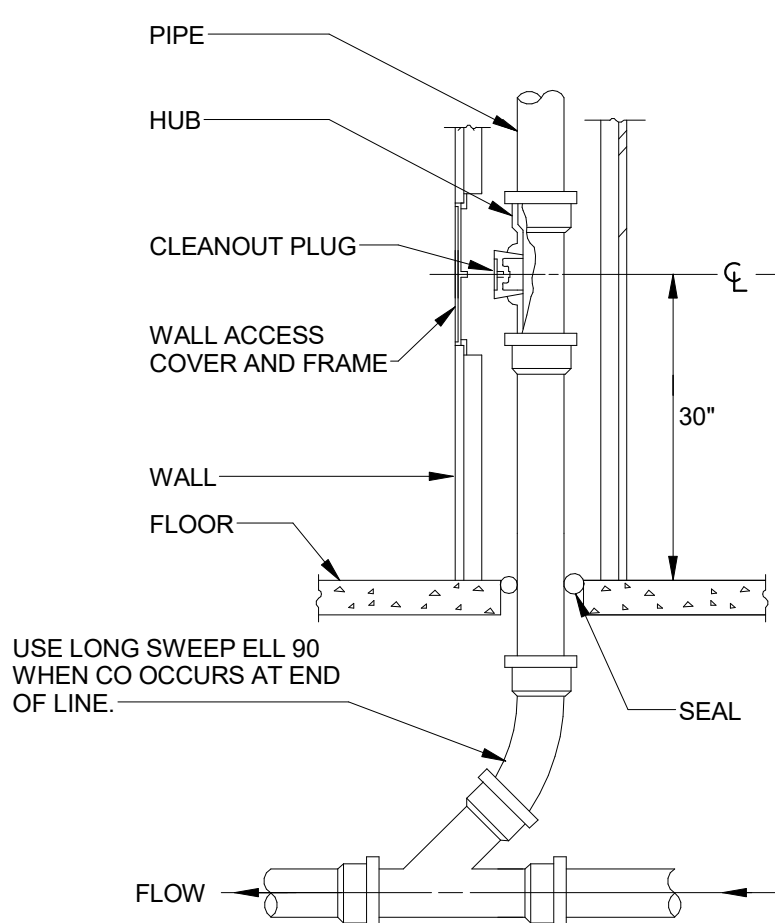


5 WALL CLEAN OUT DETAIL
P501 1/8" = 1'-0" 0 4' 8' 16'

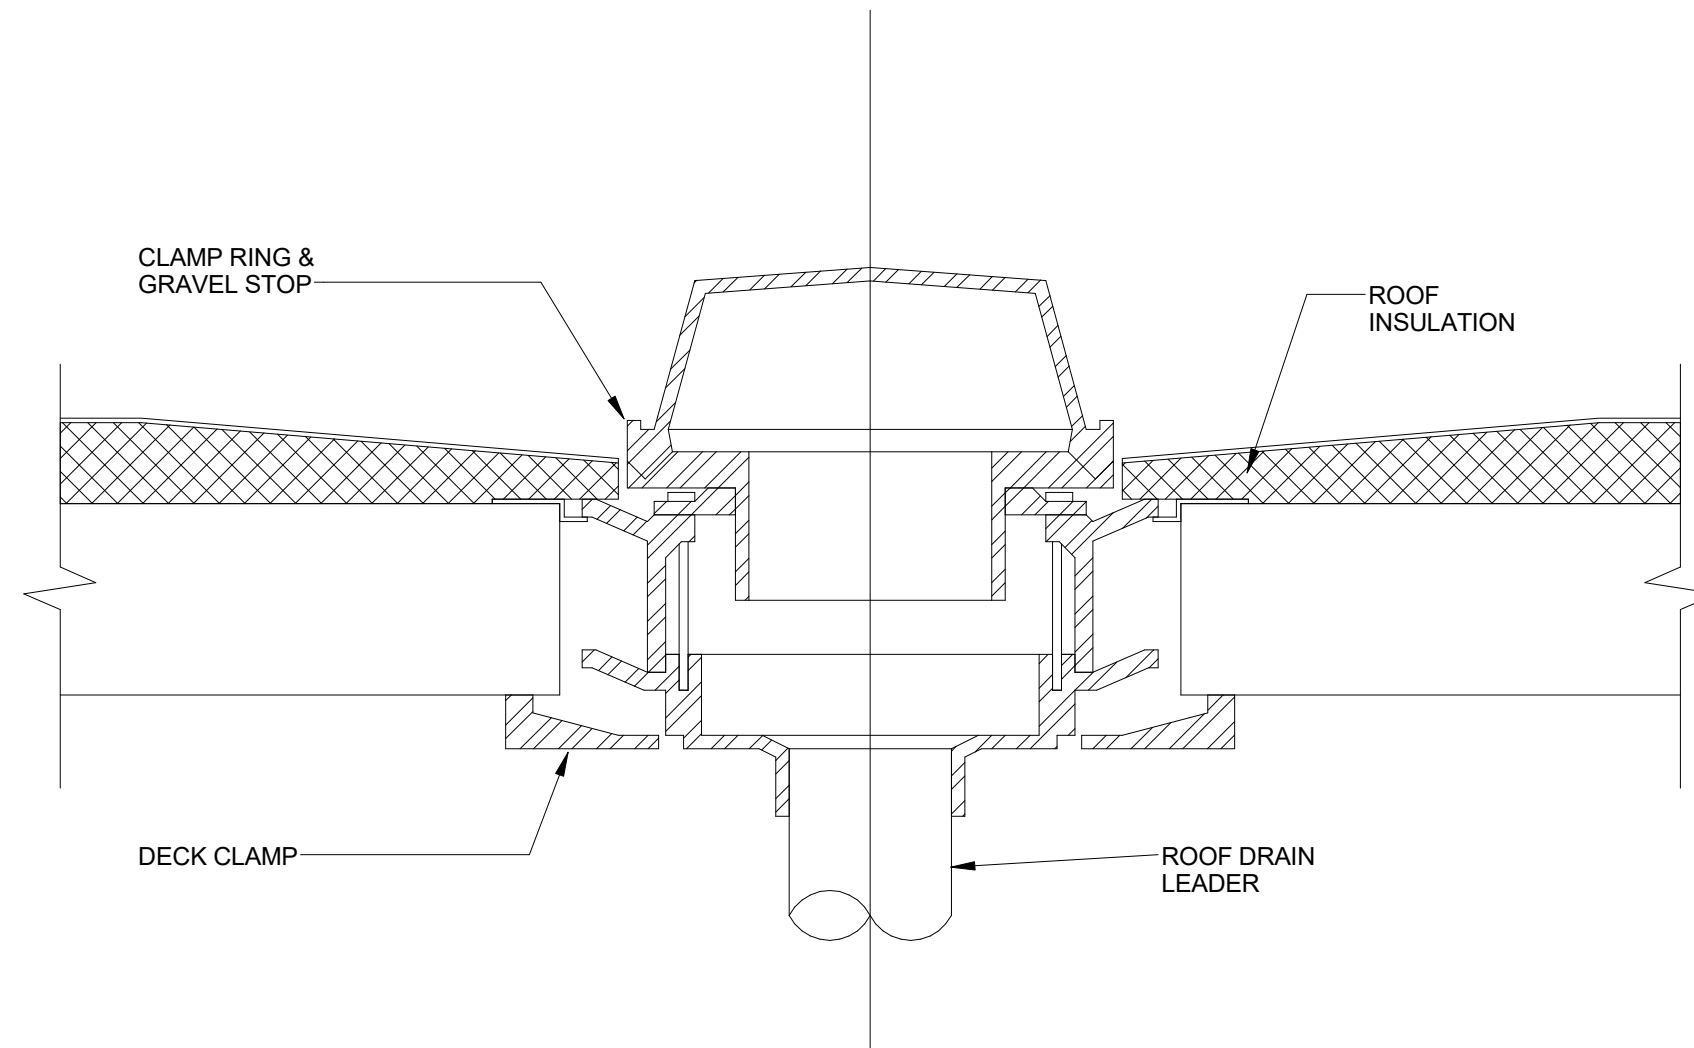


2 ROOF DRAIN DETAIL
P501 1/4" = 1'-0" 0 4' 8' 16'

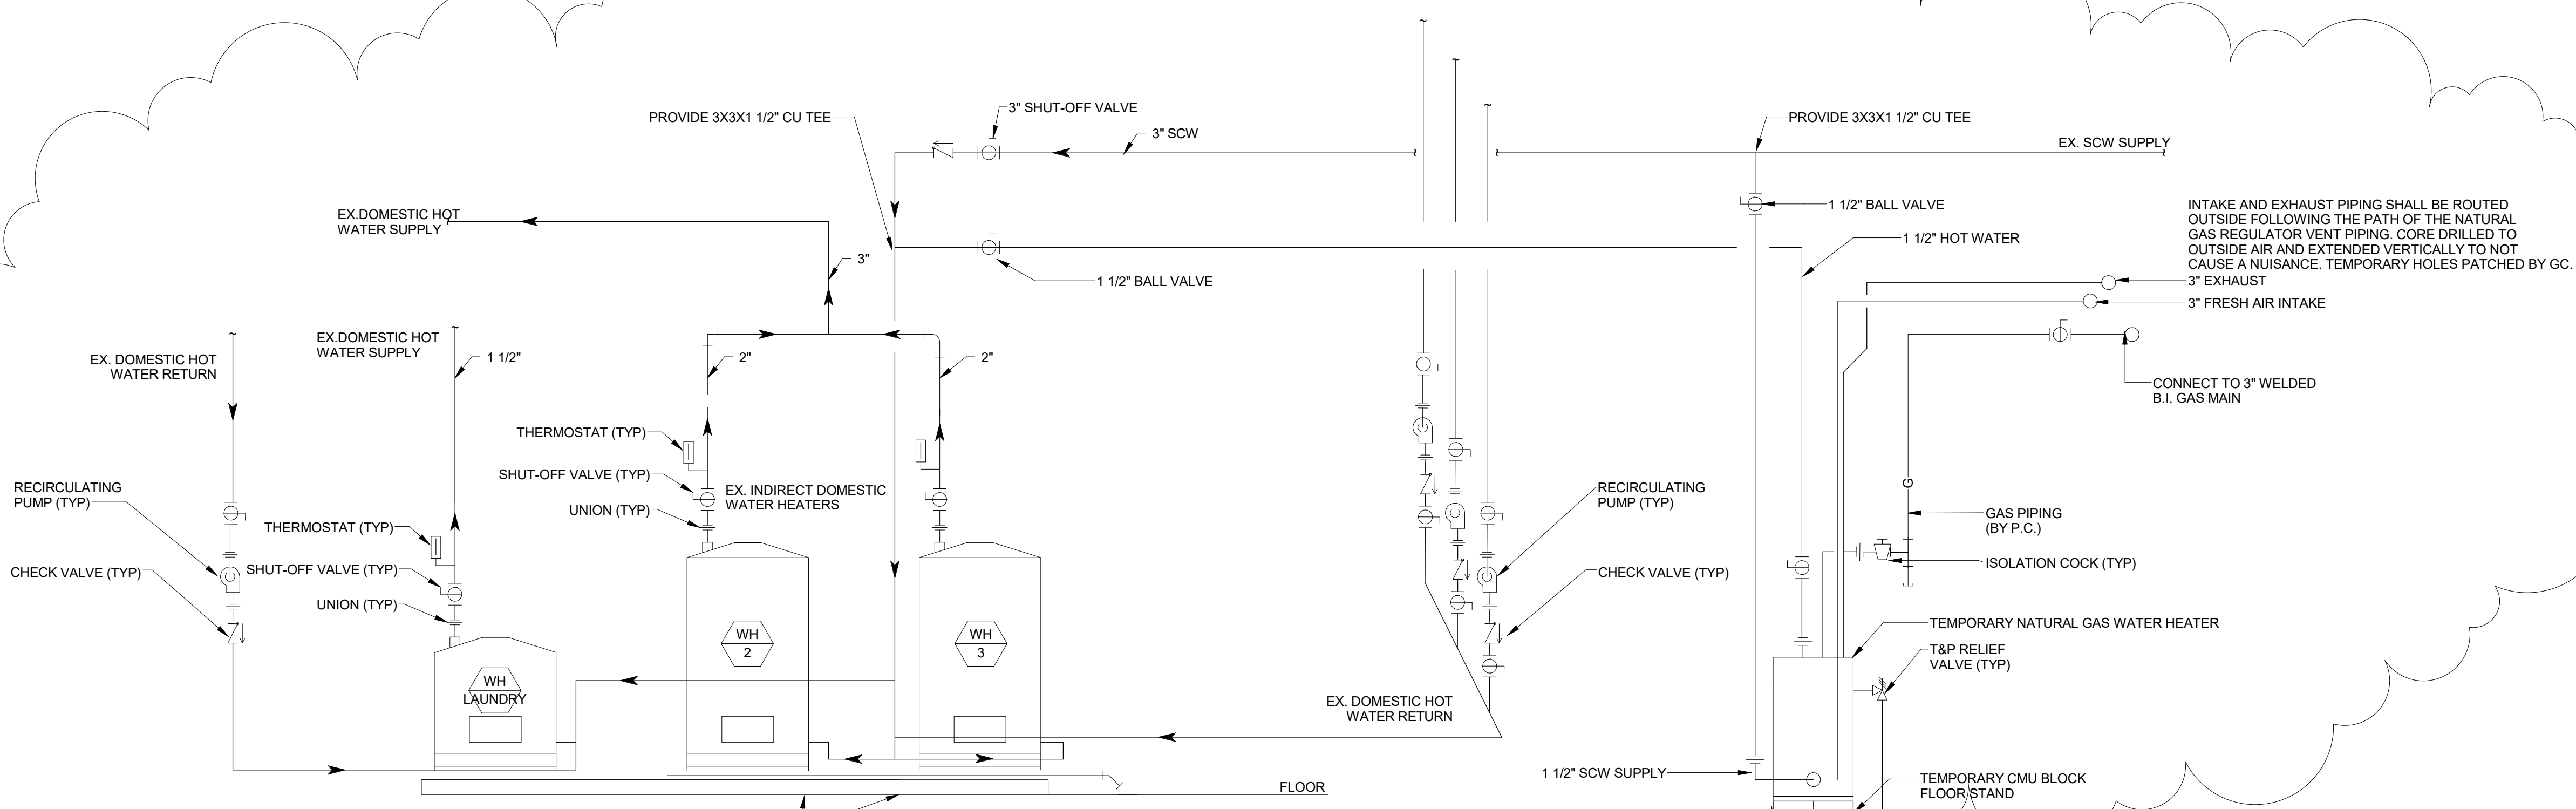

WATER HEATER PIPING DETAIL - JUSTICE CENTER
NOT TO SCALE

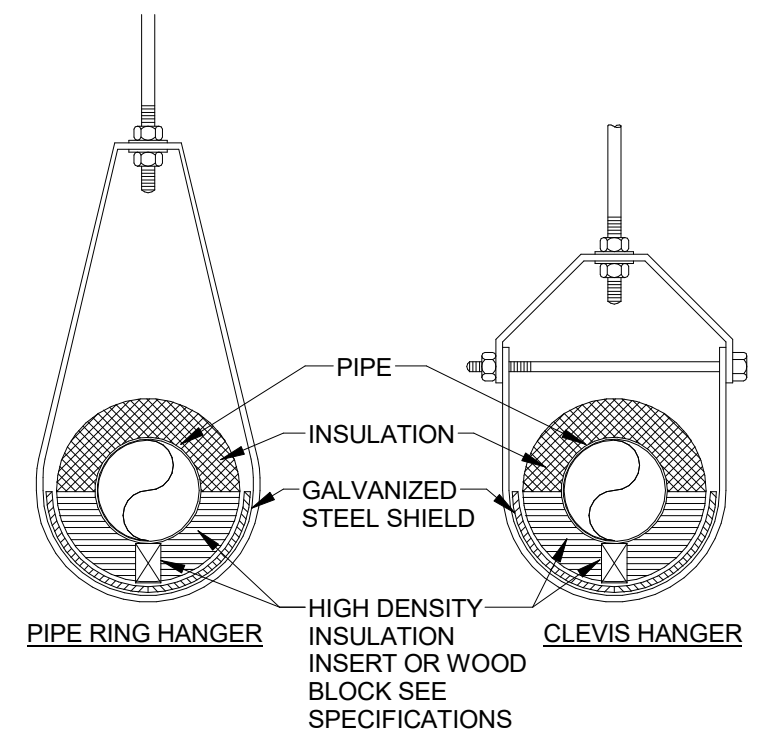

4 INSULATED PIPE AT HANGER DETAIL
P501 1/8" = 1'-0" 0 4' 8' 16'

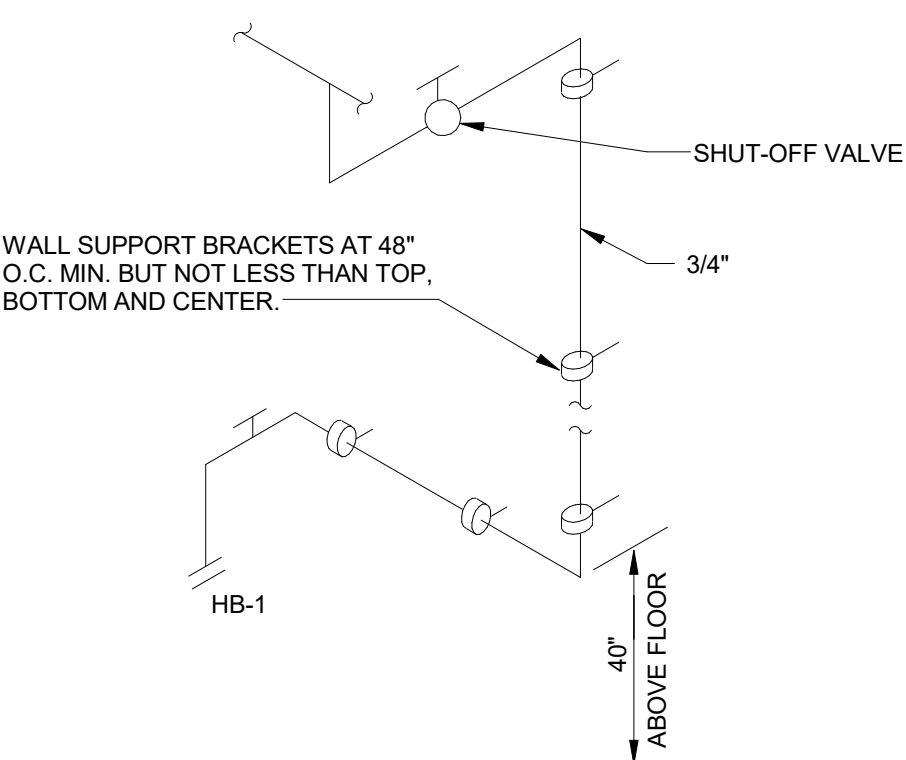

3 INTERIOR HOSE BIBB PIPING RISER
P501 1/8" = 1'-0" 0 4' 8' 16'

NO.	DATE	REVISION
3	4/6/17	ADDENDUM 3

ALTERATION / ADDITION
OUTAGAMIE COUNTY ADMINISTRATION CENTER
S. WALNUT & W. 8TH, APPLETON, WI 54911
PLUMBING DETAILS

DESIGNED	DRAWN
NDK	NDK
PROJECT NO.	00002-61600160
DATE	MARCH 3, 2017
SHEET NO.	P501